

WD-1

# DEMARKATION

WORKING DRAWING - I

SHEET NO.

## AREA OF PROPOSED SITE

(BY RECTANGLE AREA METHOD)

$$\begin{aligned} \text{AREA OF } \square ABCD &= LB \\ &= (28 \times 21.50) \text{ M} \\ &= 602.50 \text{ M} \end{aligned}$$

(BY TRIANGULATION METHOD)

$$\begin{aligned} \text{AREA OF } \square ABCD &= A(\triangle ABC) + A(\triangle ADC) \\ &= \frac{1}{2} AC \times BE + \frac{1}{2} AC \times DE \\ &= 301 + 301 \\ &= 602 \text{ M}^2 \end{aligned}$$

### NOTE-

1. ALL DIMENSIONS ARE IN MM UNIT UNTIL SPECIFIED.
2. DO NOT MEASURE DRAWING, FOLLOW WRITTEN DIMENSIONS ONLY.
3. PLEASE REFER TO THE ARCHITECT IN CONCERN TO ANY QUERY OF DRAWING.
4. THE DRAWING IS THE PROPERTY OF ARCHITECT AND SHALL NOT BE USED OR REPRODUCED WITHOUT THEIR WRITTEN CONCENT.

| SCALE | DATE | DRAWN BY | CHECKED BY | REV NO. |
|-------|------|----------|------------|---------|
|       |      | VK       |            |         |



SUBJECT-

PROPOSED  
RESIDENCE AT  
HOMKAR NAGAR,  
SOLAPUR.




ARCHITECT -

NAME - VAISHNAVI GUNVANT KARBHARI.  
BATCH - 3RD YEAR [SEM - VI].  
COLLEGE NAME - SSSM'S COLLEGE  
OF ARCHITECTURE, SOLAPUR.  
ROLL NO. - SSM/21/08.

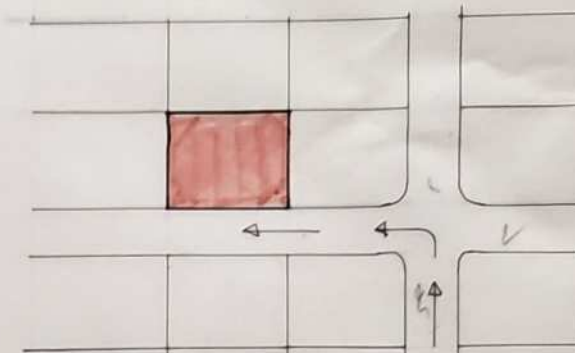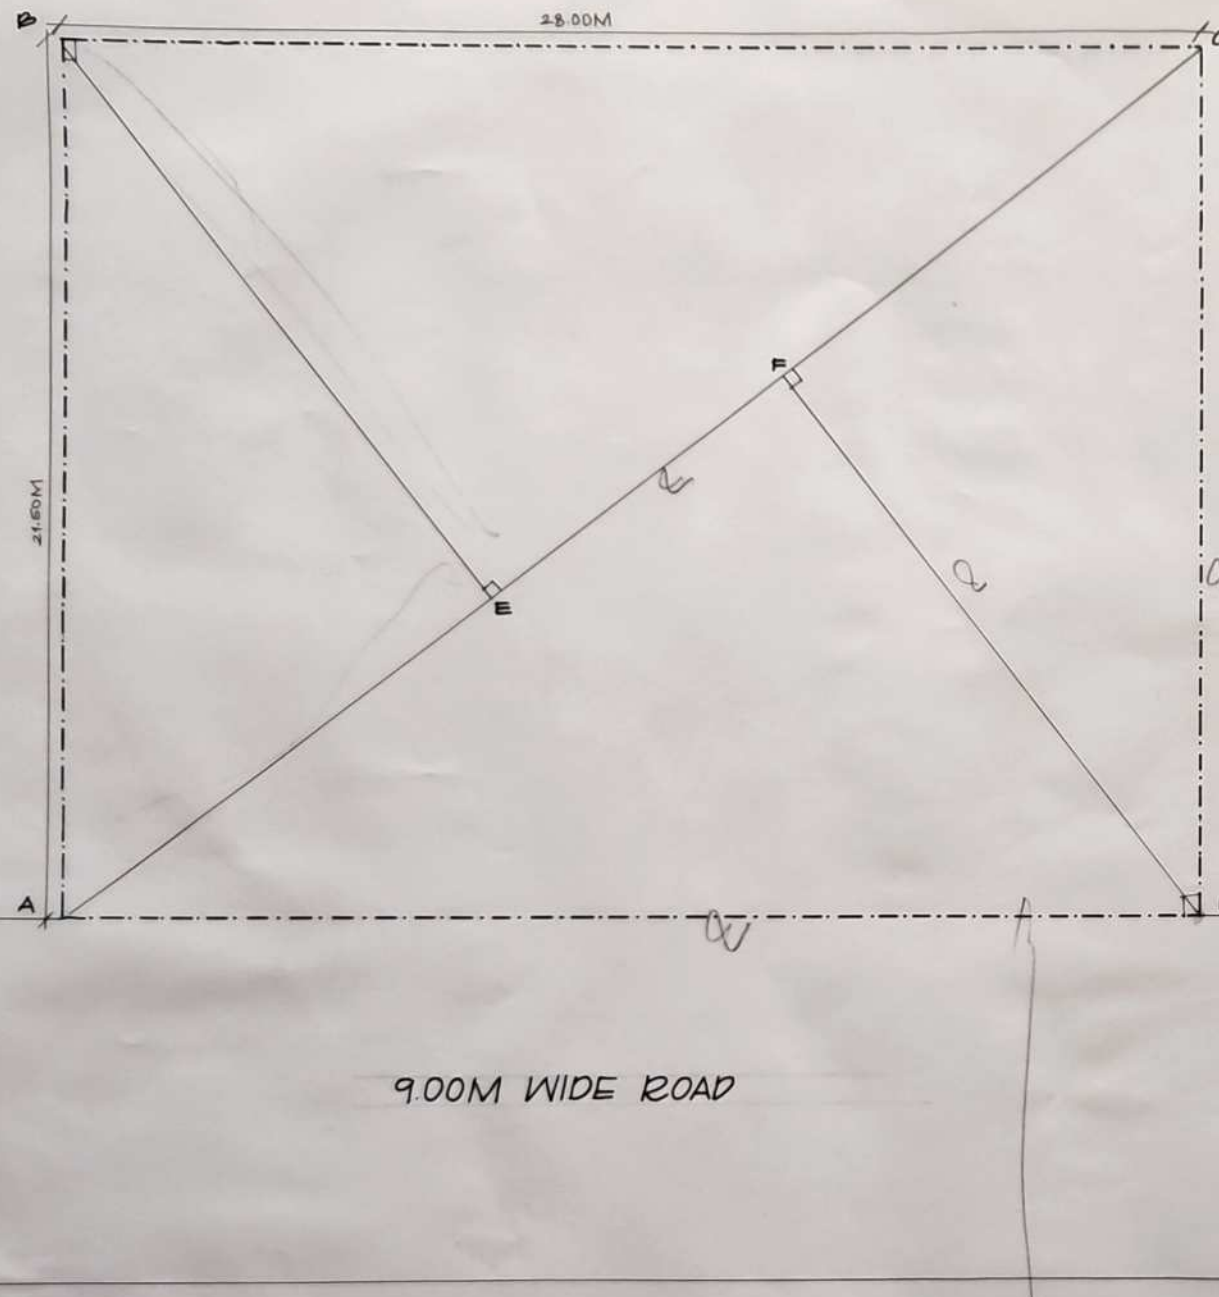


PLOTTING

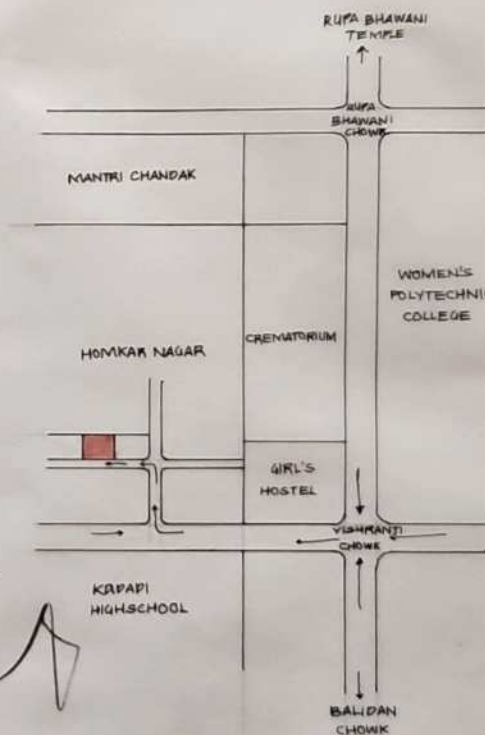

LOCATION

WORKING DRAWING FOR MR RAUT,

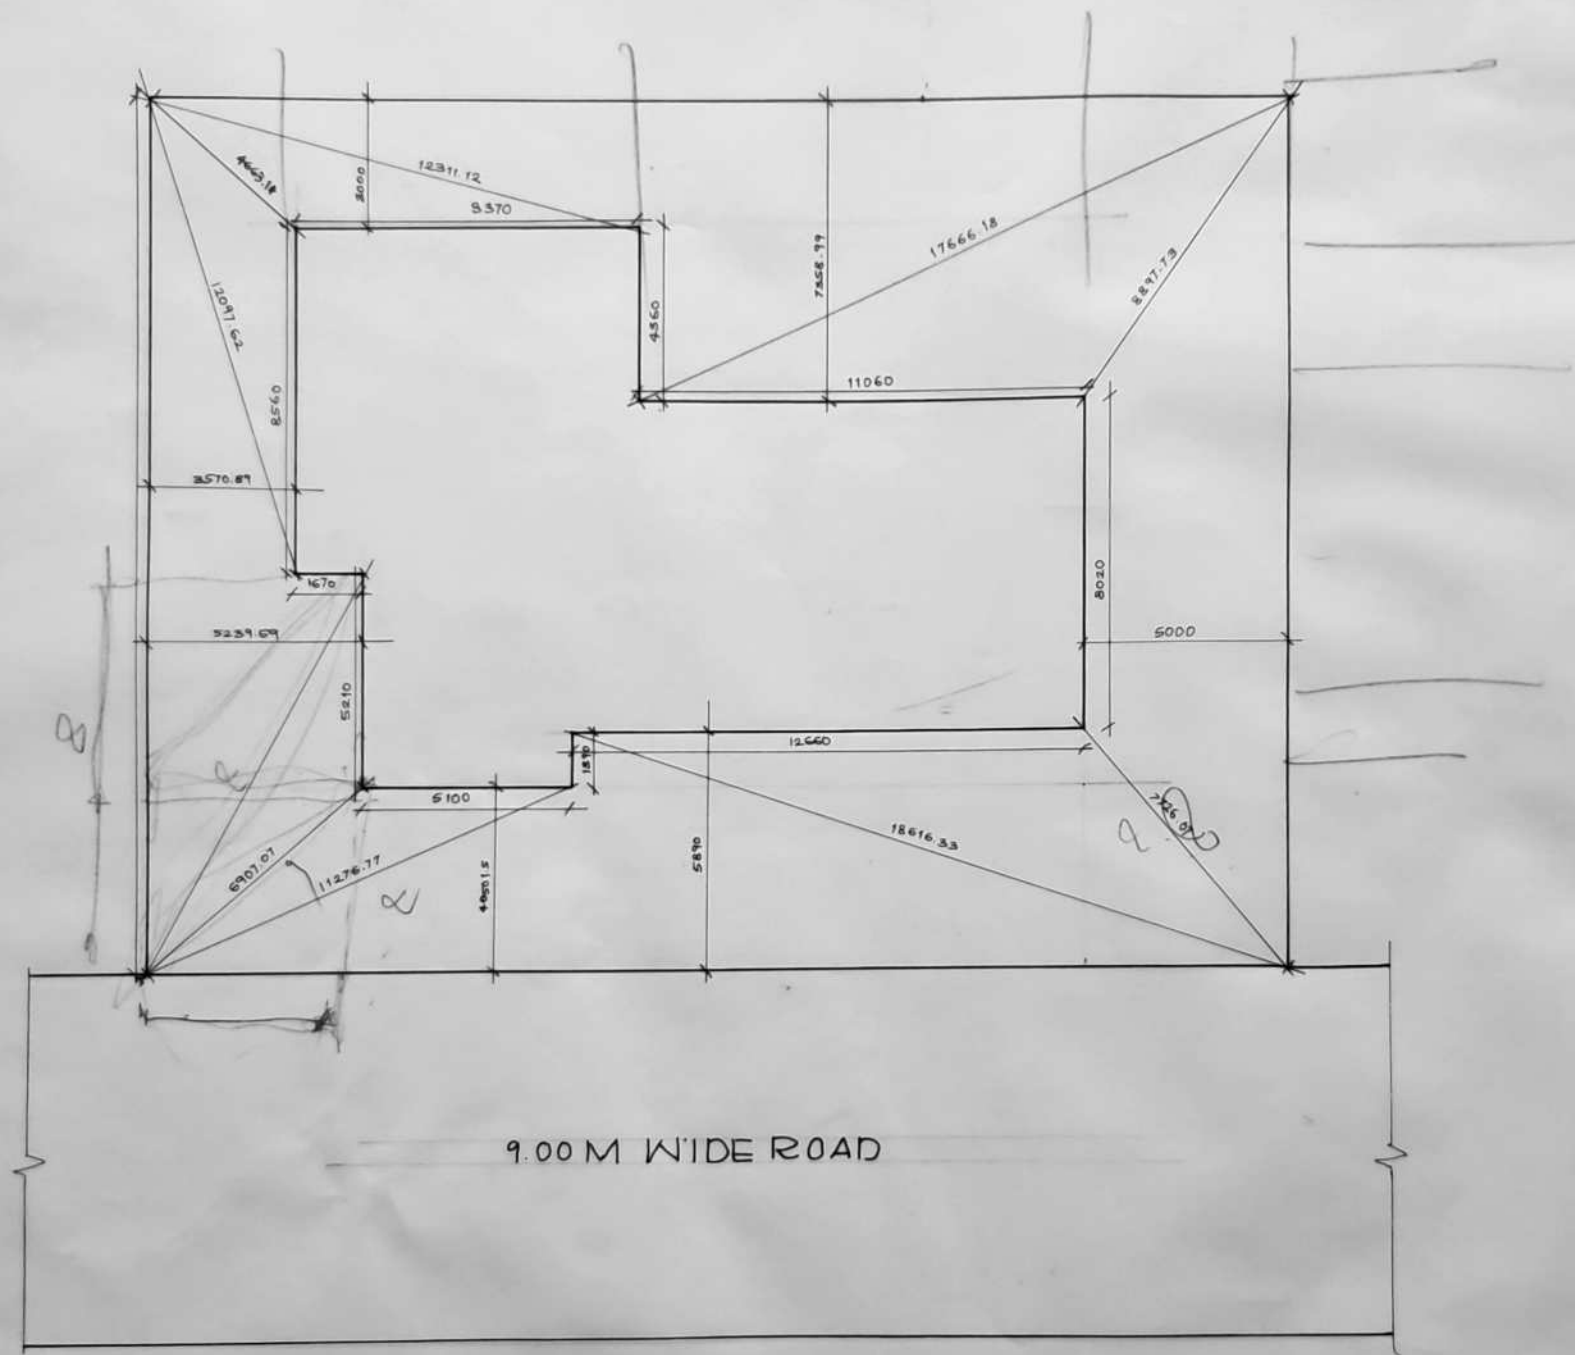

BLOCK PLAN

SCALE - 1:100

## SECTION

WORKING DRAWING - 1 SHEET NO.

- NOTE -
1. ALL DIMENSIONS ARE IN MM UNIT UNTIL SPECIFIED.
  2. DO NOT MEASURE DRAWING, FOLLOW WRITTEN DIMENSIONS ONLY.
  3. PLEASE REFER TO THE ARCHITECT IN CONCERN TO ANY QUERY OF DRAWING.
  4. THE DRAWING IS A PROPERTY OF THE ARCHITECT AND SHALL NOT BE USED OR REPRODUCED WITHOUT THEIR WRITTEN CONCENT.

| SCALE | DATE | DRAWN BY | CHECKED BY | REV NO. |
|-------|------|----------|------------|---------|
|       |      | VK       |            |         |

SUBJECT -

PROPOSED  
RESIDENCE AT  
HOMKAR NAGAR,  
SOLAPUR.



ARCHITECT -


NAME - VAISHNAVI GUNVANT KARBHARI.  
BATCH - 3RD YEAR [SEM - VI]  
COLLEGE NAME - SSSM'S COLLEGE  
OF ARCHITECTURE, SOLAPUR.  
ROLL NO. - SSM/21/08

WORKING DRAWING FOR MR RAUT

#



Ajagda  
7-5-22

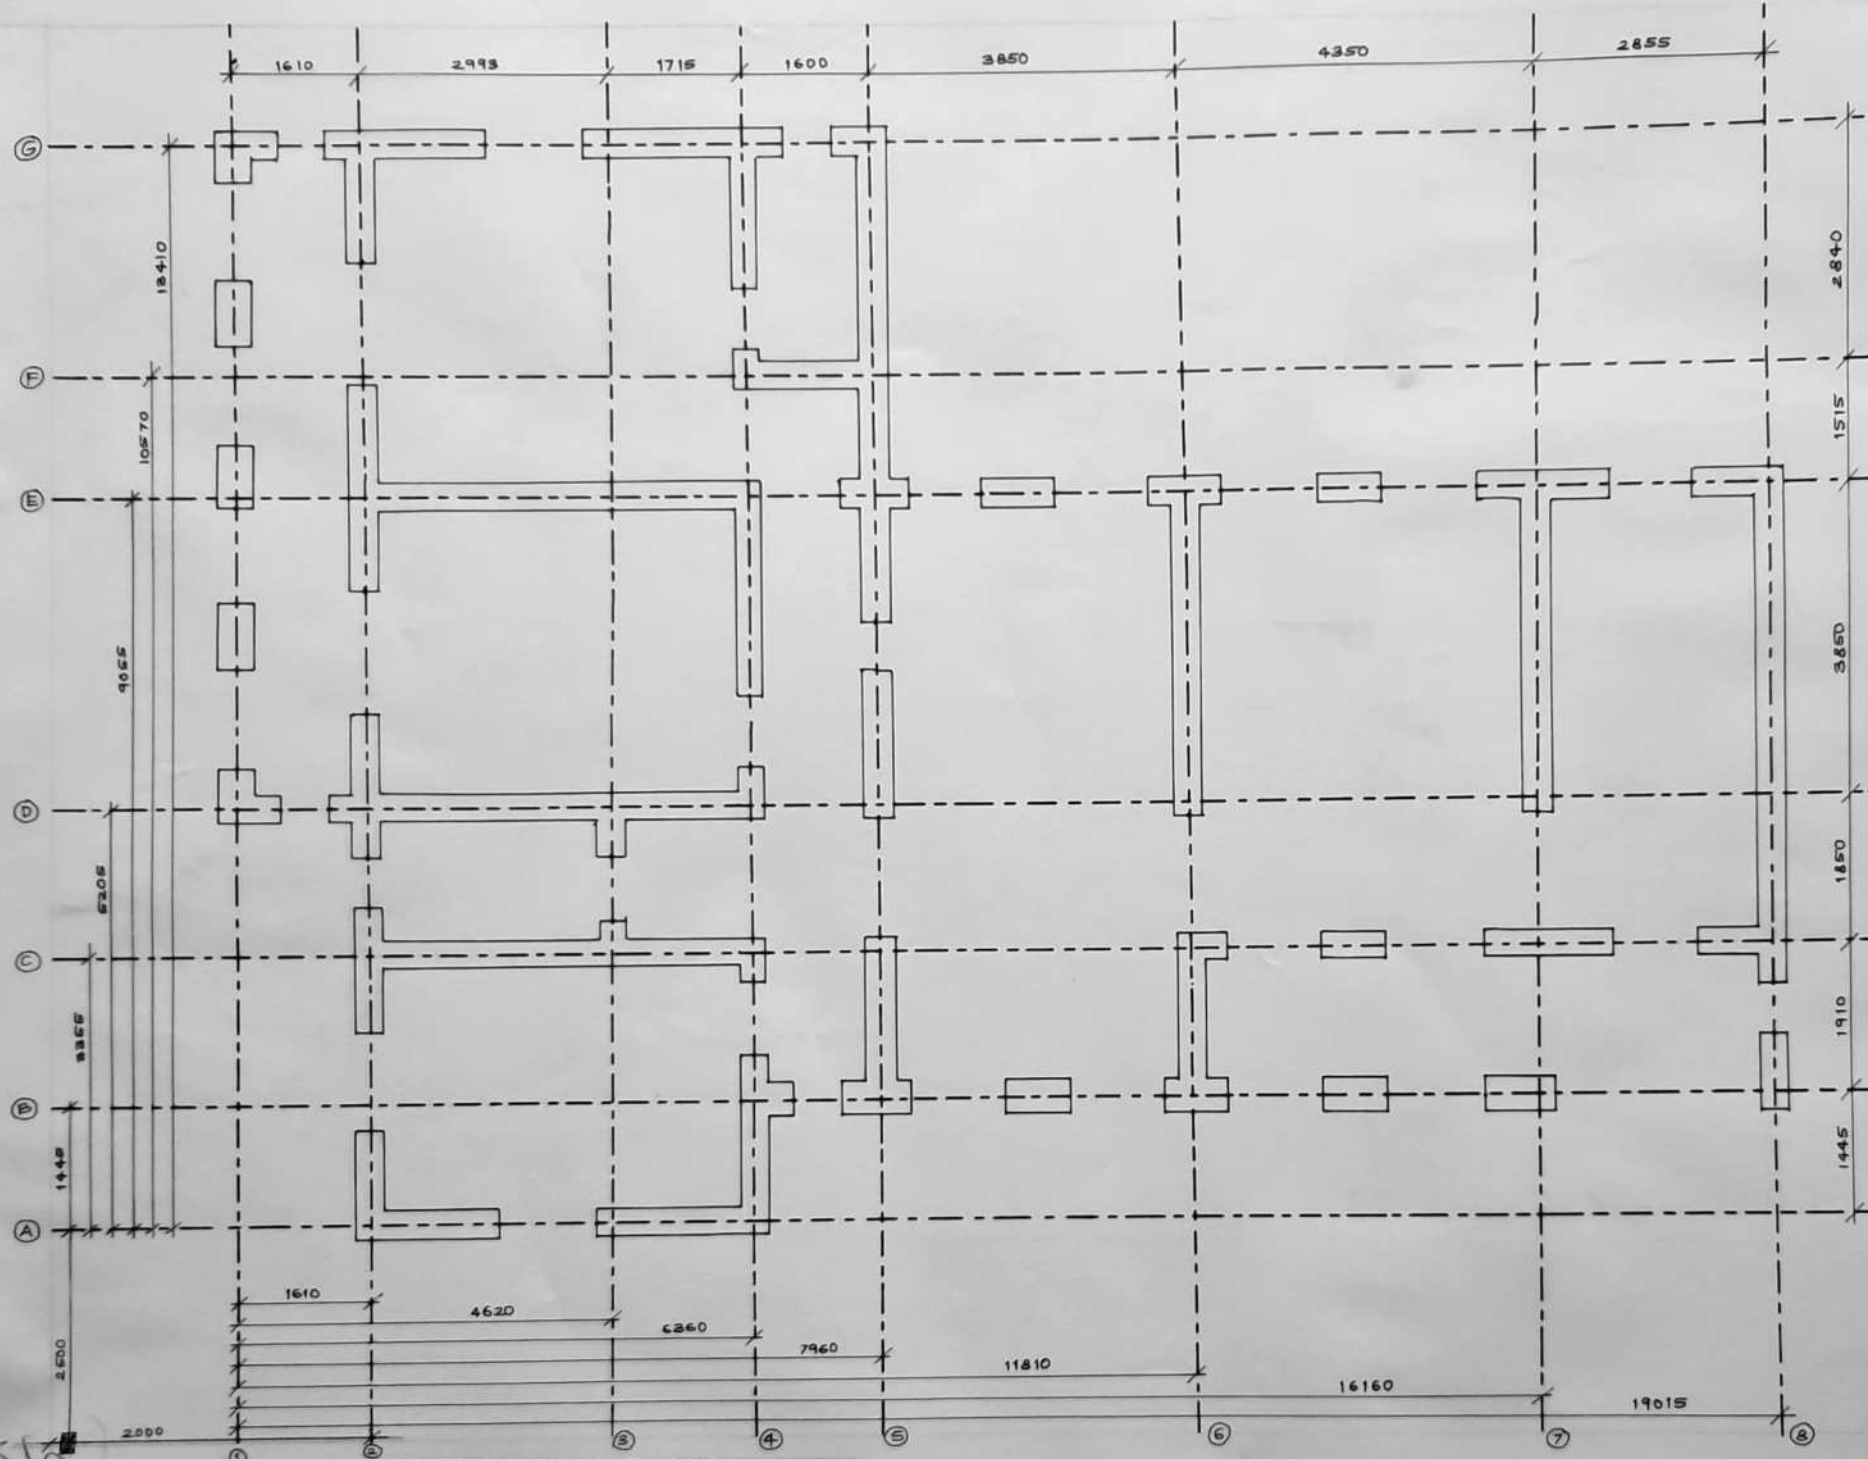


CENTRELINE PLAN

SCALE - 1:150

# CENTRELINE PLAN

WORKING DRAWING - I

SHEET NO.

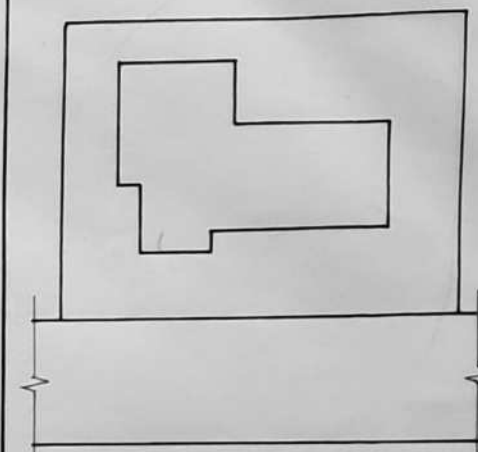

KEY PLAN

SCALE - 1:200

## NOTE-

1. ALL DIMENSIONS ARE IN MM UNIT UNTIL SPECIFIED.
2. DO NOT MEASURE DRAWING, FOLLOW WRITTEN DIMENSIONS ONLY.
3. PLEASE REFER TO THE ARCHITECT IN CONCERN TO ANY QUERY OF DRAWING.
4. THE DRAWING IS A PROPERTY OF AN ARCHITECT AND SHALL NOT BE USED OR REPRODUCED WITHOUT THEIR WRITTEN CONCENT.

| SCALE | DATE | DRAWN BY | CHECKED BY | REV. NO. |
|-------|------|----------|------------|----------|
| 1:50  |      | VK       |            |          |

SUBJECT-


PROPOSED  
RESIDENCE AT  
HOMKAR NAGAR  
SOLAPUR.



ARCHITECT-


NAME-VAISHNAVI GUNVANT KARBHARI.  
BATCH - 3RD YEAR [SEM VI]  
COLLEGE NAME - GSSM'S COLLEGE  
OF ARCHITECTURE, SOLAPUR.  
ROLL NO. - SSM/21/08.

WORKING DRAWING FOR MR. RAUT

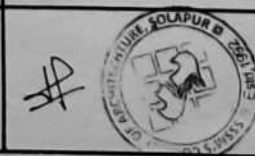

7-6-23



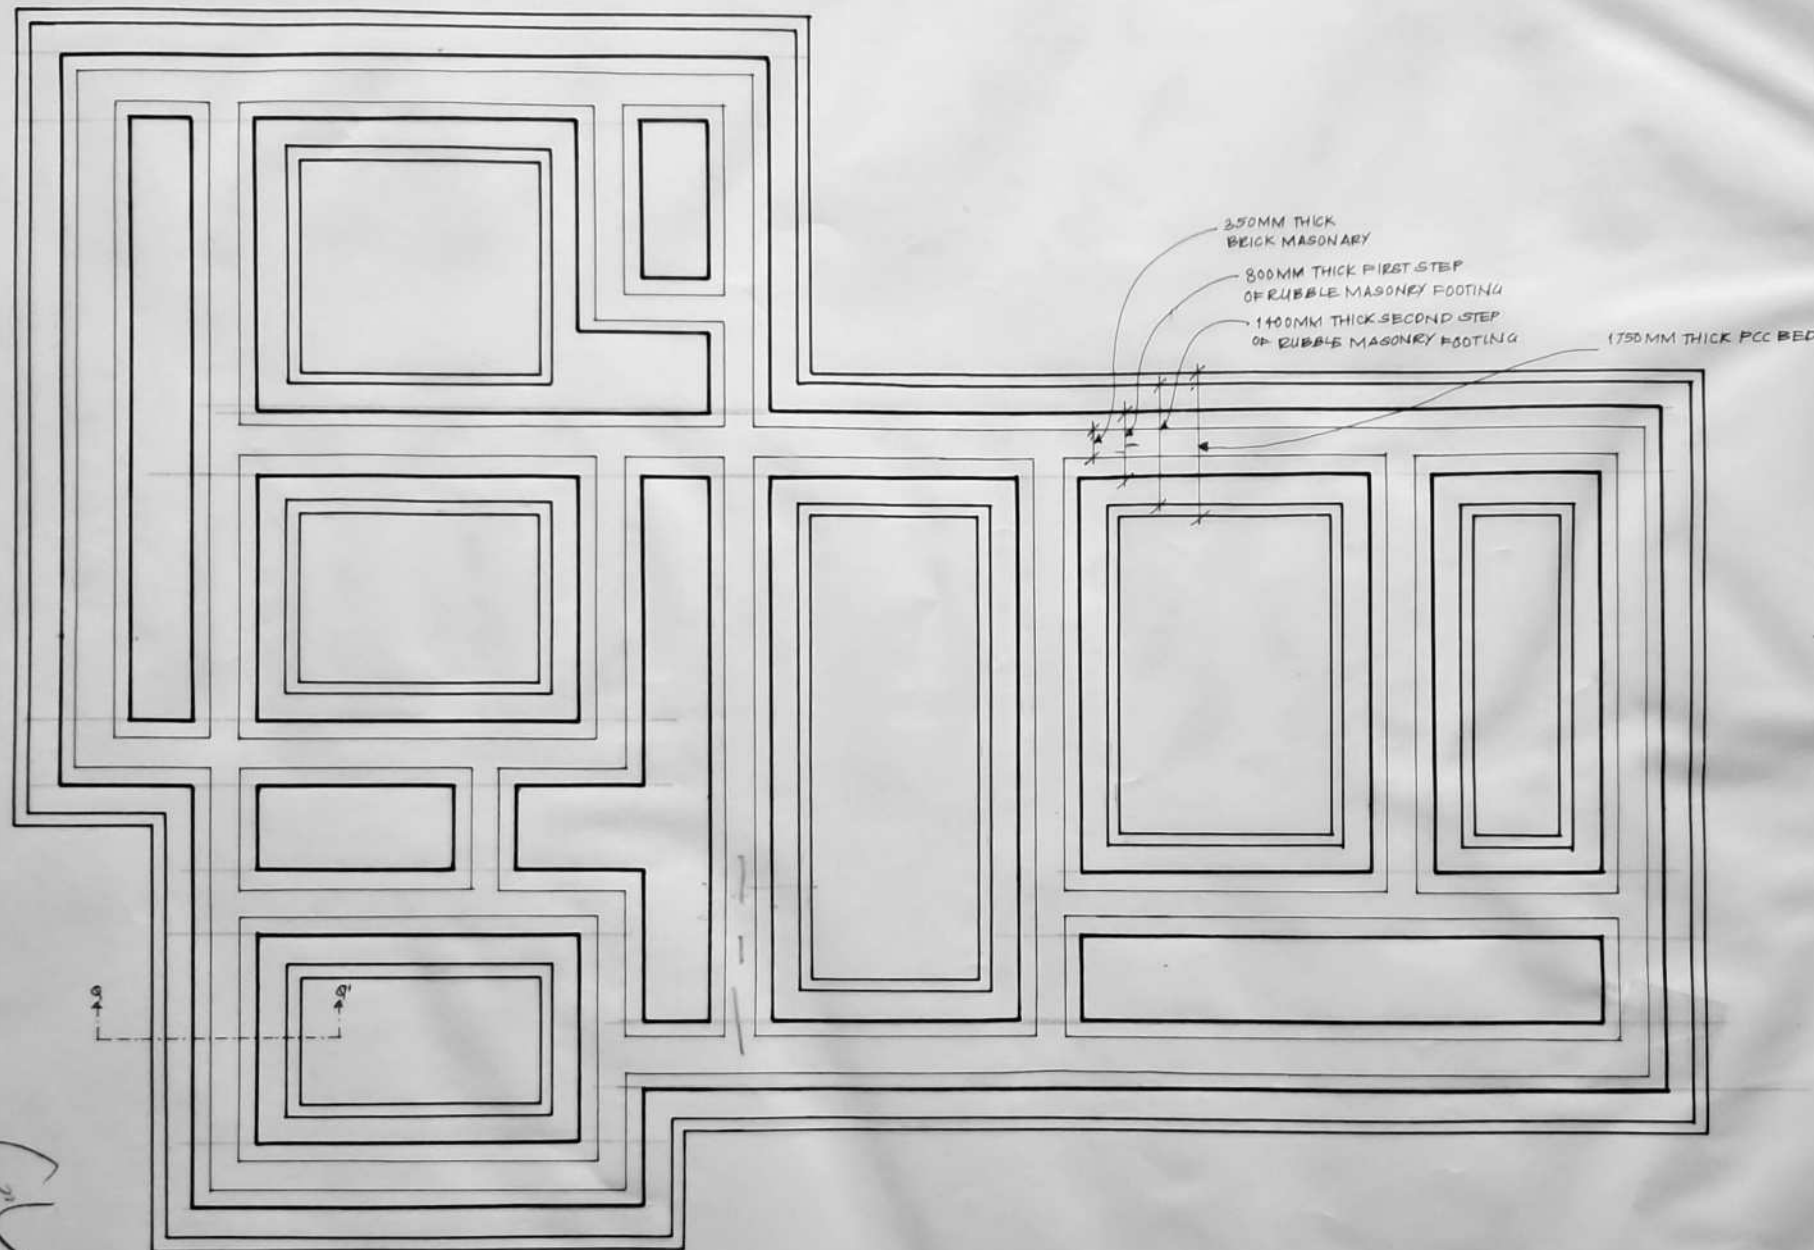


FOUNDATION PLAN  
SCALE - 1:50

# FOUNDATION PLAN

WORKING DRAWING - 1

SHEET NO.

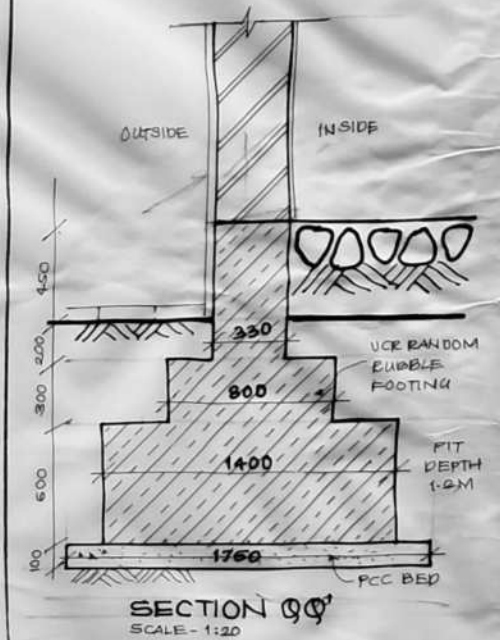

- NOTE -
1. ALL DIMENSIONS ARE IN MM UNLESS AT UNIT IS SPECIFIED.
  2. DO NOT MEASURE DRAWING, FOLLOW WRITTEN DIMENSIONS ONLY.
  3. PLEASE REFER TO THE ARCHITECT IN CONCERN TO ANY QUERY OF DRAWING.
  4. THE DRAWING IS A PROPERTY OF THE ARCHITECT AND SHALL NOT BE USED OR REPRODUCED WITHOUT THEIR WRITTEN CONCENT

| SCALE | DATE | DRAWN BY | CHECKED BY | REV NO. |
|-------|------|----------|------------|---------|
| 1:50  |      | VK       |            |         |

SUBJECT -

PROPOSED  
RESIDENCE AT  
HOMKAR NAGAR  
SOLAPUR.



ARCHITECT -

NAME - VAISHNAVI GUNVANT KARBHARI.  
BATCH - 3RD YEAR [SEM - VI]  
COLLEGE NAME - SSSM'S COLLEGE OF ARCHITECTURE, SOLAPUR.  
ROLL NO. - SSM/21/08

WORKING DRAWING FOR MR RAUT



# TERRACE PLAN

WORKING DRAWING - 1 SHEET NO.

SLOPE CALCULATION  
RATIO - 1:150

$$A) \frac{150}{120} = 0.125$$

$$B) \frac{150}{89} = 0.125$$

$$C) \frac{150}{110} = 0.125$$

## NOTE -

1. ALL DIMENSIONS ARE IN MM UNIT UNTIL SPECIFIED.
2. DO NOT MEASURE DRAWING, FOLLOW WRITTEN DIMENSIONS ONLY.
3. PLEASE REFER TO THE ARCHITECT IN CONCERN TO ANY QUERY OF DRAWING.
4. THE DRAWING IS THE PROPERTY OF THE ARCHITECT AND SHALL NOT BE USED OR REPRODUCED WITHOUT THEIR WRITTEN CONCENT.


| SCALE | DATE | DRAWN BY | CHECKED BY | REV NO. |
|-------|------|----------|------------|---------|
|       |      | VK       |            |         |

SUBJECT -

**PROPOSED  
RESIDENCE AT  
HOMKAG NAGAR,  
SOLAPUR.**

ARCHITECT -


NAME - VAISHNAVI GUNVANT KAPBHARI.  
BATCH - 3RD YEAR [SEM - VI]  
COLLEGE NAME - SSSM'S COLLEGE  
OF ARCHITECTURE, SOLAPUR.  
ROLL NO. - SSM/21/08.

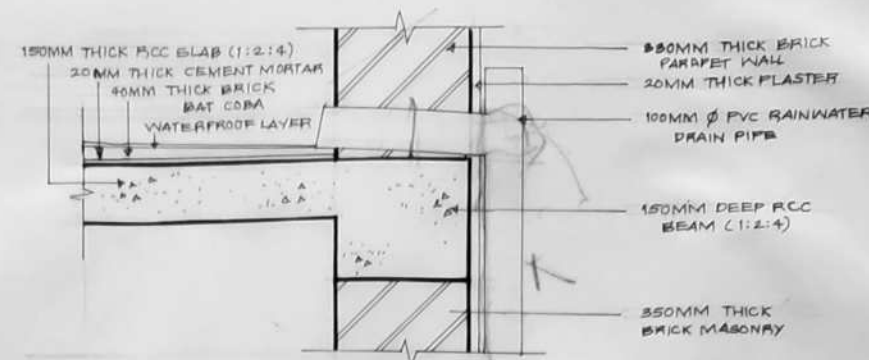

RAIN-WATER DRAIN-PIPE AND COBA DETAIL

SCALE - 1:10

DRAINOUT ②

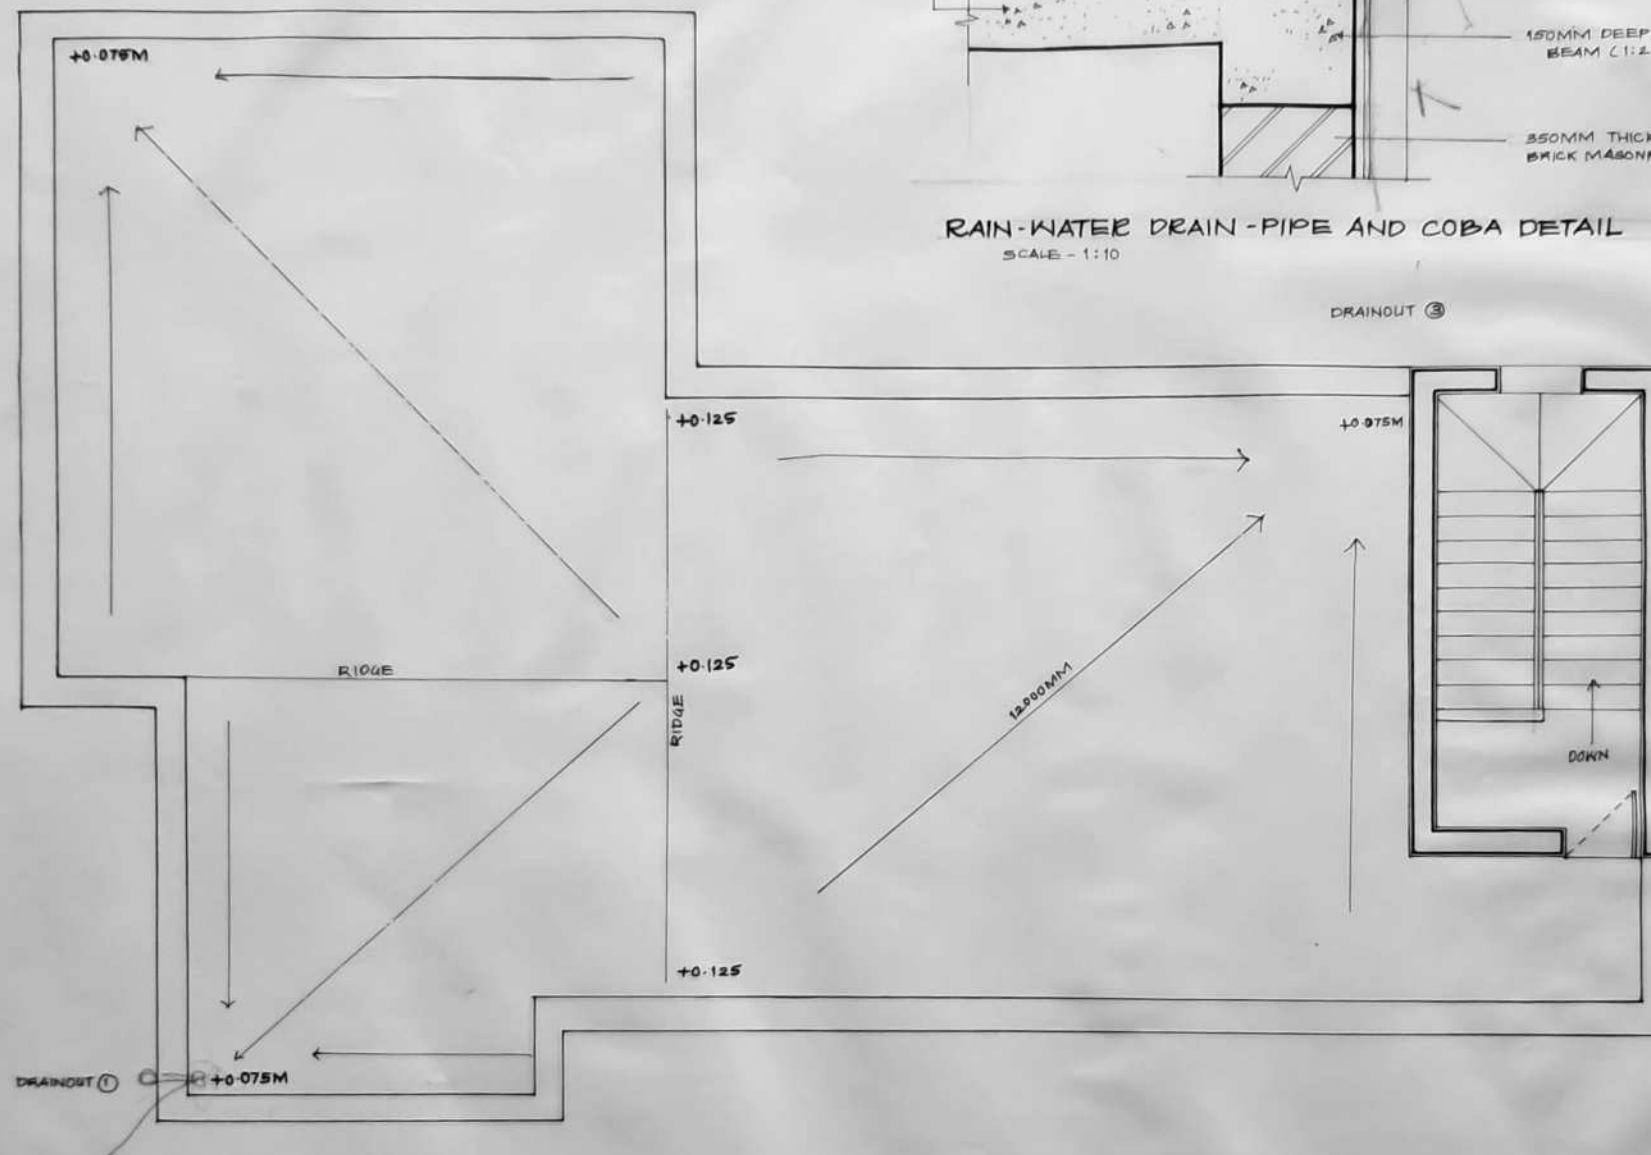

TERRACE PLAN

SCALE - 1:50

WORKING DRAWING FOR MR. RAUT



# FLOOR PLAN

WORKING DRAWING - I

SHEET NO.

D<sub>1</sub> - 900 X 2400 - FLUSH DOOR WITH VINEER  
D<sub>2</sub> - 1200 X 2400 - WOODEN DOOR  
D<sub>3</sub> - 1500 X 2400 - WOODEN DOOR  
D<sub>4</sub> - 750 X 2400 - FLUSH DOOR WITH VINEER  
W<sub>1</sub> - 1200 X 1800 - UPVC  
W<sub>2</sub> - 1200 X 1200 - UPVC  
W<sub>3</sub> - 1500 X 1800 - UPVC  
W<sub>4</sub> - 1000 X 1500 - UPVC  
W<sub>5</sub> - 800 X 1800 - UPVC  
V<sub>1</sub> - 600 X 600 - UPVC  
OP<sub>1</sub> - 1200 X 2400 - PLASTERED FRAME  
OP<sub>2</sub> - 600 X 1800 - PLASTERED FRAME  
OP<sub>3</sub> - 1500 X 2400 - ARTIFICIAL QUARTZ STONE  
OP<sub>4</sub> - 2200 X 2400 - PLASTERED FRAME  
OP<sub>5</sub> - 600 X 800 - ARTIFICIAL QUARTZ STONE  
INTERNAL PAINT - LUSTRE  
EXTERNAL PAINT - APEX

NOTE -  
1. ALL DIMENSIONS ARE IN MM UNIT UNTIL SPECIFIED  
2. DO NOT MEASURE DRAWING, FOLLOW WRITTEN DIMENSIONS ONLY  
3. PLEASE REFER TO THE ARCHITECT IN CONCERN TO ANY QUERY OF DRAWING.  
4. THE DRAWING IS A PROPERTY OF THE ARCHITECT AND SHALL NOT BE USED OR REPRODUCED WITHOUT THEIR WRITTEN CONCENT

| SCALE | DATE | DRAWN BY | CHECKED BY | KEY NO. |
|-------|------|----------|------------|---------|
| 1:50  |      | YK       |            |         |

SUBJECT - \*


PROPOSED  
RESIDENCE AT  
HOMKAR NAGAR  
SOLAPUR.



ARCHITECT -

NAME - VAISHNAVI GUNVANT KARBHARI.  
BATCH - 3RD YEAR [SEM - VI].  
COLLEGE NAME - SSSM'S COLLEGE OF ARCHITECTURE, SOLAPUR.  
ROLL NO. - SSSM/21/08

WORKING DRAWING FOR MR. RAUT

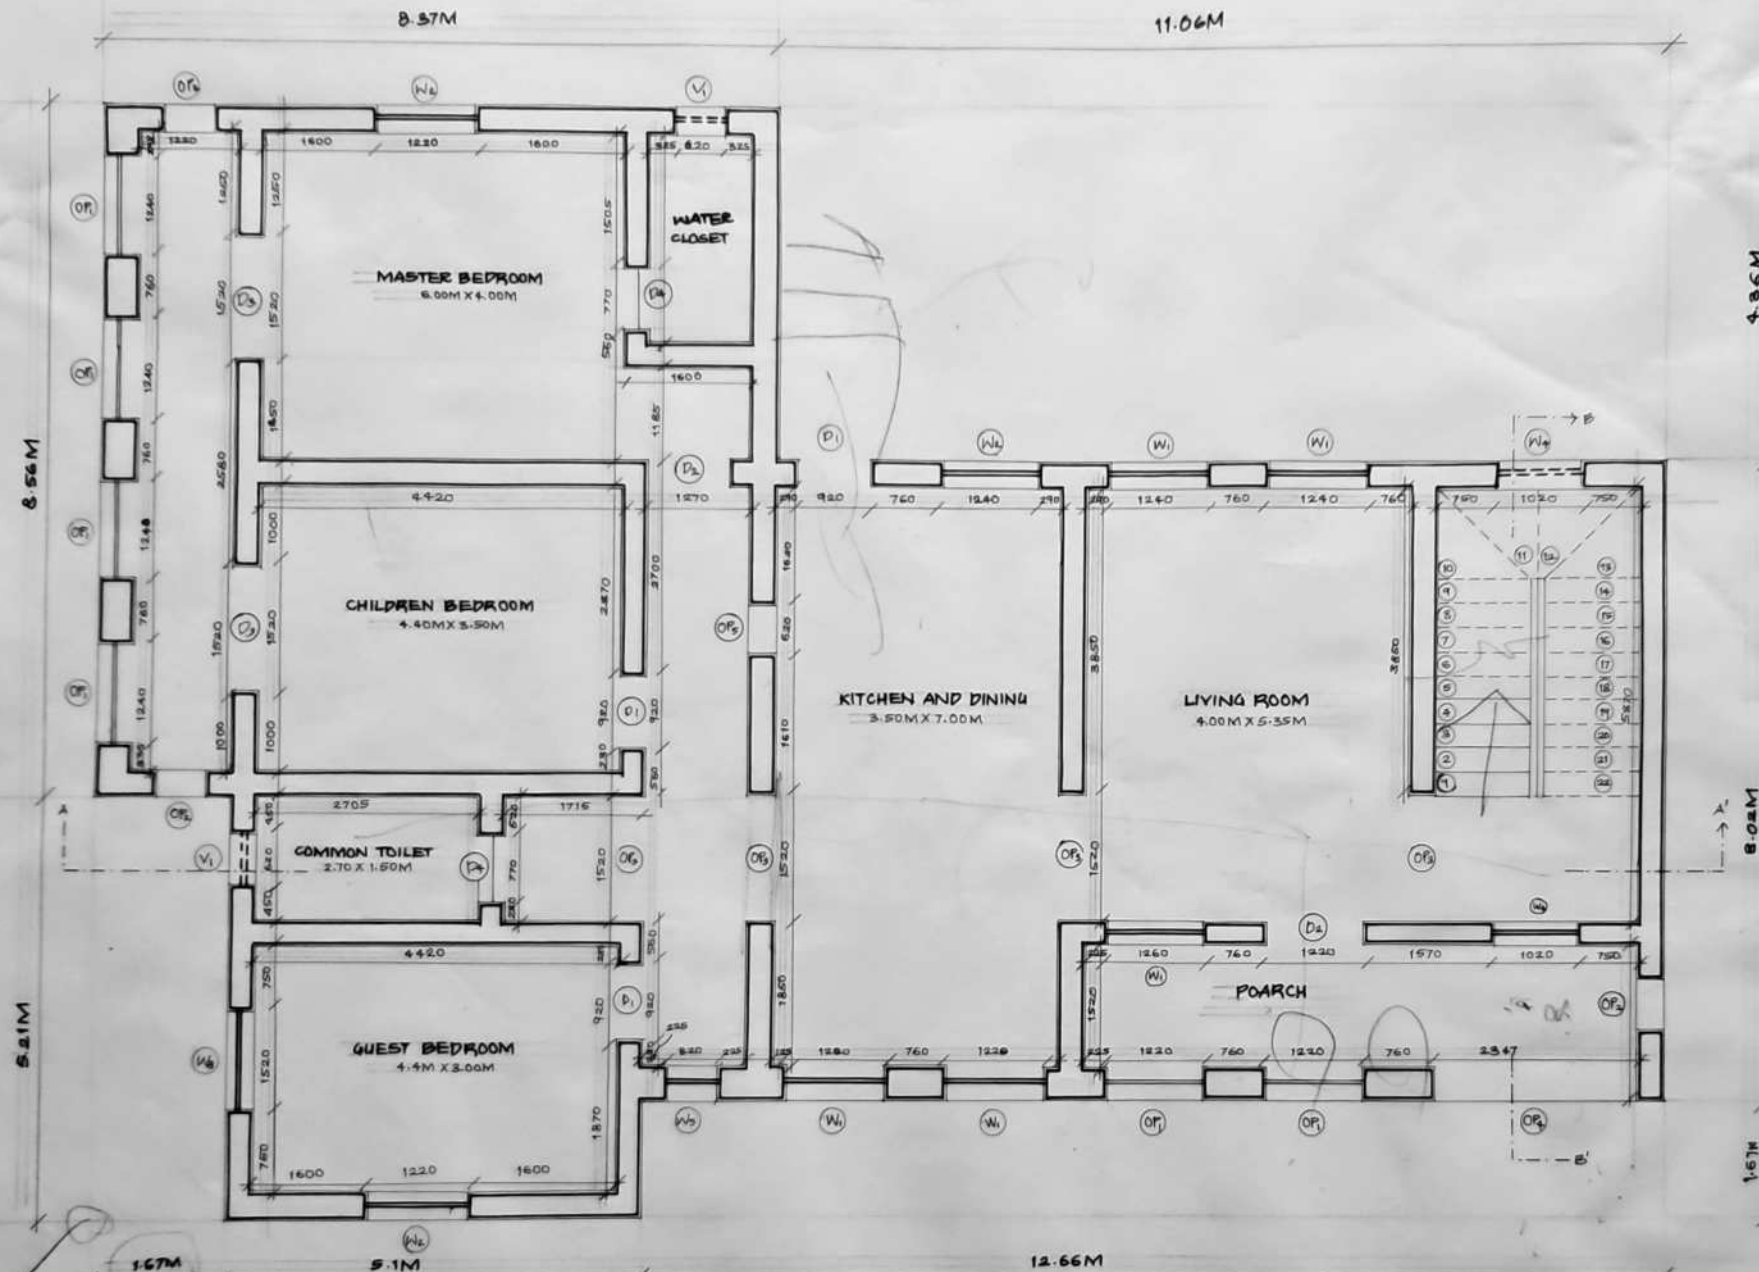


GROUND FLOOR PLAN.

SCALE - 1:50

Handwritten notes: "Toller", "Lett", "Hear", "Step".






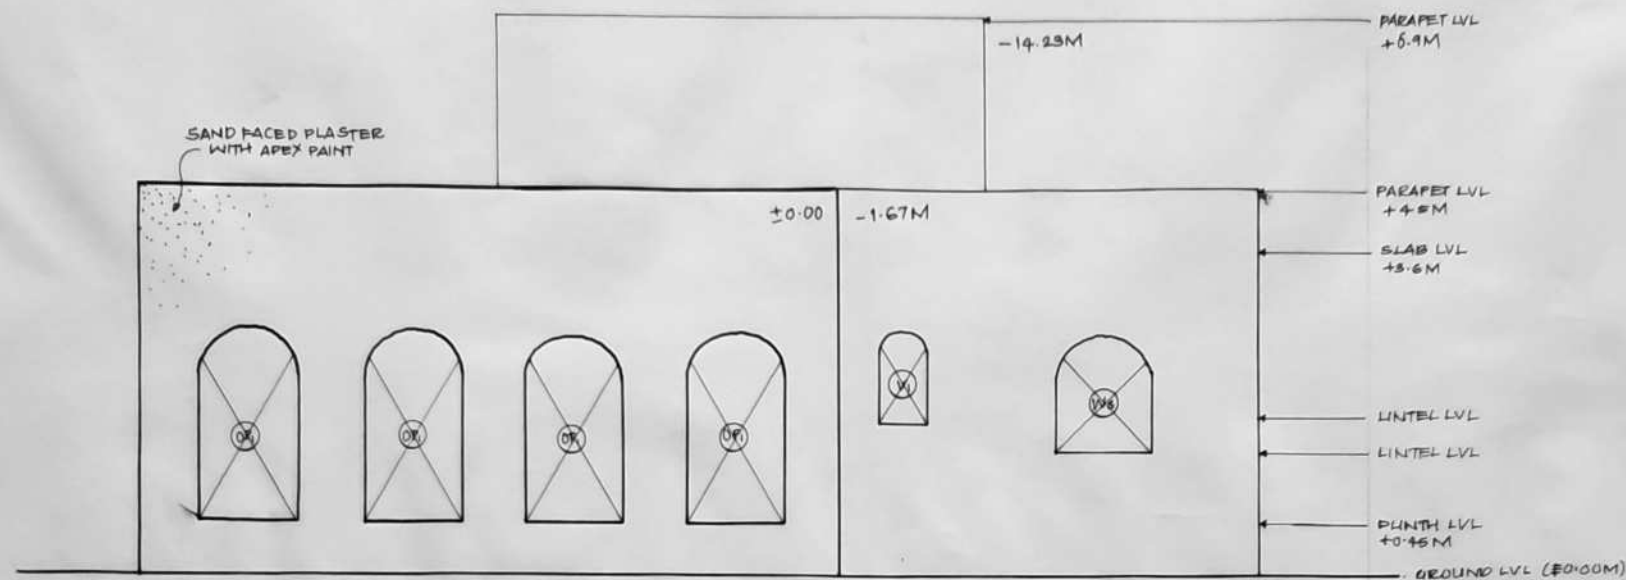

WEST-SIDE ELEVATION

SCALE - 1:50

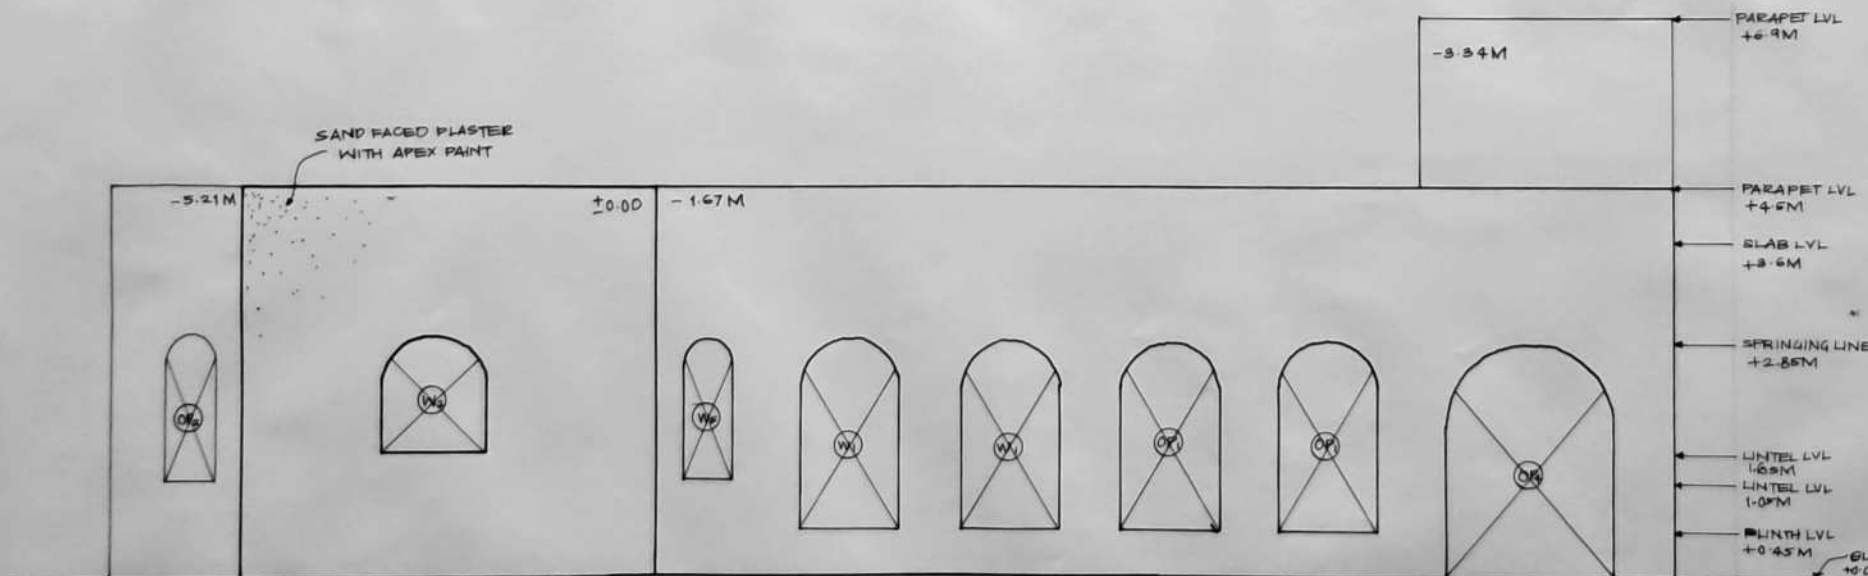


SOUTH-SIDE ELEVATION

SCALE - 1:50

## ELEVATION

WORKING DRAWING - I

SHEET NO.

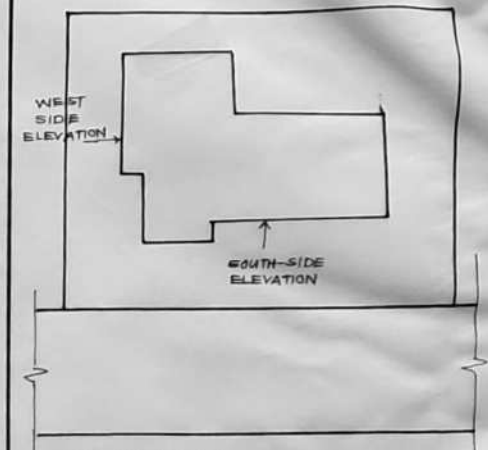

KEY PLAN

SCALE - 1:200

- NOTE -
1. ALL DIMENSIONS ARE IN MM UNTIL SPECIFIED.
  2. DO NOT MEASURE DRAWING, FOLLOW WRITTEN DIMENSIONS ONLY.
  3. PLEASE REFER TO THE ARCHITECT IN CONCERN OF ANY QUERY.
  4. THE DRAWING IS THE PROPERTY OF THE ARCHITECT AND SHALL NOT BE USED OR REPRODUCED WITHOUT THEIR WRITTEN CONCENT.

| SCALE | DATE | DRAWN BY | CHECKED BY | REV NO. |
|-------|------|----------|------------|---------|
| 1:50  |      | VK       |            |         |

SUBJECT-

**PROPOSED  
RESIDENCE AT  
HOMKAR NAGAR  
SOLAPUR.**

ARCHITECT -


NAME - VAISHNAVI GUNYANT KARBHARI.  
BATCH - 3RD YEAR [SEM - VI]  
COLLEGE NAME - SSSM'S COLLEGE  
OF ARCHITECTURE, SOLAPUR.  
ROLL NO - SSM/21/08.

WORKING DRAWING FOR MR RAUT




# ELEVATION

WORKING DRAWING-1 SHEET NO.

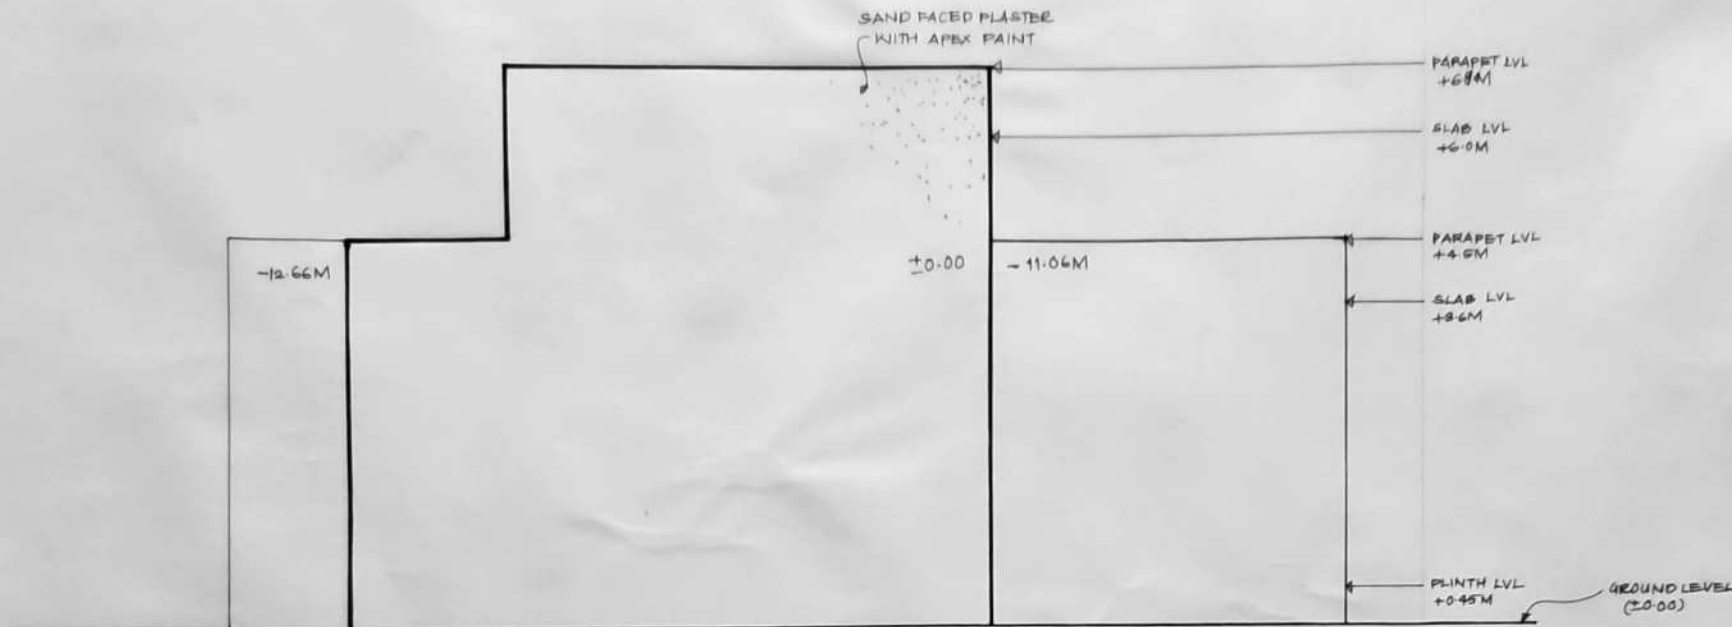

EAST-SIDE ELEVATION

SCALE - 1:50

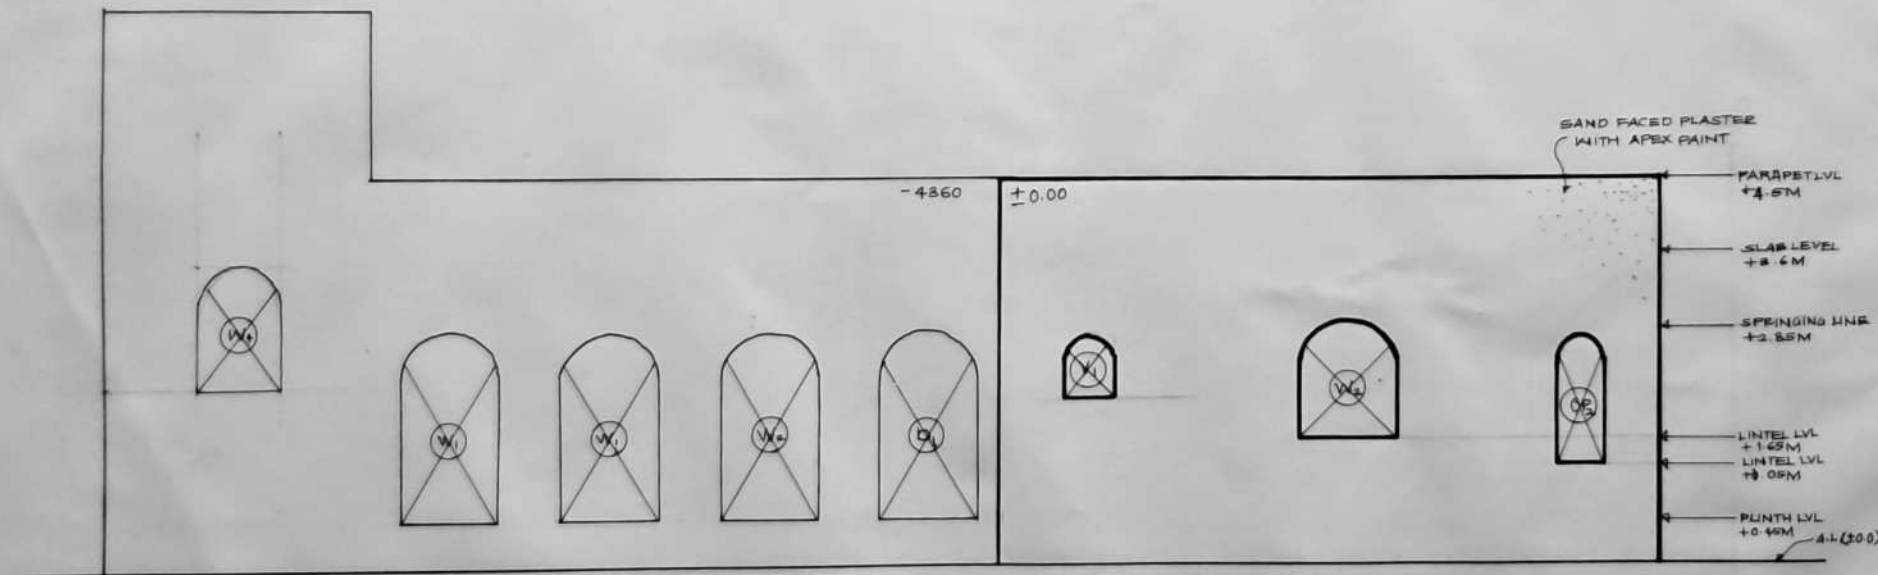

NORTH-SIDE ELEVATION

SCALE - 1:50

NOTE-

1. ALL DIMENSIONS ARE IN MM UNIT UNTIL SPECIFIED.
2. DO NOT MEASURE DRAWING, FOLLOW WRITTEN DIMENSIONS ONLY.
3. PLEASE REFER TO THE ARCHITECT IN CONCERN TO ANY QUERY.
4. THE DRAWING IS THE PROPERTY OF THE ARCHITECT AND SHALL NOT BE USED OR REPRODUCED WITHOUT THEIR WRITTEN CONCENT.

| SCALE | DATE | DRAWN BY | CHECKED BY | REV NO. |
|-------|------|----------|------------|---------|
| 1:50  |      | VK       |            |         |

SUBJECT-


**PROPOSED  
RESIDENCE AT  
HOMKAR NAGAR,  
SOLAPUR.**

ARCHITECT-

NAME-VAISHNAVI GUNVANT KARBHARI.  
BATCH - 3RD YEAR [SEM-VI]  
COLLEGE NAME - SSSM'S COLLEGE OF ARCHITECTURE, SOLAPUR.  
ROLL NO. - SSM/21/08.


WORKING DRAWING FOR MR RAUT



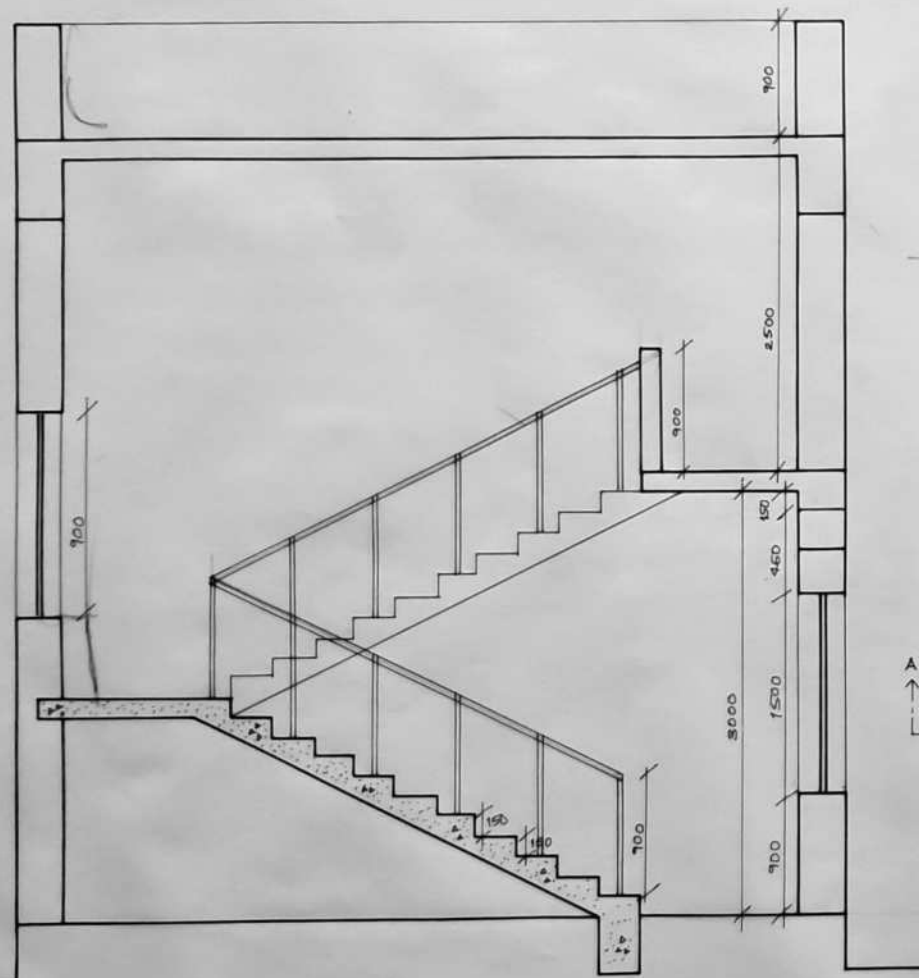


SECTION AA'

SCALE - 1:30

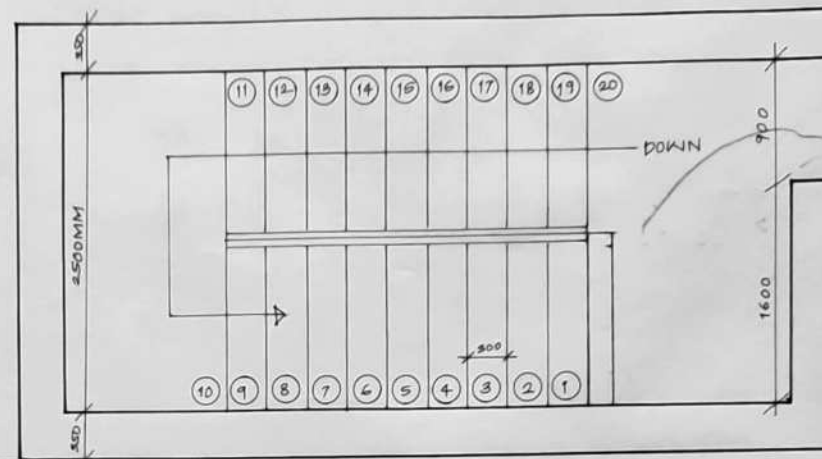

FIRST FLOOR PLAN

SCALE - 1:80

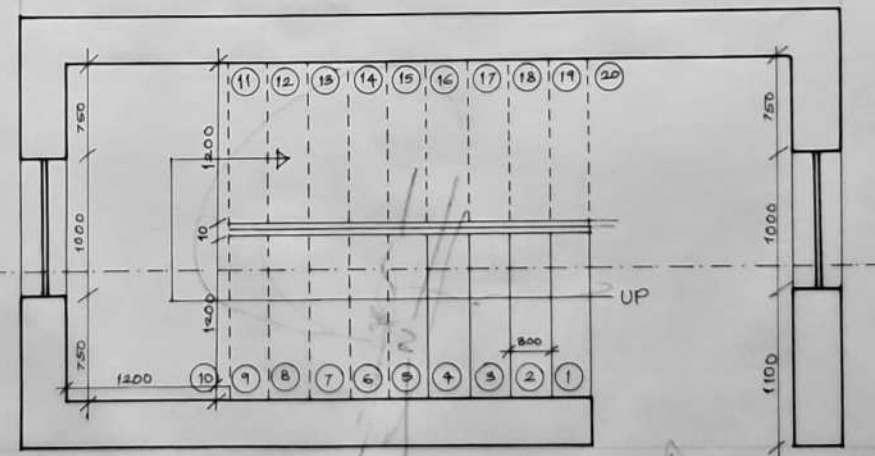


GROUND FLOOR PLAN

SCALE - 1:100

## STAIRCASE DETAIL

WORKING DRAWING - 1

SHEET NO.

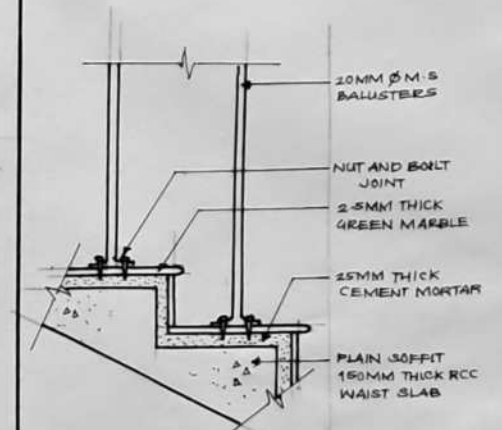

HANDRAIL FIXING DETAIL

SCALE - 1:10

### NOTE-

1. ALL DIMENSIONS ARE IN MM UNIT UNTIL SPECIFIED
2. DO NOT MEASURE DRAWING, FOLLOW WRITTEN DIMENSIONS ONLY.
3. PLEASE REFER TO THE ARCHITECT IN CONCERN OF ANY QUERY.
4. THE DRAWING IS THE PROPERTY OF THE ARCHITECT AND SHALL NOT BE USED OR REPRODUCED WITHOUT THEIR WRITTEN CONCENT

| SCALE | DATE | DRAWN BY | CHECKED BY | REV NO. |
|-------|------|----------|------------|---------|
| 1:80  |      | VK       |            |         |

SUBJECT-

PROPOSED  
RESIDENCE AT  
HOMKAR NAGAR,  
SOLAPUR.




ARCHITECT-

NAME - VAISHNAVI GUNVANT KARBHARI.  
BATCH - 3RD YEAR [SEM - VI]  
COLLEGE NAME - GSSM'S COLLEGE  
OF ARCHITECTURE, SOLAPUR.  
ROLL NO. - GSSM/21/08


WORKING DRAWING FOR MR RAUT



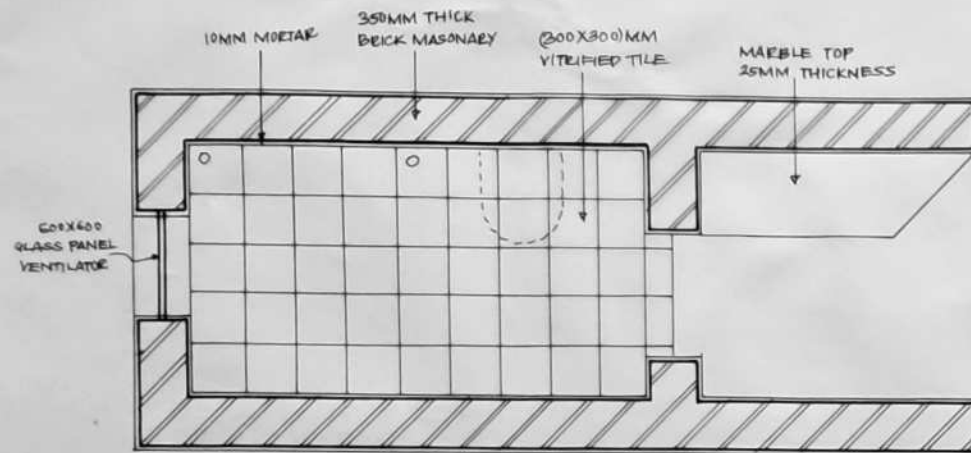



FLOORING LAYOUT PLAN

SCALE - 1:25

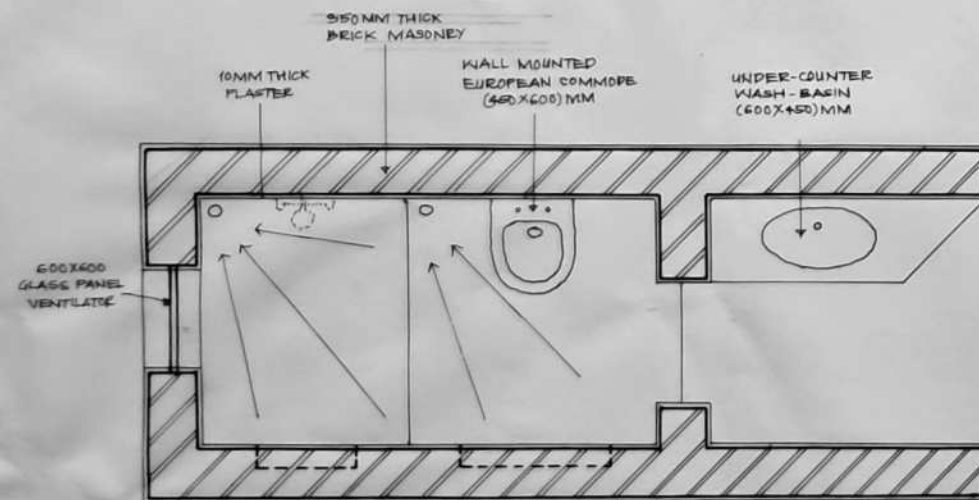

PLAN

SCALE - 1:25

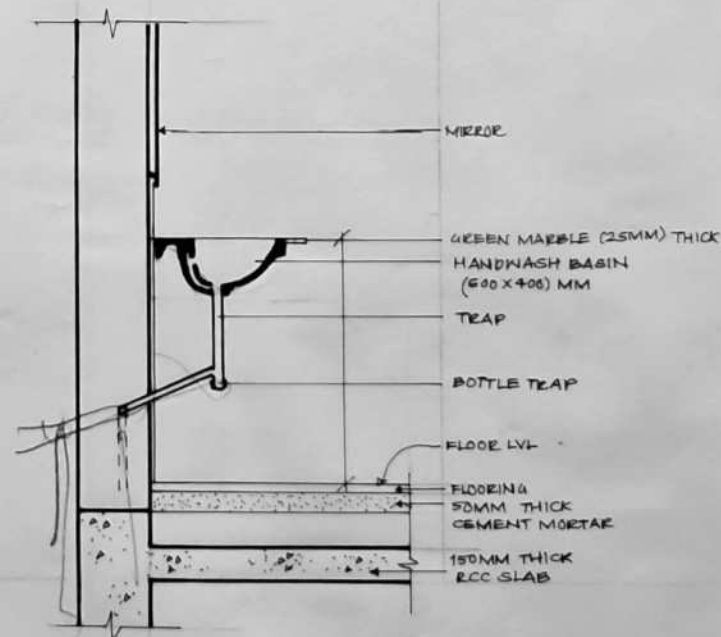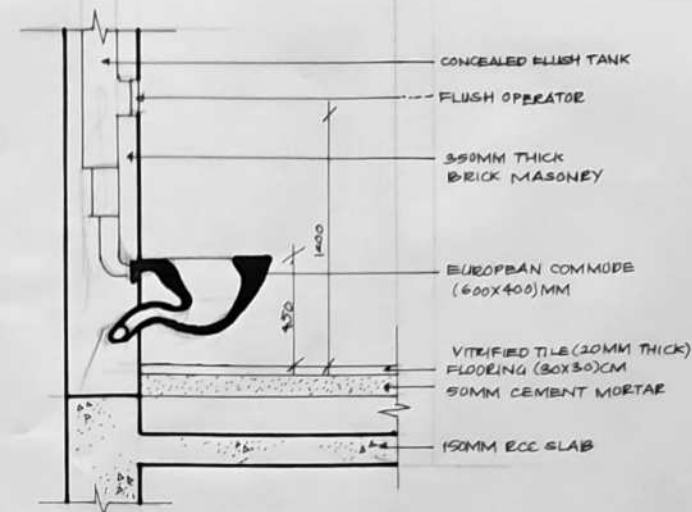

WASH-BASIN DETAIL

SCALE - 1:20

# TOILET DETAIL

WORKING DRAWING - 1

SHEET NO.

## NOTE-

1. ALL DIMENSIONS ARE IN MM UNIT UNTIL SPECIFIED.
2. DO NOT MEASURE DRAWING, FOLLOW WRITTEN DIMENSIONS ONLY.
3. PLEASE REFER TO THE ARCHITECT IN CONCERN TO ANY QUERY OF DRAWING.
4. THE DRAWING IS A PROPERTY OF THE ARCHITECT AND SHALL NOT BE USED OR REPRODUCED WITHOUT THEIR WRITTEN CONCENT.

| SCALE | DATE | DRAWN BY | CHECKED BY | REV NO. |
|-------|------|----------|------------|---------|
| 1:25  |      | YK       |            |         |

SUBJECT-

PROPOSED  
RESIDENCE AT  
HOMKAR NAGAR,  
SOLAPUR.




ARCHITECT-

NAME-VAISHNAVI GUNVANT KARBHARI.  
BATCH - 3RD YEAR [SEM - VI]  
COLLEGE NAME - GSEM'S COLLEGE  
OF ARCHITECTURE, SOLAPUR.  
ROLL NO. - SSSM/ 21/08


WORKING DRAWING FOR MR. RAUT



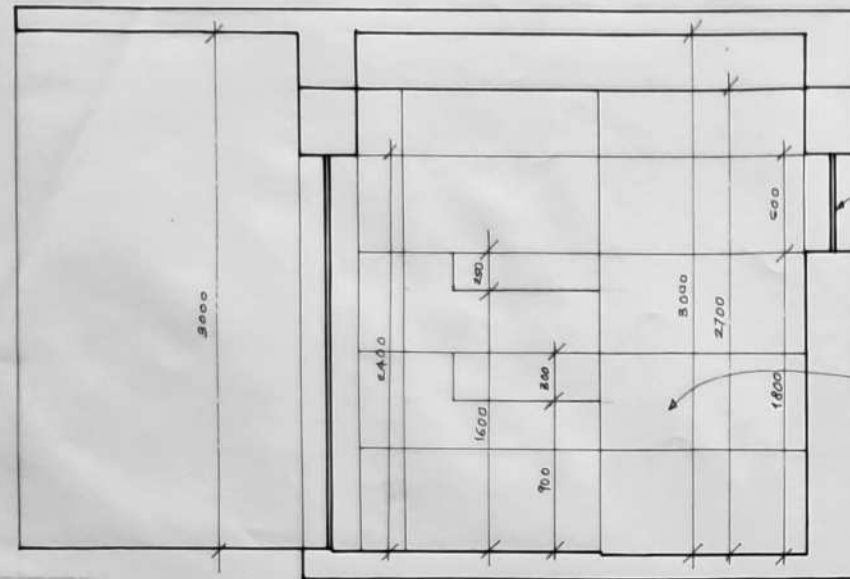


SECTION AA'

SCALE - 1:25

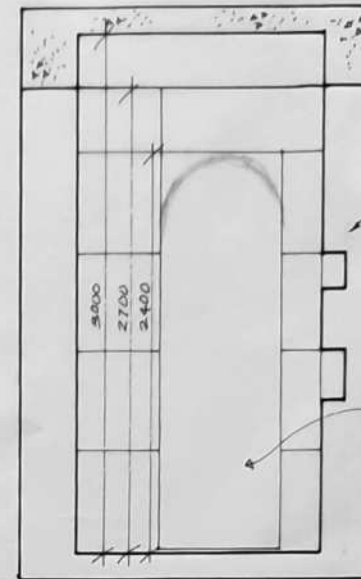


SECTION BB'

SCALE - 1:25

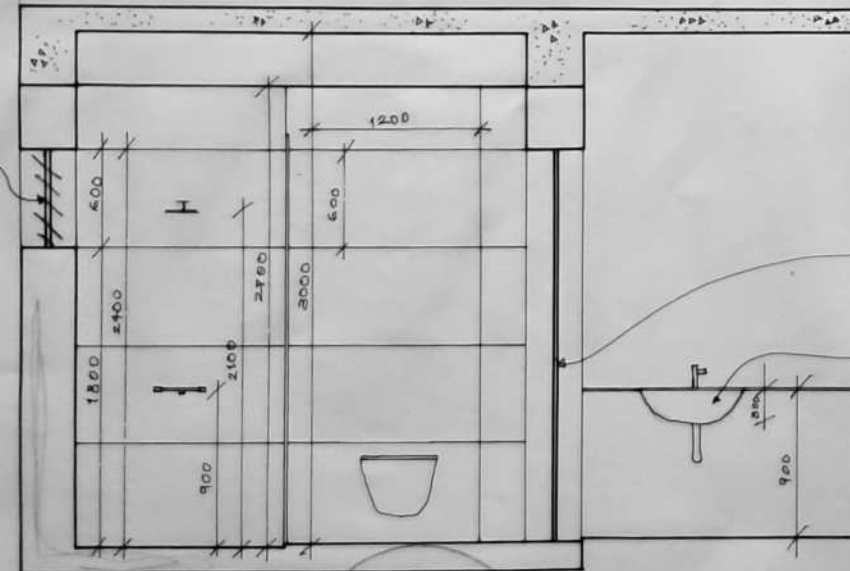

SECTION CC'

SCALE - 1:25

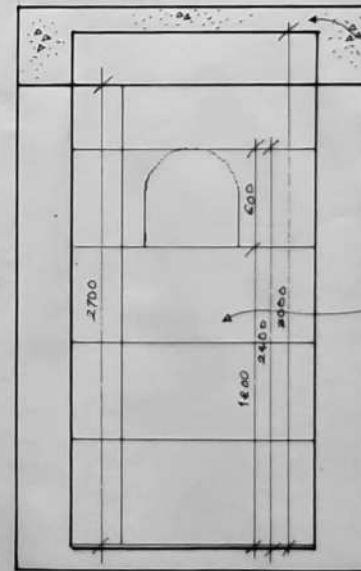

SECTION DD'

SCALE - 1:25

## TOILET DETAIL

WORKING DRAWING - I

SHEET NO.

### NOTE-

1. ALL DIMENSIONS ARE IN MM UNIT UNTIL SPECIFIED.
2. DO NOT MEASURE DRAWING, FOLLOW WRITTEN DIMENSIONS ONLY.
3. PLEASE REFER TO THE ARCHITECT IN CONCERN OF ANY QUERY.
4. THE DRAWING IS THE PROPERTY OF THE ARCHITECT AND SHALL NOT BE USED OR REPRODUCED WITHOUT THEIR WRITTEN CONCENT

| SCALE | DATE | DRAWN BY | CHECKED BY | REV NO. |
|-------|------|----------|------------|---------|
| 1:25  |      | VK       |            |         |

SUBJECT


**PROPOSED  
RESIDENCE AT  
HOMKAR NAGAR  
SOLAPUR.**

ARCHITECT -

NAME - VAISHNAVI GUNVANT KARBHARI.  
BATCH - 3RD YEAR [SEM - VI]  
COLLEGE NAME - SSSM'S COLLEGE  
OF ARCHITECTURE, SOLAPUR.  
ROLL NO. - SSM/21/08.

WORKING DRAWING FOR MR RAUT



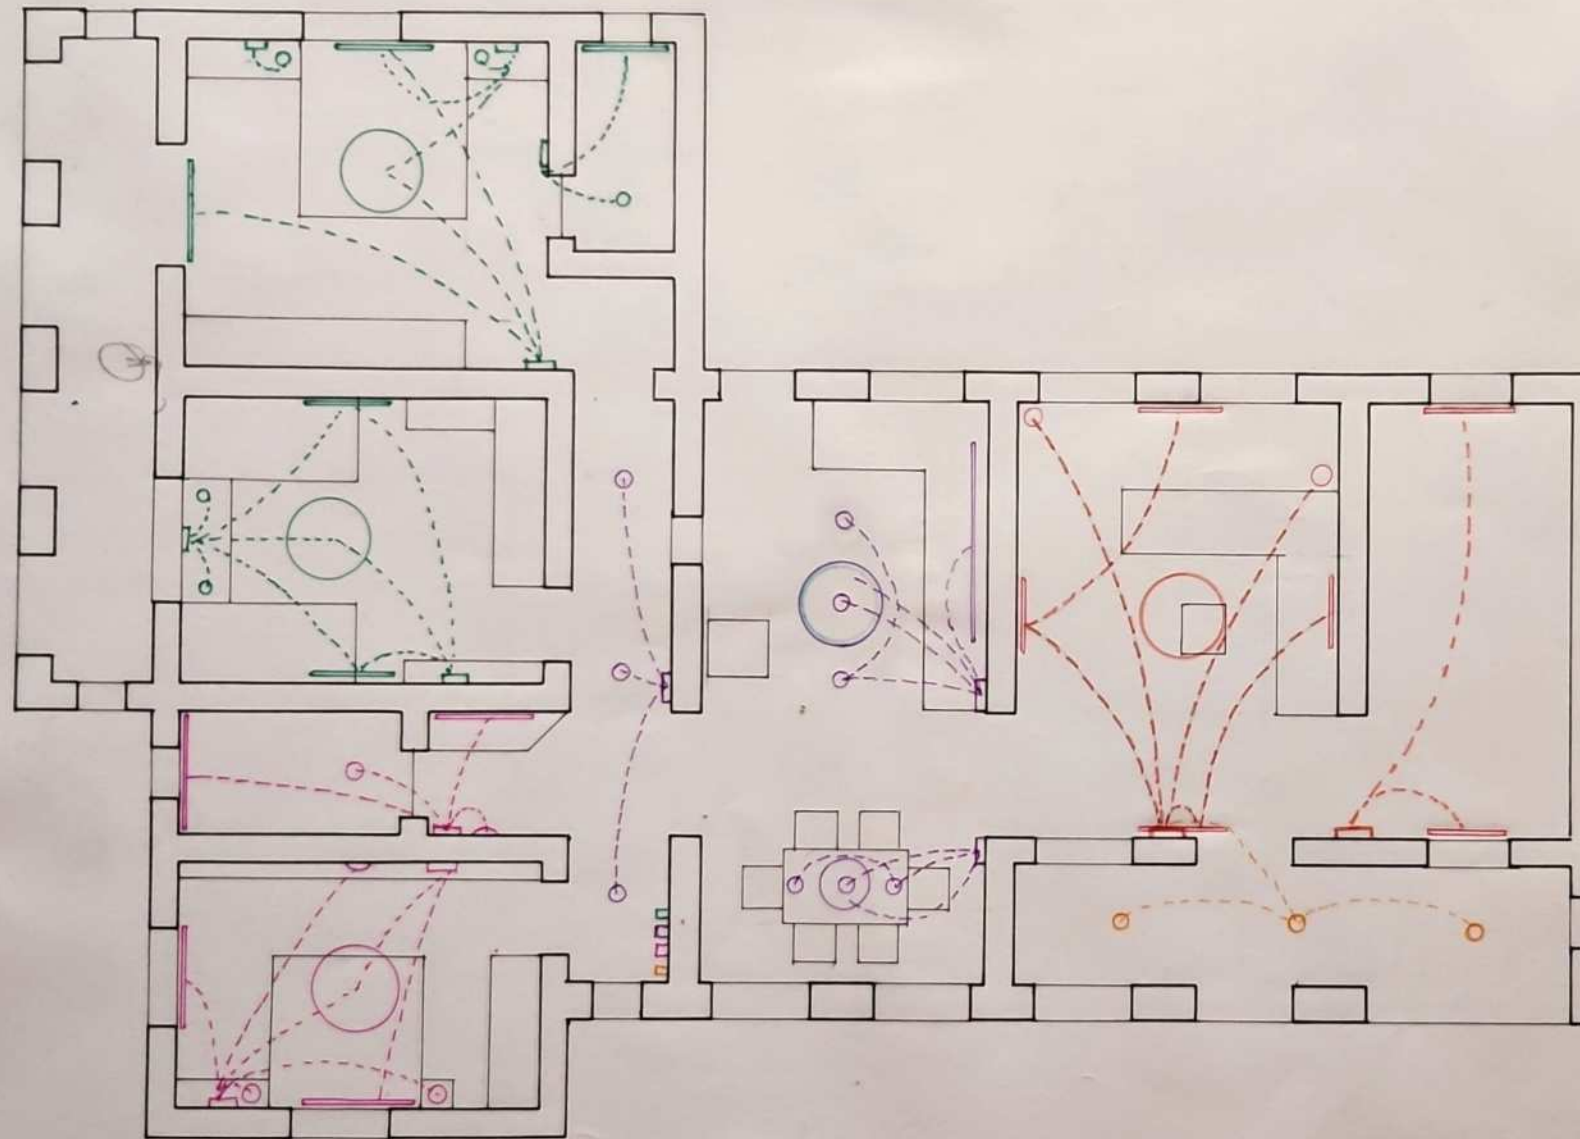

ELECTRICAL LAYOUT PLAN

SCALE - 1:50


WORKING DRAWING FOR MR RAUT

# ELECTRICAL LAYOUT

WORKING DRAWING - I SHEET NO. -

TUBELIGHT  
FLOOR LAMP  
WALL MOUNTED LAMP

ELECTRICAL - CONCEALED MODULAR

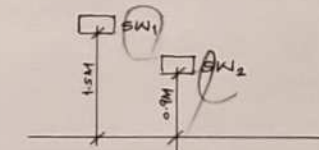

- NOTE -
1. ALL DIMENSIONS ARE IN MM UNIT UNTIL SPECIFIED.
  2. DO NOT MEASURE DRAWING, FOLLOW WRITTEN DIMENSIONS ONLY.
  3. PLEASE REFER TO THE ARCHITECT IN CONCERN OF ANY QUERY.
  4. THE DRAWING IS THE PROPERTY OF THE ARCHITECT AND SHALL NOT BE USED OR REPRODUCED WITHOUT THEIR WRITTEN CONCENT.

| SCALE | DATE | DRAWN BY | CHECKED BY | REVNO. |
|-------|------|----------|------------|--------|
| 1:50  |      | VK       |            |        |

SUBJECT -

**PROPOSED  
RESIDENCE AT  
HOMKAR NAGAR  
SOLAPUR.**

ARCHITECT -


NAME - VAISHNAVI GUNYANT KARBHARI.  
BATCH - 3RD YEAR [SEM-VI]  
COLLEGE NAME - SSSM'S COLLEGE  
OF ARCHITECTURE, SOLAPUR.  
ROLL NO. - SSM/21/08.





# SITE PLAN

WORKING DRAWING - I SHEET NO.

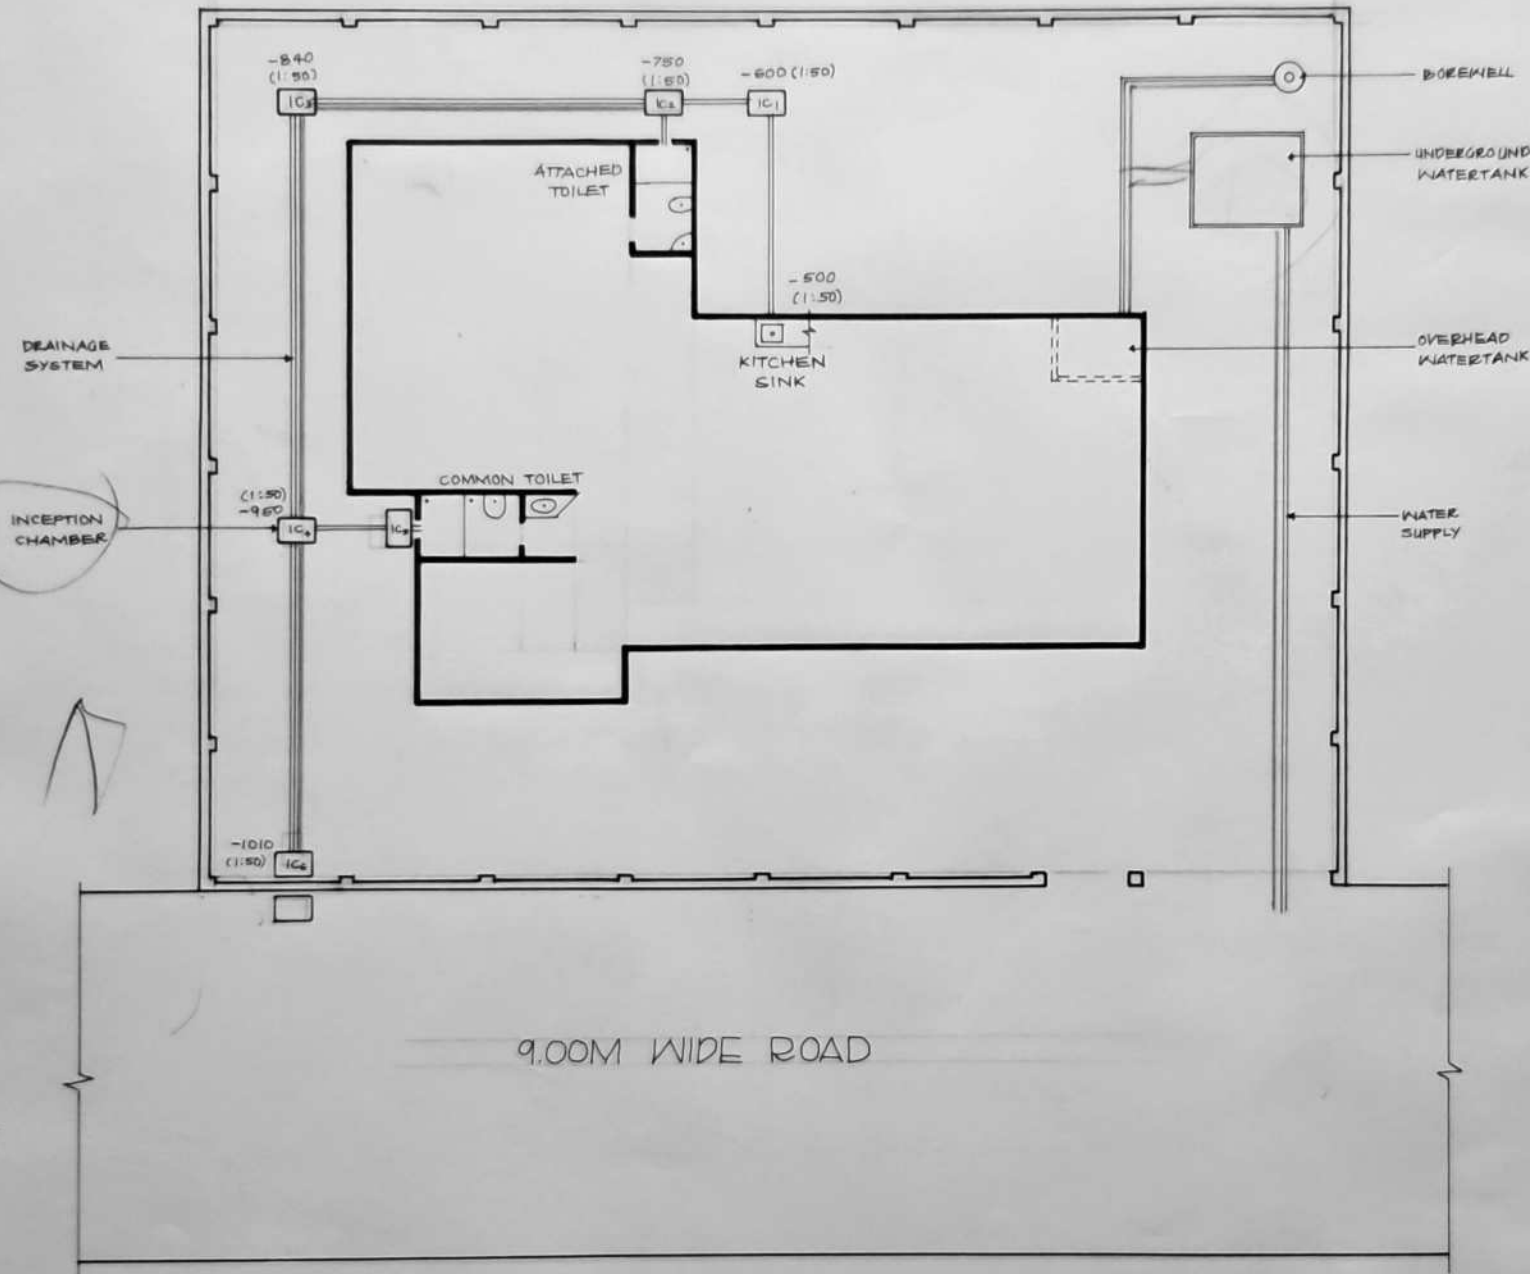

NOTE -  
 1. ALL DIMENSIONS ARE IN MM UNIT UNTIL SPECIFIED.  
 2. DO NOT MEASURE DRAWING, FOLLOW WRITTEN DIMENSIONS ONLY.  
 3. PLEASE REFER TO THE ARCHITECT IN CONCERN TO ANY QUERY OF DRAWING.  
 4. THE DRAWING IS A PROPERTY OF AN ARCHITECT AND SHALL NOT BE USED OR REPRODUCED WITHOUT THEIR WRITTEN CONCENT

| SCALE | DATE | DRAWN BY | CHECKED BY | REV NO. |
|-------|------|----------|------------|---------|
| 1:100 |      | YK       |            |         |

SUBJECT-

PROPOSED  
 RESIDENCE AT  
 HOMKAR NAGAR,  
 SOLAPUR.

N

ARCHITECT -


NAME-VAISHNAVI GUNVANT KARBHARI.  
 BATCH - 3RD YEAR [SEM-VI]  
 COLLEGE NAME - SSSM'S COLLEGE  
 OF ARCHITECTURE, SOLAPUR.  
 ROLL NO. - SSM/21/08.

WORKING DRAWING FOR MR. RAUT



# SITE PLAN

WORKING DRAWING-1 SHEET NO.

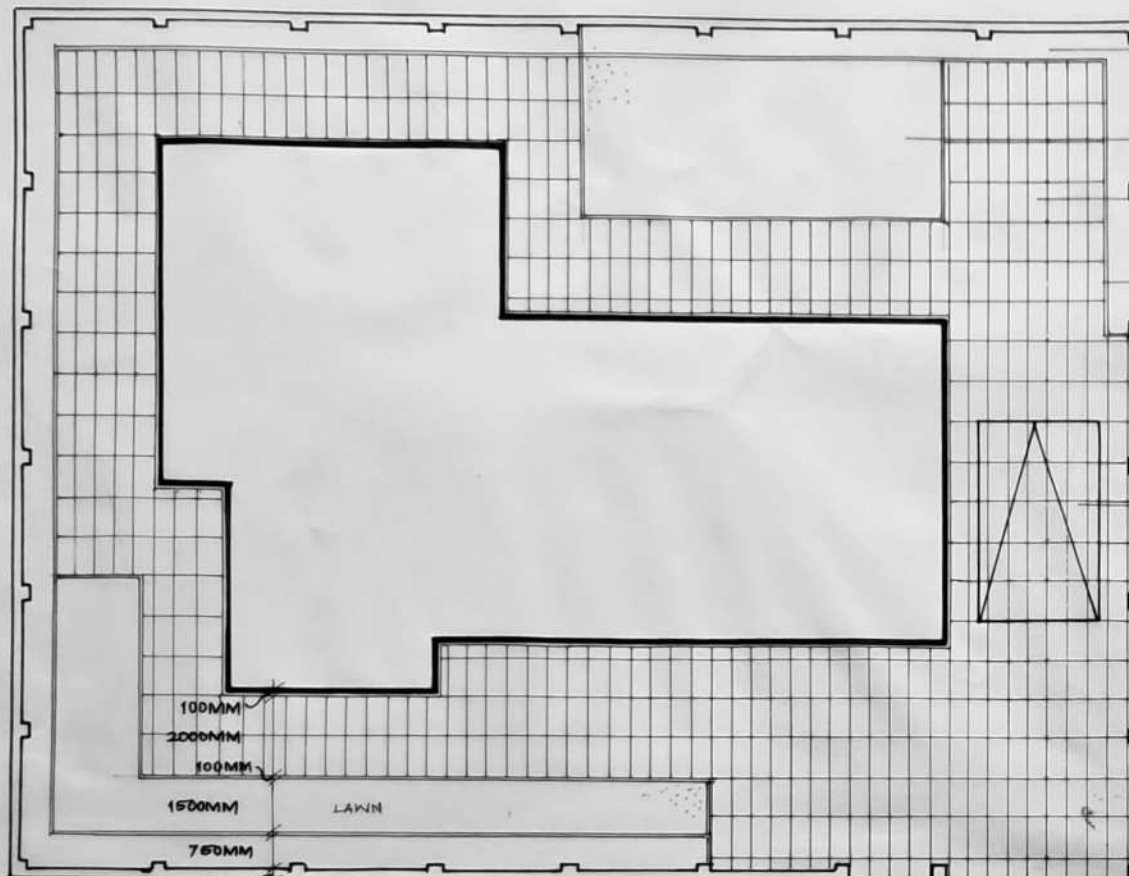

FLOWER BED  
(750MM WIDTH)

LAWN  
(SCUCH GRASS)

PAVER  
ON SITE CONSTRUCTED  
CONCRETE LINING

100MM THICK CURB

830MM THICK  
BRICK SUPPORT

280MM THICK  
BRICK MASONRY

4-WHEELER  
PARKING

NOTE -

1. ALL DIMENSIONS ARE IN MM UNIT UNTIL SPECIFIED.
2. DO NOT MEASURE DRAWING, FOLLOW WRITTEN DIMENSIONS ONLY.
3. PLEASE REFER TO THE ARCHITECT IN CONCERN OF ANY QUERY.
4. THE DRAWING IS THE PROPERTY OF THE ARCHITECT AND SHALL NOT BE USED FOR REPRODUCED WITHOUT THEIR WRITTEN CONCENT.

| SCALE | DATE | DRAWN BY | CHECKED BY | REV NO. |
|-------|------|----------|------------|---------|
| 1:100 |      | VK       |            |         |


SUBJECT -

**PROPOSED  
RESIDENCE AT  
HOMKAR NAGAR  
SOLAPUR**



ARCHITECT -

NAME - VAISHNAVI GUNVANT KARBHARI.  
BATCH - 3RD YEAR [SEM-VI]  
COLLEGE NAME - SSSM'S COLLEGE  
OF ARCHITECTURE, SOLAPUR.  
ROLL NO. - 65M/21/08.

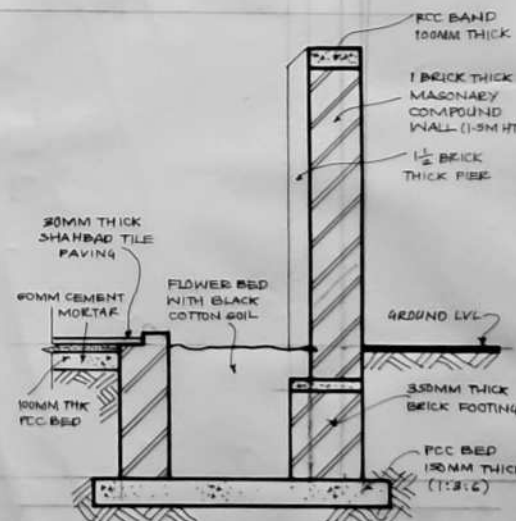


COMPOUND WALL DETAIL  
SCALE - 1:20

SITE PLAN  
SCALE - 1:100

WORKING DRAWING FOR MR RAUT



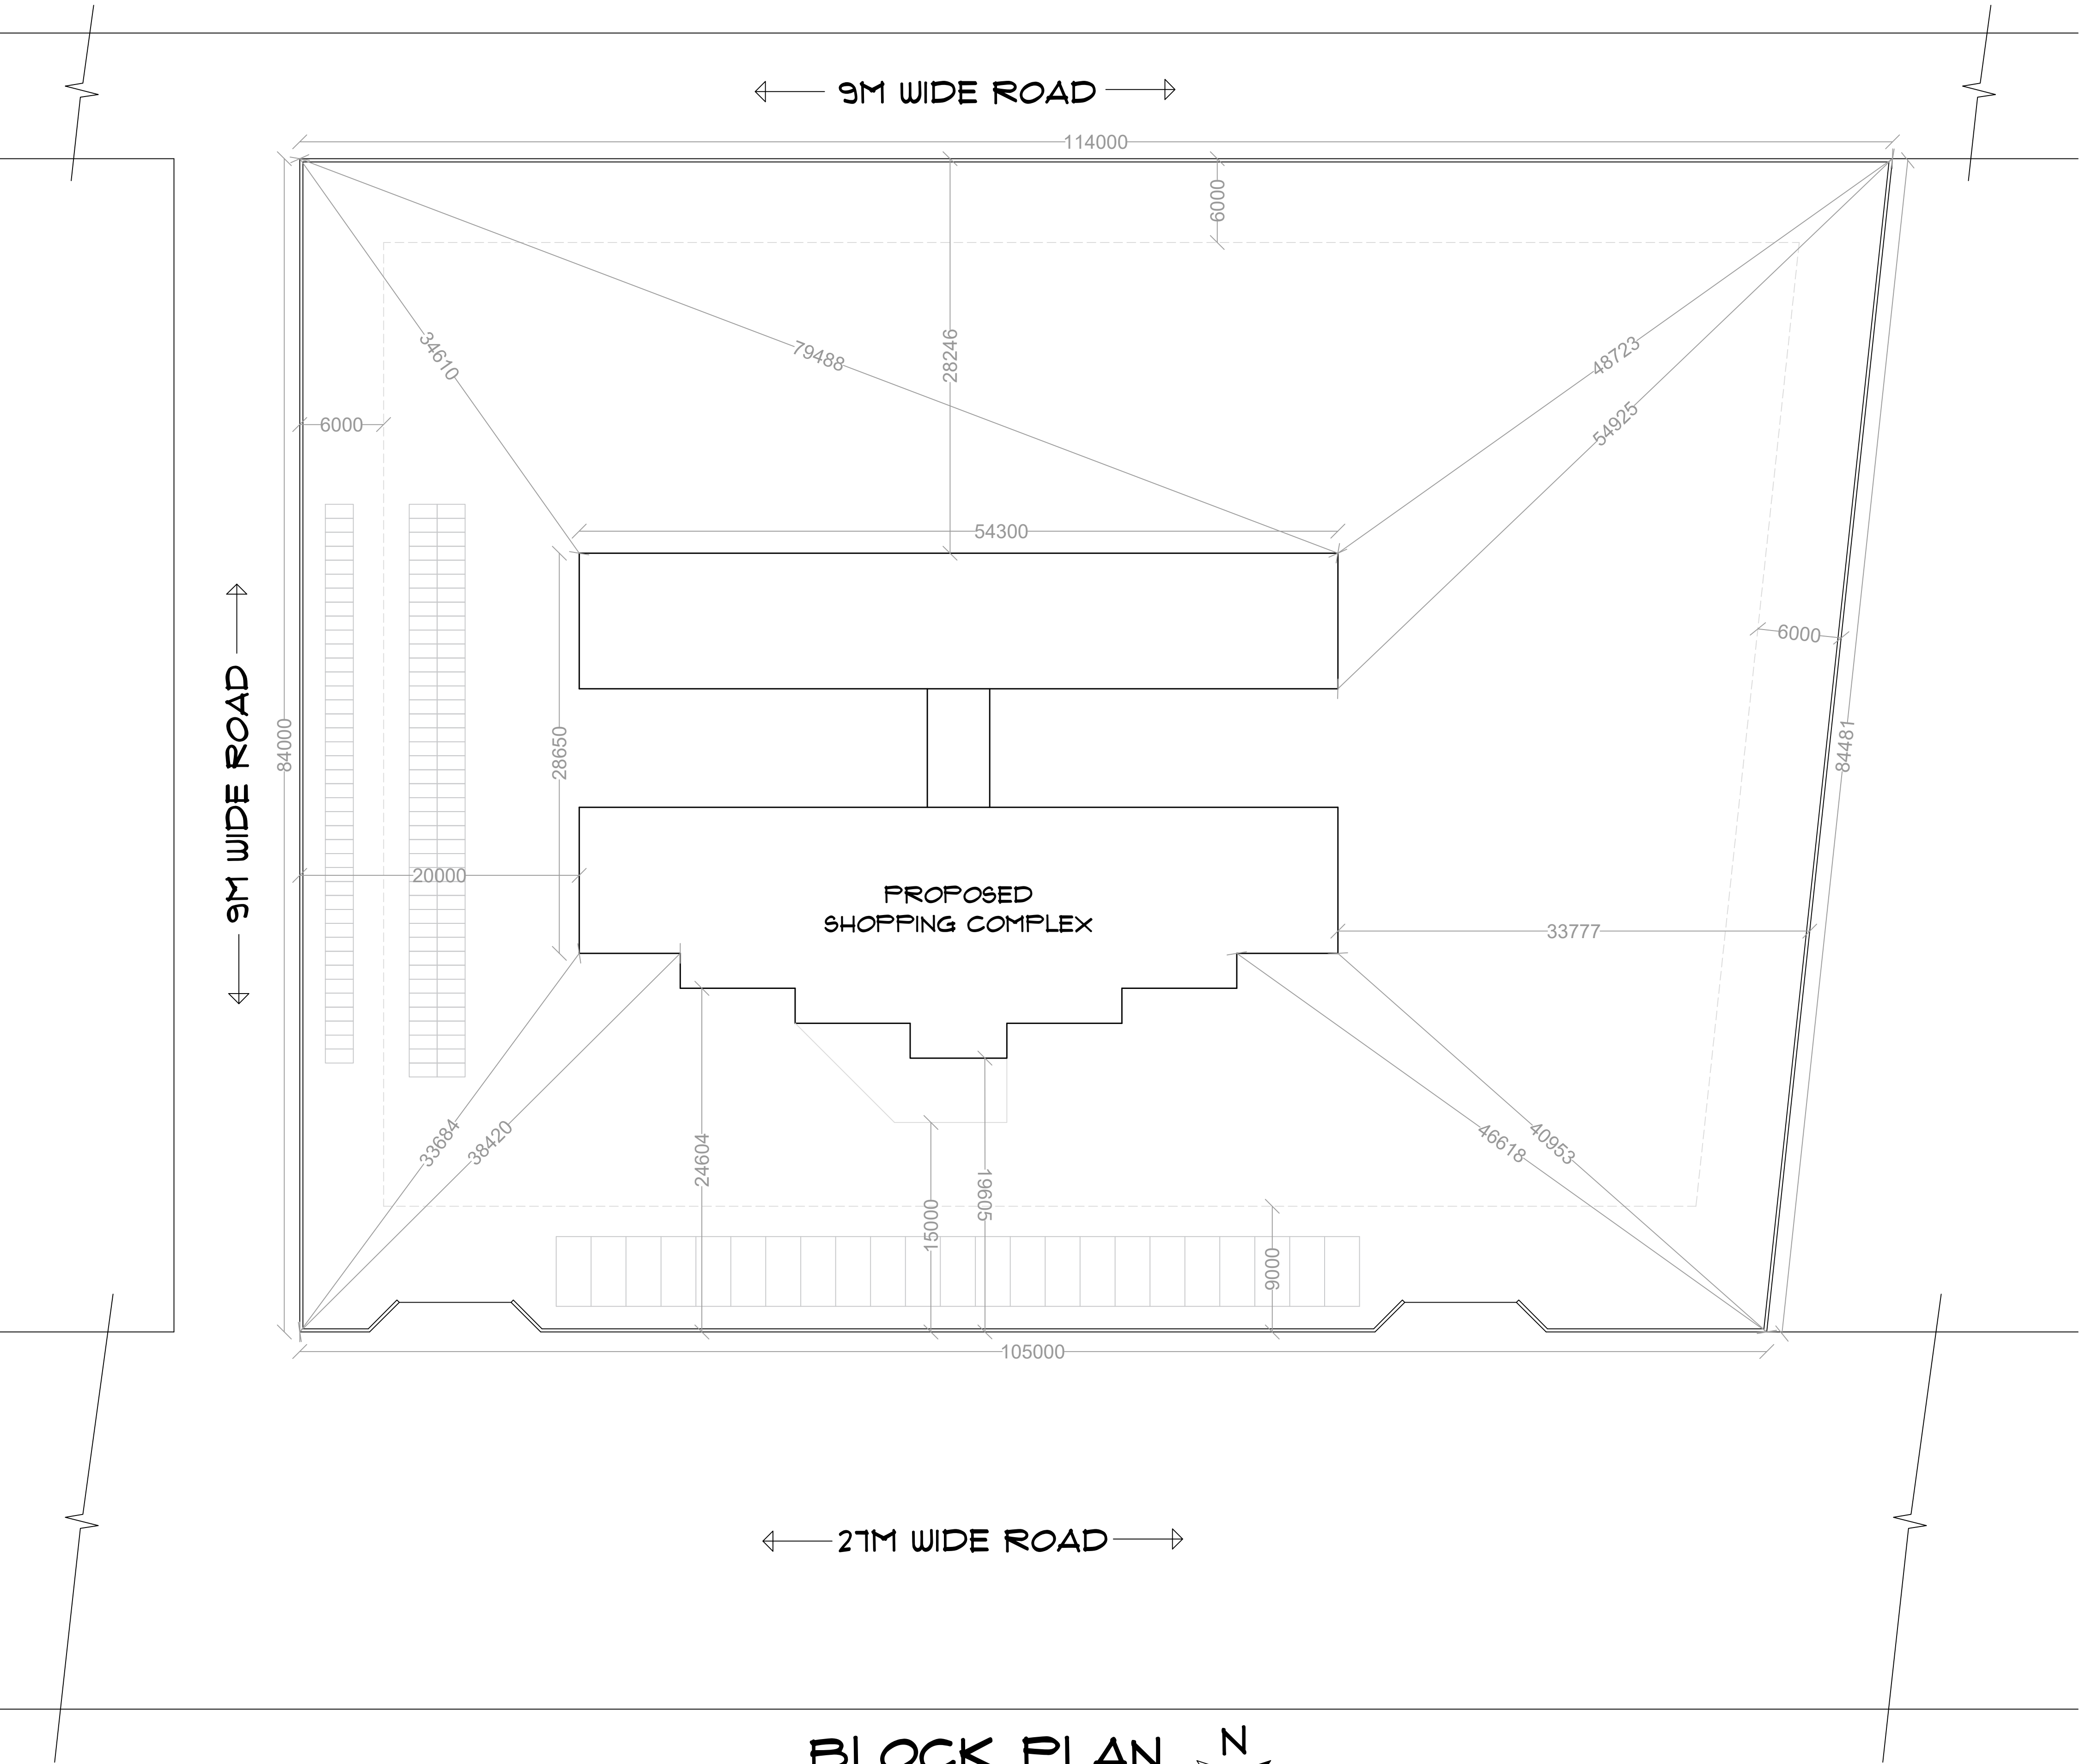

**BLOCK PLAN**  
SCALE - 1:250

PROFORMA -

WORKING DRAWING - II

SHEET TITLE -

SITE DEMARKATION

B

C

E

A

D

AREA OF PROPOSED SITE  
= 10089 SQ.M

PROPOSED SITE  
SCALE - 1:1000

AREA OF PROPOSED SITE =  
( BY RECTANGLE AND TRIANGULATION METHOD)  
AREA OF □ ABCD + AREA OF △ CDE =  
= (SIDE AB X SIDE AD) + (0.5 X CD X CE)  
= (114X84) + (0.5X114X9)  
= 9576 + 513  
= 10089 SQ.M

NOTES -

1) ALL DIMENSIONS ARE IN MM UNTIL SPECIFIED.

2) DO NOT MEASURE DRAWING, FOLLOW WRITTEN DIMENSIONS ONLY.

3) PLEASE REFER TO THE ARCHITECT IN CONCERN TO ANY QUERY OR DRAWING.

4) THIS DRAWING IS A PROPERTY OF THE ARCHITECT AND SHALL NOT BE REPRODUCED OR USED WITHOUT THEIR WRITTEN PERMISSION.

|            |              |              |
|------------|--------------|--------------|
| SCALE -    | DATE -       | REV NO. -    |
| 1 : 500    | 10/10/2024   |              |
| DRAWN BY - | CHECKED BY - | <div>N</div> |
| YK         | AR NS        |              |


PROJECT -

PROPOSED SHOPPING COMPLEX AT SOLAPUR


ARCHITECT -

VAISHNAVI G. KARBHARI.  
ROLL NO. - 99M/21/08  
4TH YR, SEM VII (B.ARCH)  
99M'S COLLEGE OF ARCHITECTURE, SOLAPUR.

SIGN AND STAMP -

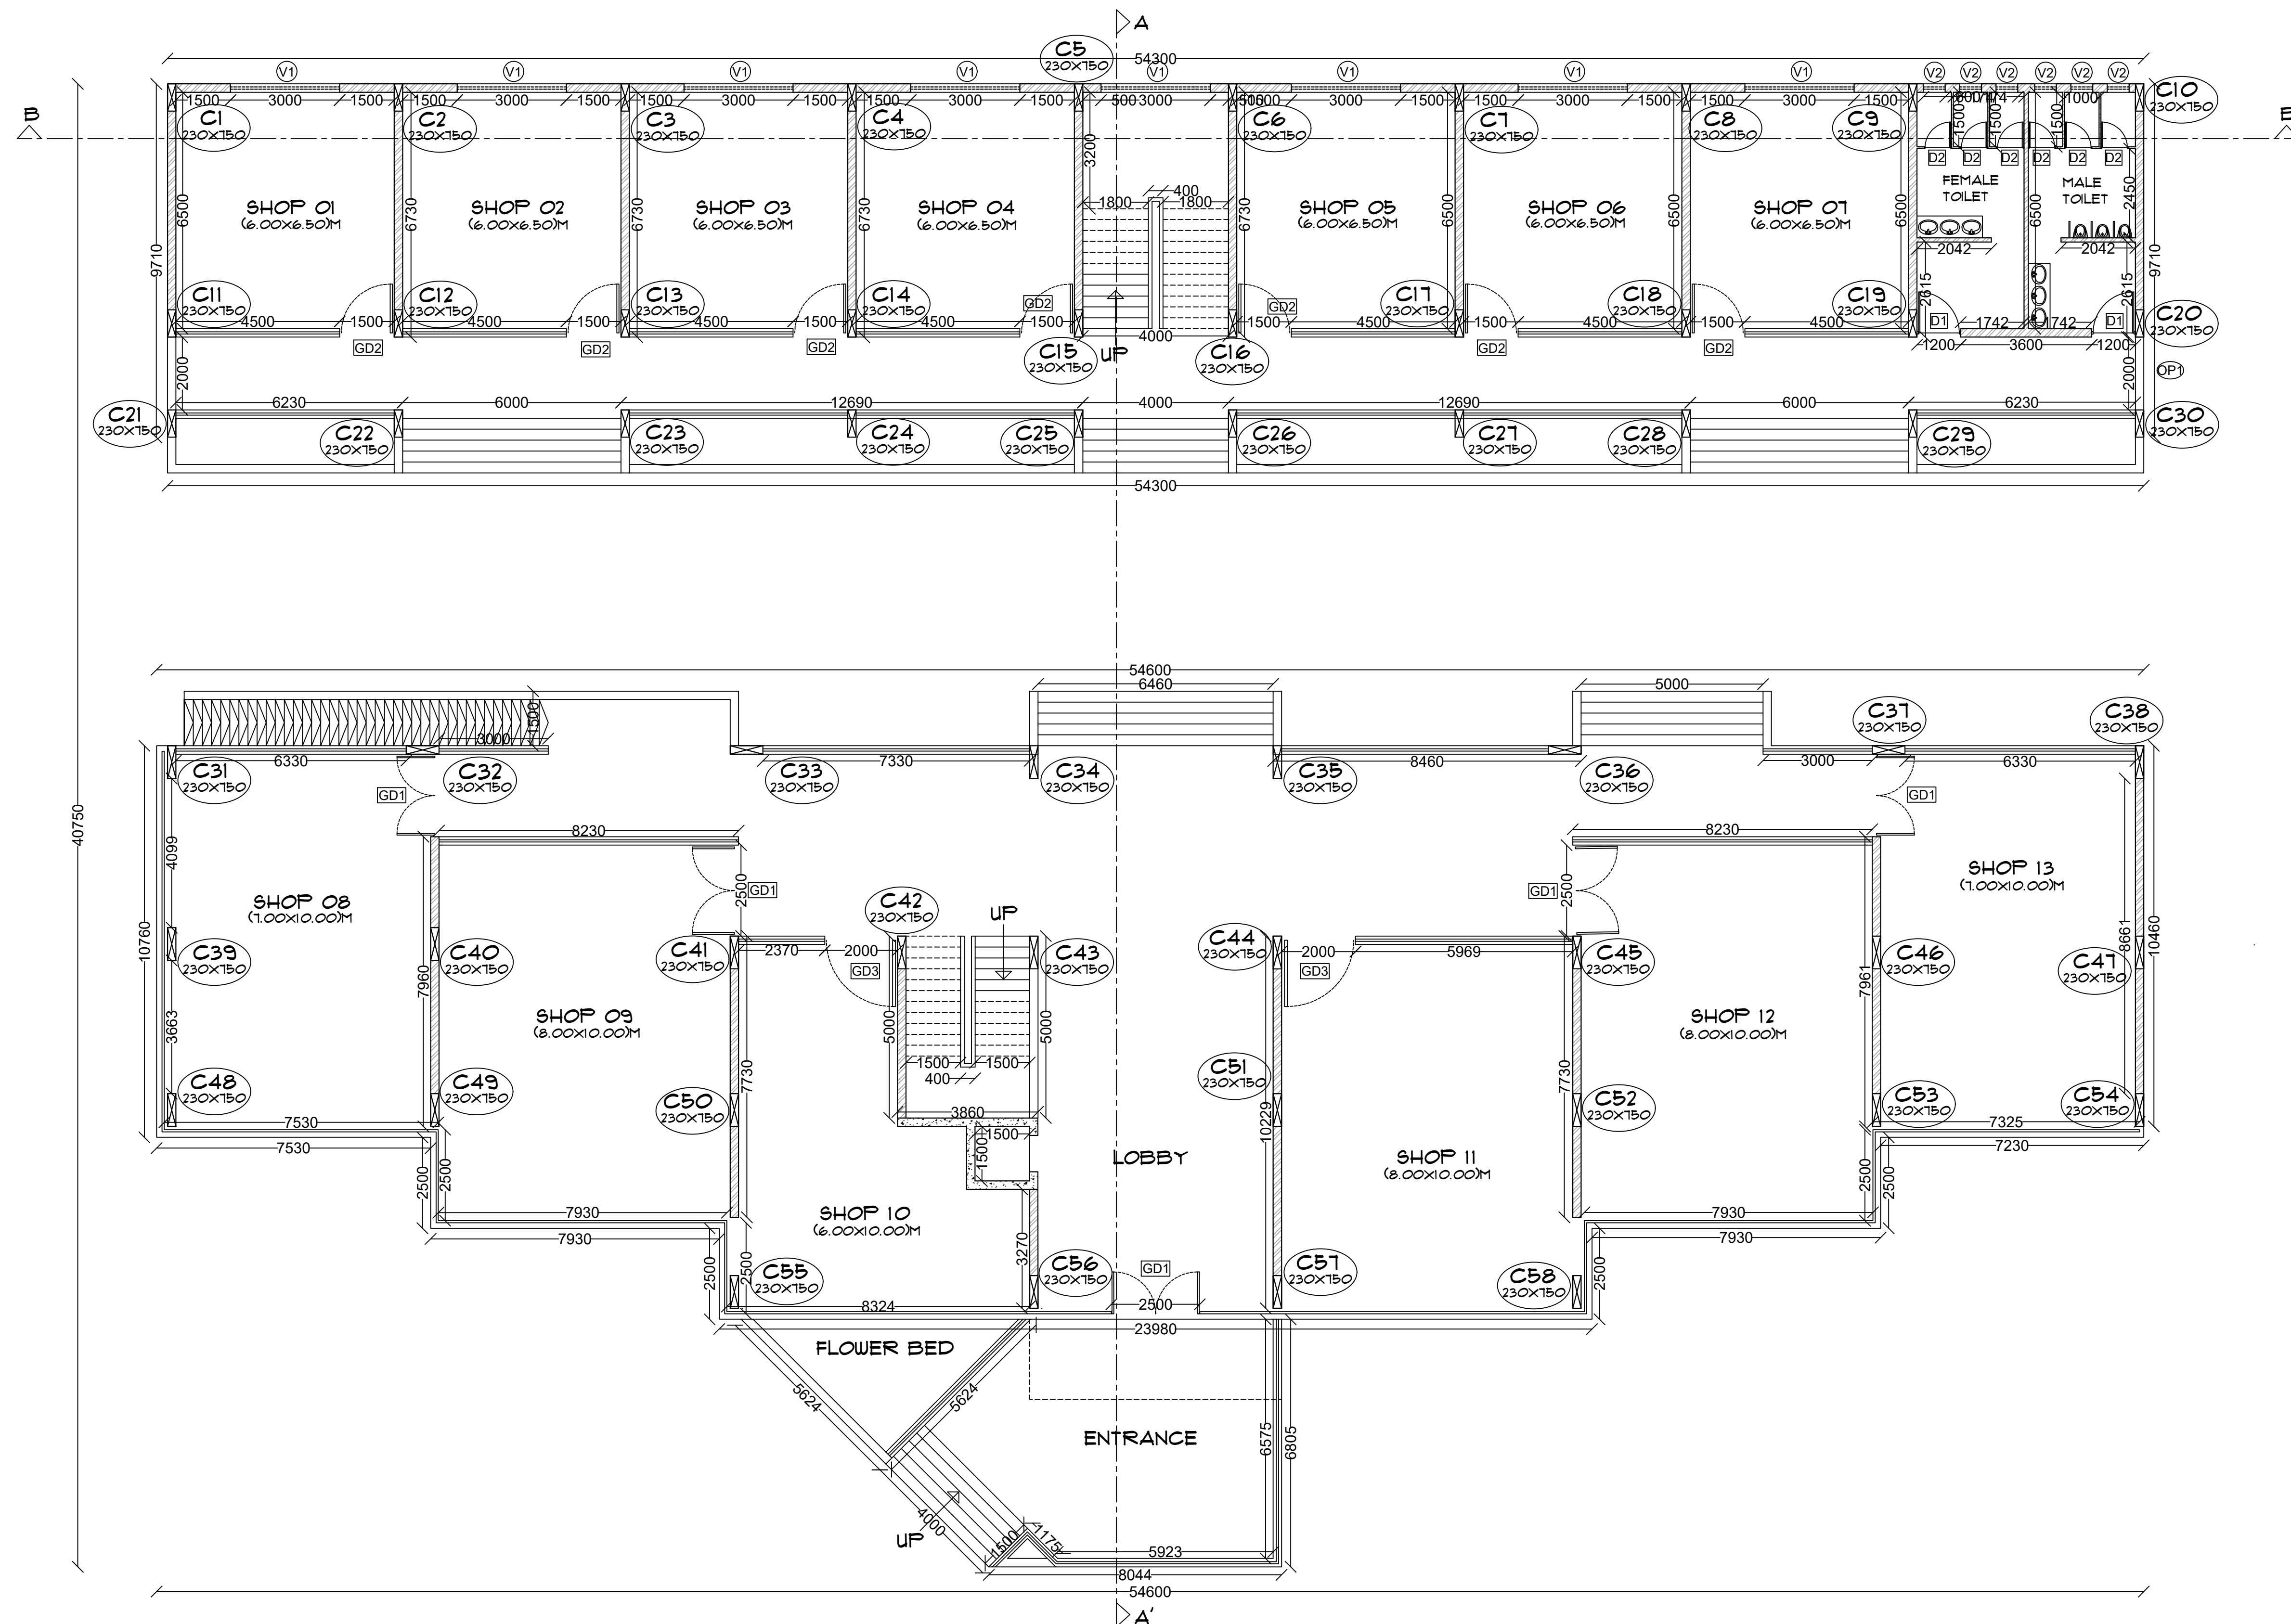

GROUND FOOR PLAN  
SCALE - 1:100

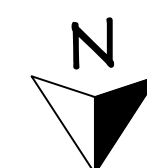

PROFORMA -

WORKING DRAWING - II

SHEET TITLE -

GROUND FLOOR PLAN

OPENING SCHEDULE :

| OPENING      | INDICATION | SIZE        |
|--------------|------------|-------------|
| VENTILATOR 1 | (V1)       | (3.0X0.8)M  |
| VENTILATOR 2 | (V2)       | (0.6X0.6)M  |
| GLASS DOOR 1 | (GD1)      | (2.5X2.1)M  |
| GLASS DOOR 2 | (GD2)      | (1.5X2.5)M  |
| GLASS DOOR 3 | (GD3)      | (2.0X2.1)M  |
| DOOR 1       | (D1)       | (1.2X2.5)M  |
| DOOR 2       | (D2)       | (0.15X2.1)M |
| DOOR 3       | (D3)       | (0.9X2.4)M  |
| OPENING      | (OP1)      | (0.2X2.1)M  |

NOTES -

- 1) ALL DIMENSIONS ARE IN MM UNTIL SPECIFIED.
- 2) DO NOT MEASURE DRAWING, FOLLOW WRITTEN DIMENSIONS ONLY.
- 3) PLEASE REFER TO THE ARCHITECT IN CONCERN TO ANY QUERY OR DRAWING.
- 4) THIS DRAWING IS A PROPERTY OF THE ARCHITECT AND SHALL NOT BE REPRODUCED OR USED WITHOUT THEIR WRITTEN PERMISSION.

| SCALE -    | DATE -       | REV NO. - |
|------------|--------------|-----------|
| 1 : 100    | 10/10/2024   |           |
| DRAWN BY - | CHECKED BY - |           |
| VK         | AR NS        |           |

PROJECT -

PROPOSED  
SHOPPING COMPLEX  
AT SOLAPUR

ARCHITECT -

VAISHNAVI G. KARBHARI.  
ROLL NO. - 99M/21/08  
4TH YR, SEM VII (B.ARCH)  
999M'S COLLEGE OF  
ARCHITECTURE, SOLAPUR.

SIGN AND STAMP -

PROFORMA -

WORKING DRAWING - II

SHEET TITLE -

FIRST FLOOR PLAN

OPENING SCHEDULE :

| OPENING      | INDICATION | SIZE        |
|--------------|------------|-------------|
| VENTILATOR 1 | Ⓥ1         | (3.0X0.8)M  |
| VENTILATOR 2 | Ⓥ2         | (0.6X0.6)M  |
| GLASS DOOR 1 | ⓖD1        | (2.5X2.1)M  |
| GLASS DOOR 2 | ⓖD2        | (1.5X2.5)M  |
| GLASS DOOR 3 | ⓖD3        | (2.0X2.1)M  |
| DOOR 1       | ⓓ1         | (1.2X2.5)M  |
| DOOR 2       | ⓓ2         | (0.15X2.1)M |
| DOOR 3       | ⓓ3         | (0.9X2.4)M  |
| OPENING      | ⓐP1        | (0.2X2.1)M  |

NOTES -


- 1) ALL DIMENSIONS ARE IN MM UNTIL SPECIFIED.
- 2) DO NOT MEASURE DRAWING, FOLLOW WRITTEN DIMENSIONS ONLY.
- 3) PLEASE REFER TO THE ARCHITECT IN CONCERN TO ANY QUERY OR DRAWING.
- 4) THIS DRAWING IS A PROPERTY OF THE ARCHITECT AND SHALL NOT BE REPRODUCED OR USED WITHOUT THEIR WRITTEN PERMISSION.

SCALE - DATE - REV NO. -

1 : 100 10/10/2024

DRAWN BY - CHECKED BY -

YK AR NS

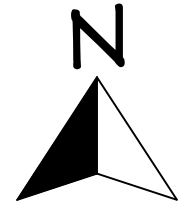


PROJECT -

PROPOSED  
SHOPPING COMPLEX  
AT SOLAPUR

ARCHITECT -

VAISHNAVI G. KARBHARI.  
ROLL NO. - 99M/21/08  
4TH YR, SEM VII (B.ARCH)  
999M'S COLLEGE OF  
ARCHITECTURE, SOLAPUR.



SIGN AND STAMP -

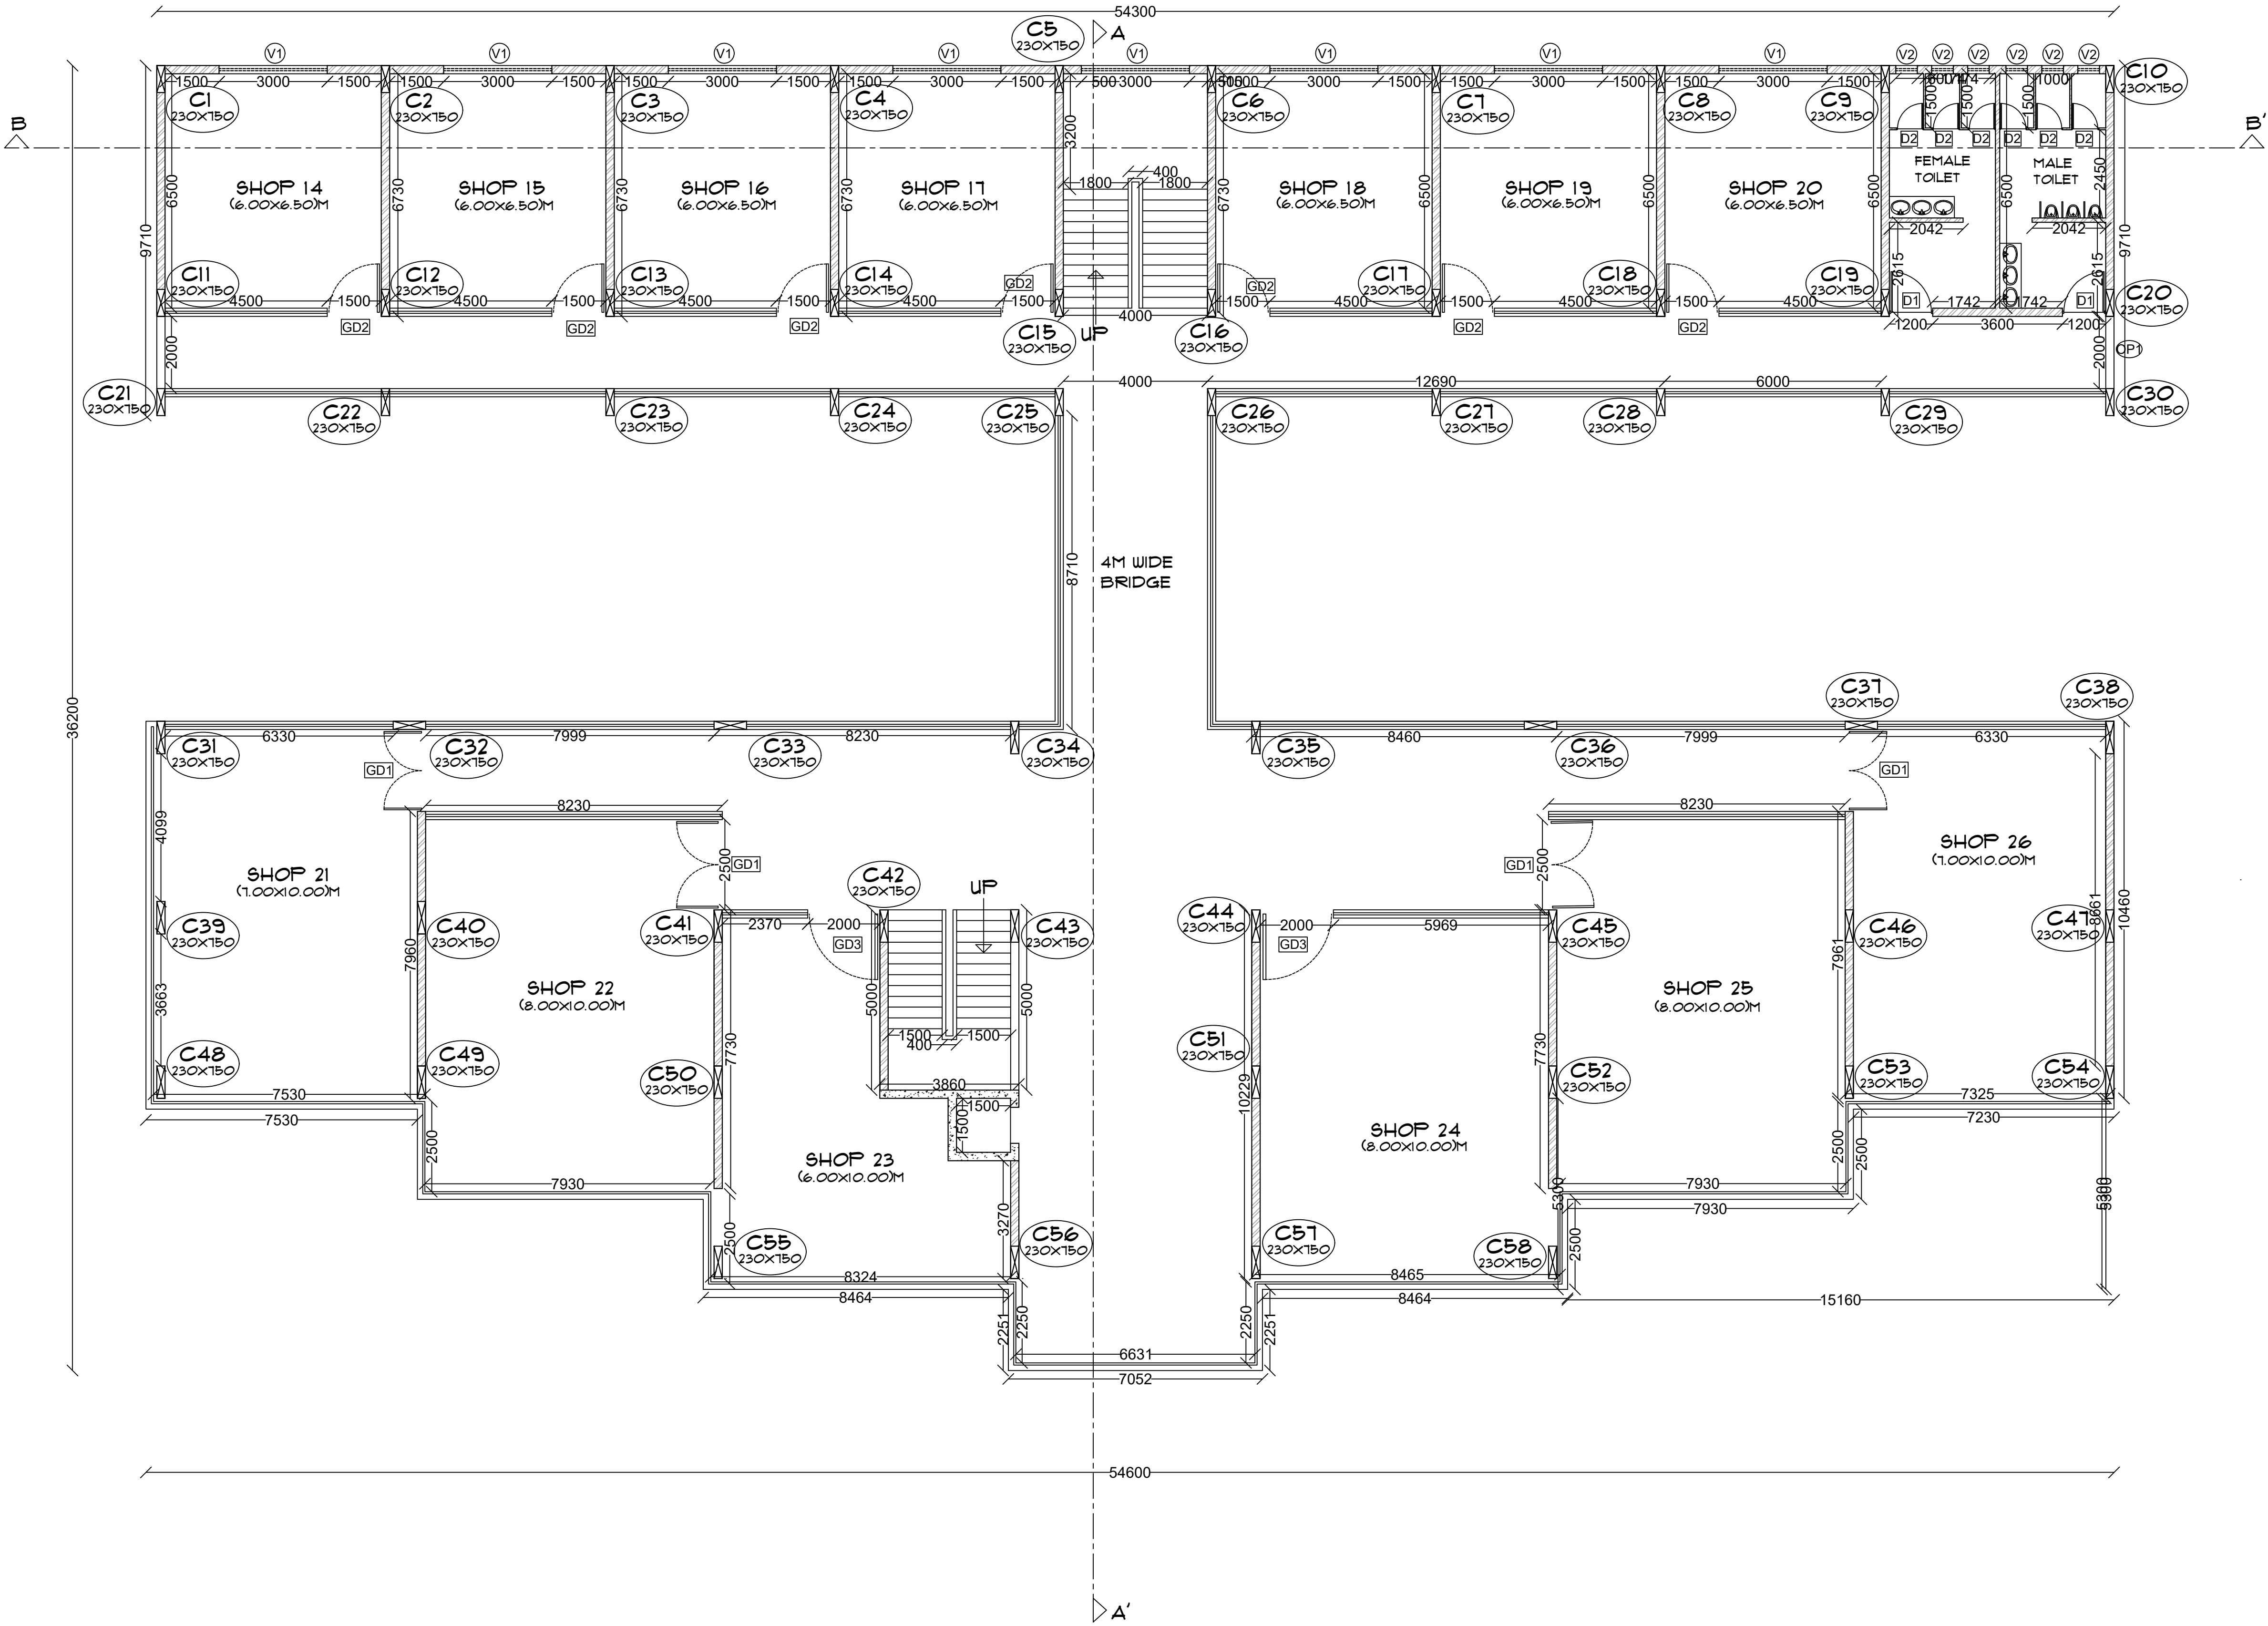


FIRST FOOR PLAN

SCALE - 1:100



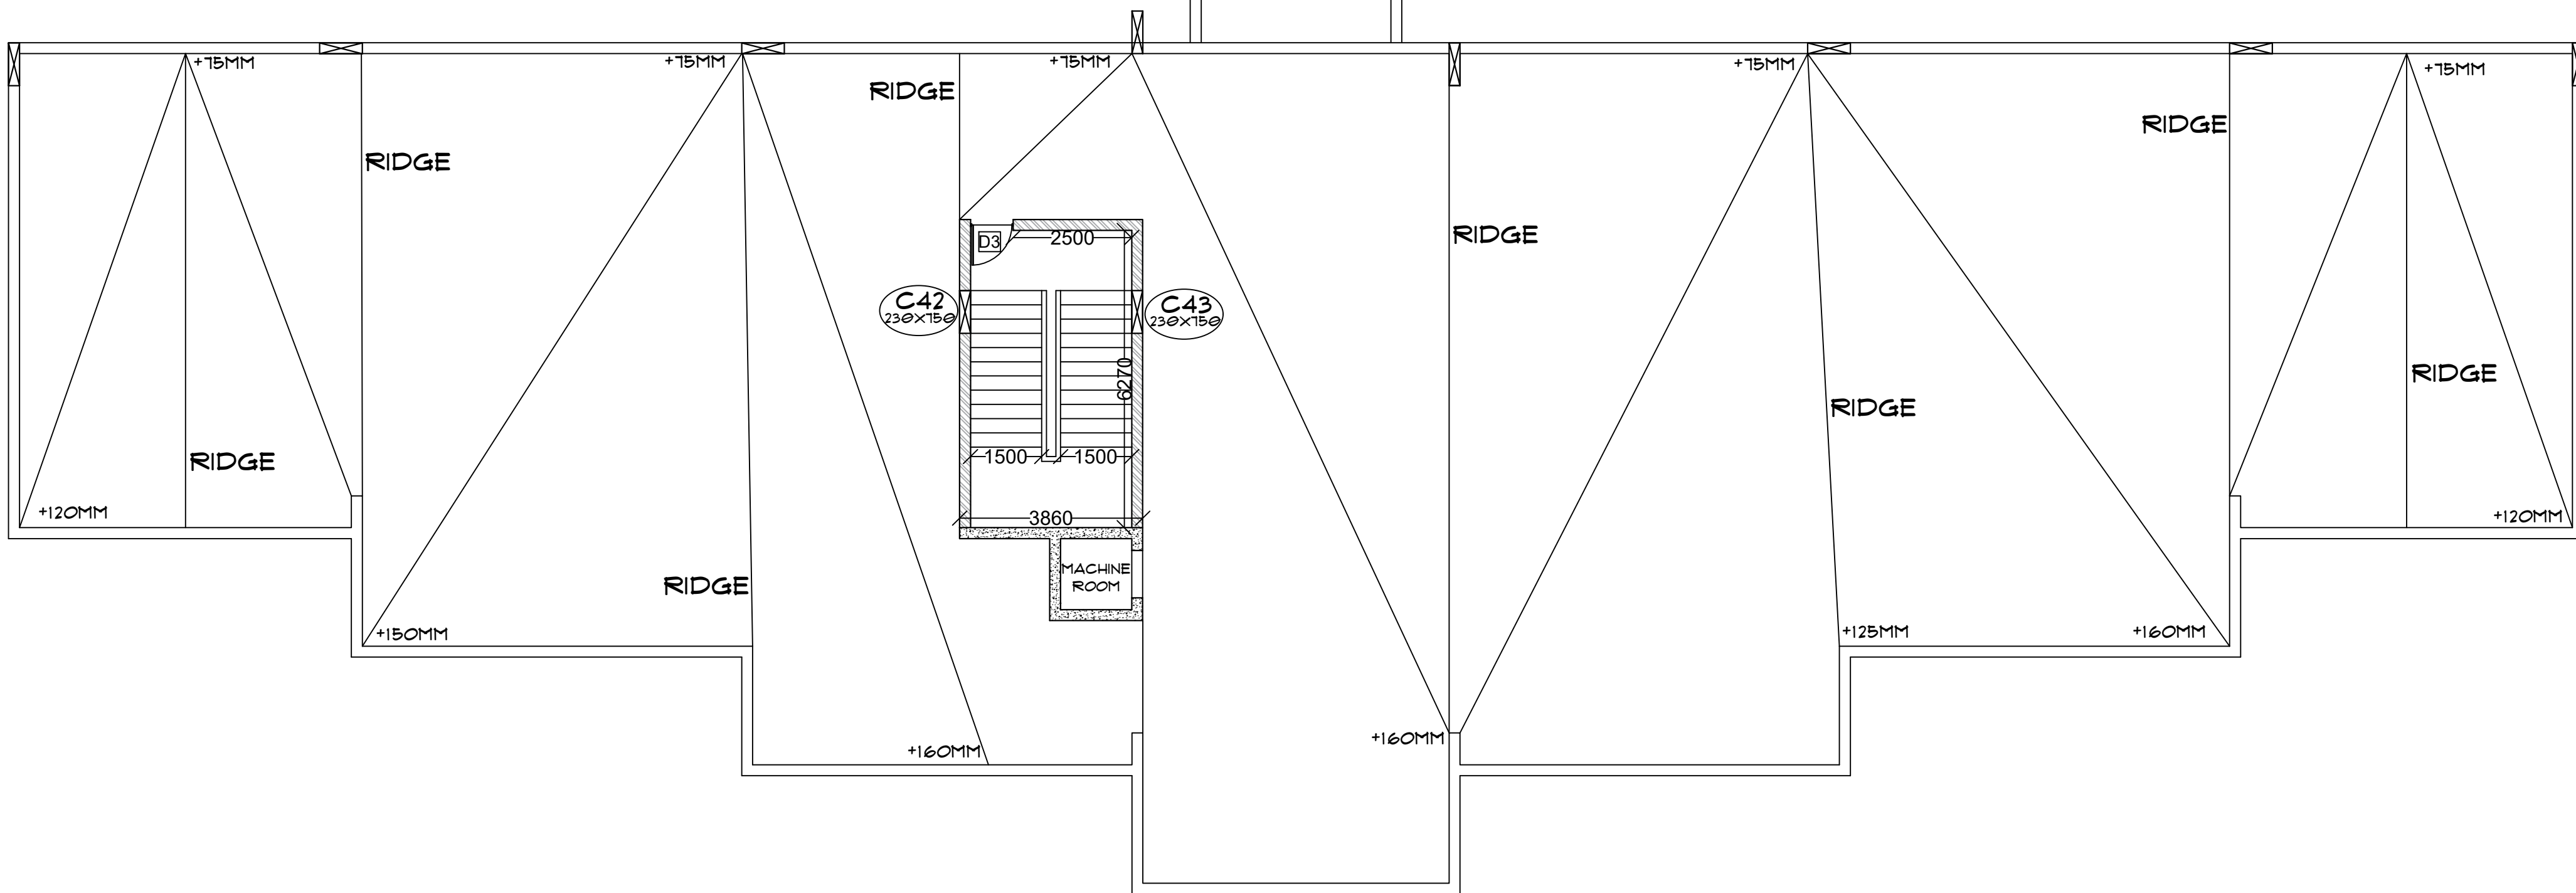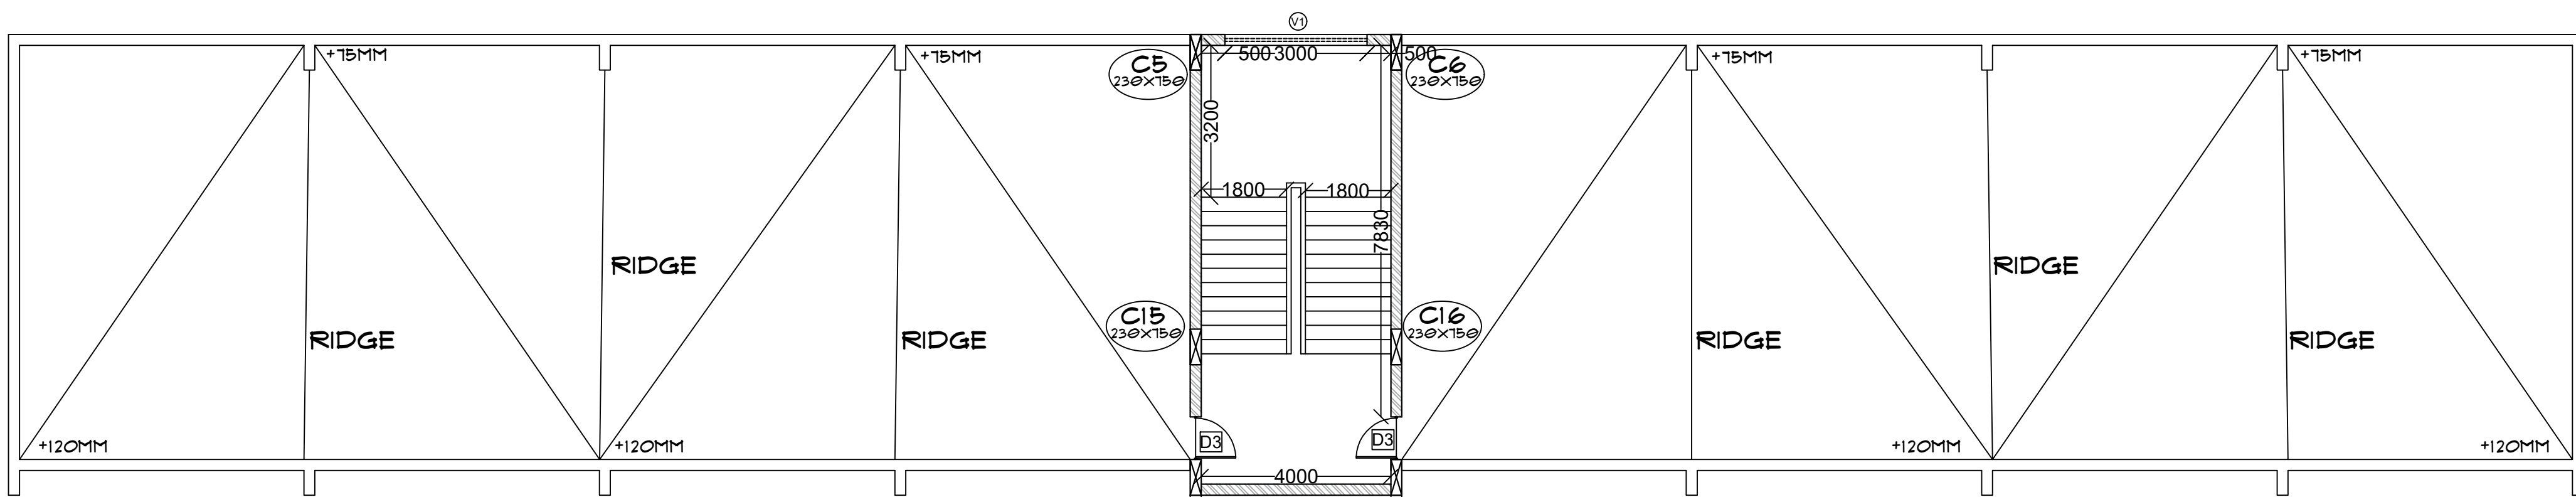

**TERRACE FOOR PLAN**  
SCALE - 1:100

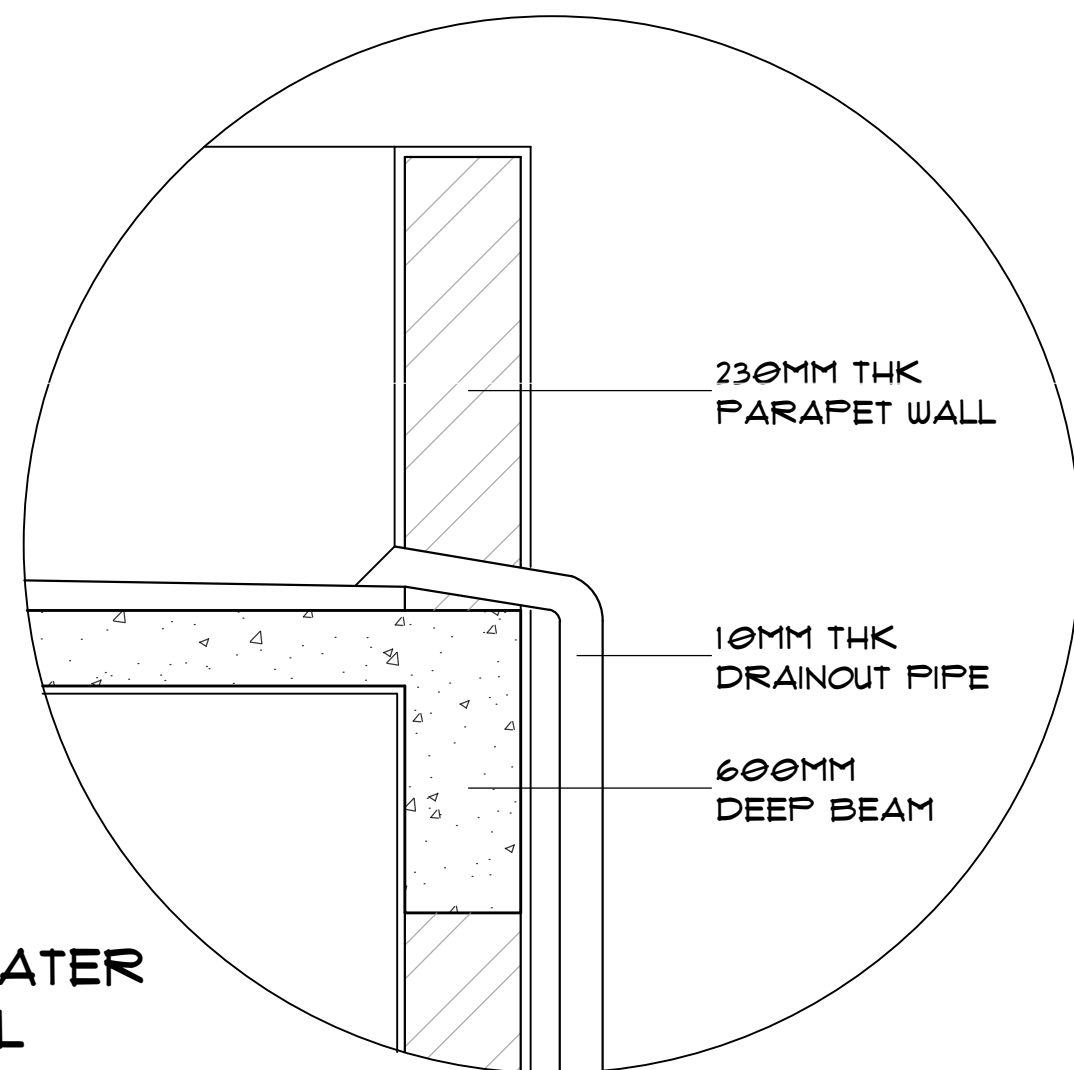

**TERRACE RAINWATER  
DRAINOUT DETAIL**  
SCALE - 1:15

PROFORMA -

WORKING DRAWING - II

SHEET TITLE -

**TERRACE FLOOR PLAN**

**NOTES -**


- 1) ALL DIMENSIONS ARE IN MM UNTIL SPECIFIED.
- 2) DO NOT MEASURE DRAWING, FOLLOW WRITTEN DIMENSIONS ONLY.
- 3) PLEASE REFER TO THE ARCHITECT IN CONCERN TO ANY QUERY OR DRAWING.
- 4) THIS DRAWING IS A PROPERTY OF THE ARCHITECT AND SHALL NOT BE REPRODUCED OR USED WITHOUT THEIR WRITTEN PERMISSION.

SCALE -                      DATE -                      REV NO. -

1 : 100                      10/10/2024                     

DRAWN BY -                      CHECKED BY -

YK                      AR NS

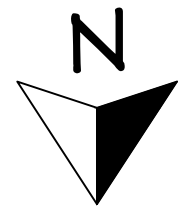

**PROJECT -**

**PROPOSED  
SHOPPING COMPLEX  
AT SOLAPUR**

**ARCHITECT -**

VAISHNAVI G. KARBHARI.  
ROLL NO. - 55M/21/08  
4TH YR, SEM VII (B.ARCH)  
555M'S COLLEGE OF  
ARCHITECTURE, SOLAPUR.

**SIGN AND STAMP -**

PROFORMA -

WORKING DRAWING - II

SHEET TITLE -

SECTIONS

NOTES -

- 1) ALL DIMENSIONS ARE IN MM UNTIL SPECIFIED.  
2) DO NOT MEASURE DRAWING, FOLLOW WRITTEN DIMENSIONS ONLY.  
3) PLEASE REFER TO THE ARCHITECT IN CONCERN TO ANY QUERY OR DRAWING.  
4) THIS DRAWING IS A PROPERTY OF THE ARCHITECT AND SHALL NOT BE REPRODUCED OR USED WITHOUT THEIR WRITTEN PERMISSION.

SCALE -

DATE -

REV NO. -

1 : 100


05/11/2024

DRAWN BY -

CHECKED BY -

VK

AR NS

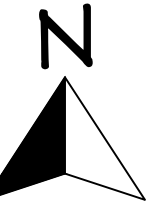


PROJECT -

PROPOSED  
SHOPPING COMPLEX  
AT SOLAPUR


ARCHITECT -

VAISHNAVI G. KARBHARI.  
ROLL NO. - 99M/21/08  
4TH YR, SEM VII (B.ARCH)  
99M'S COLLEGE OF  
ARCHITECTURE, SOLAPUR.

SIGN AND STAMP -

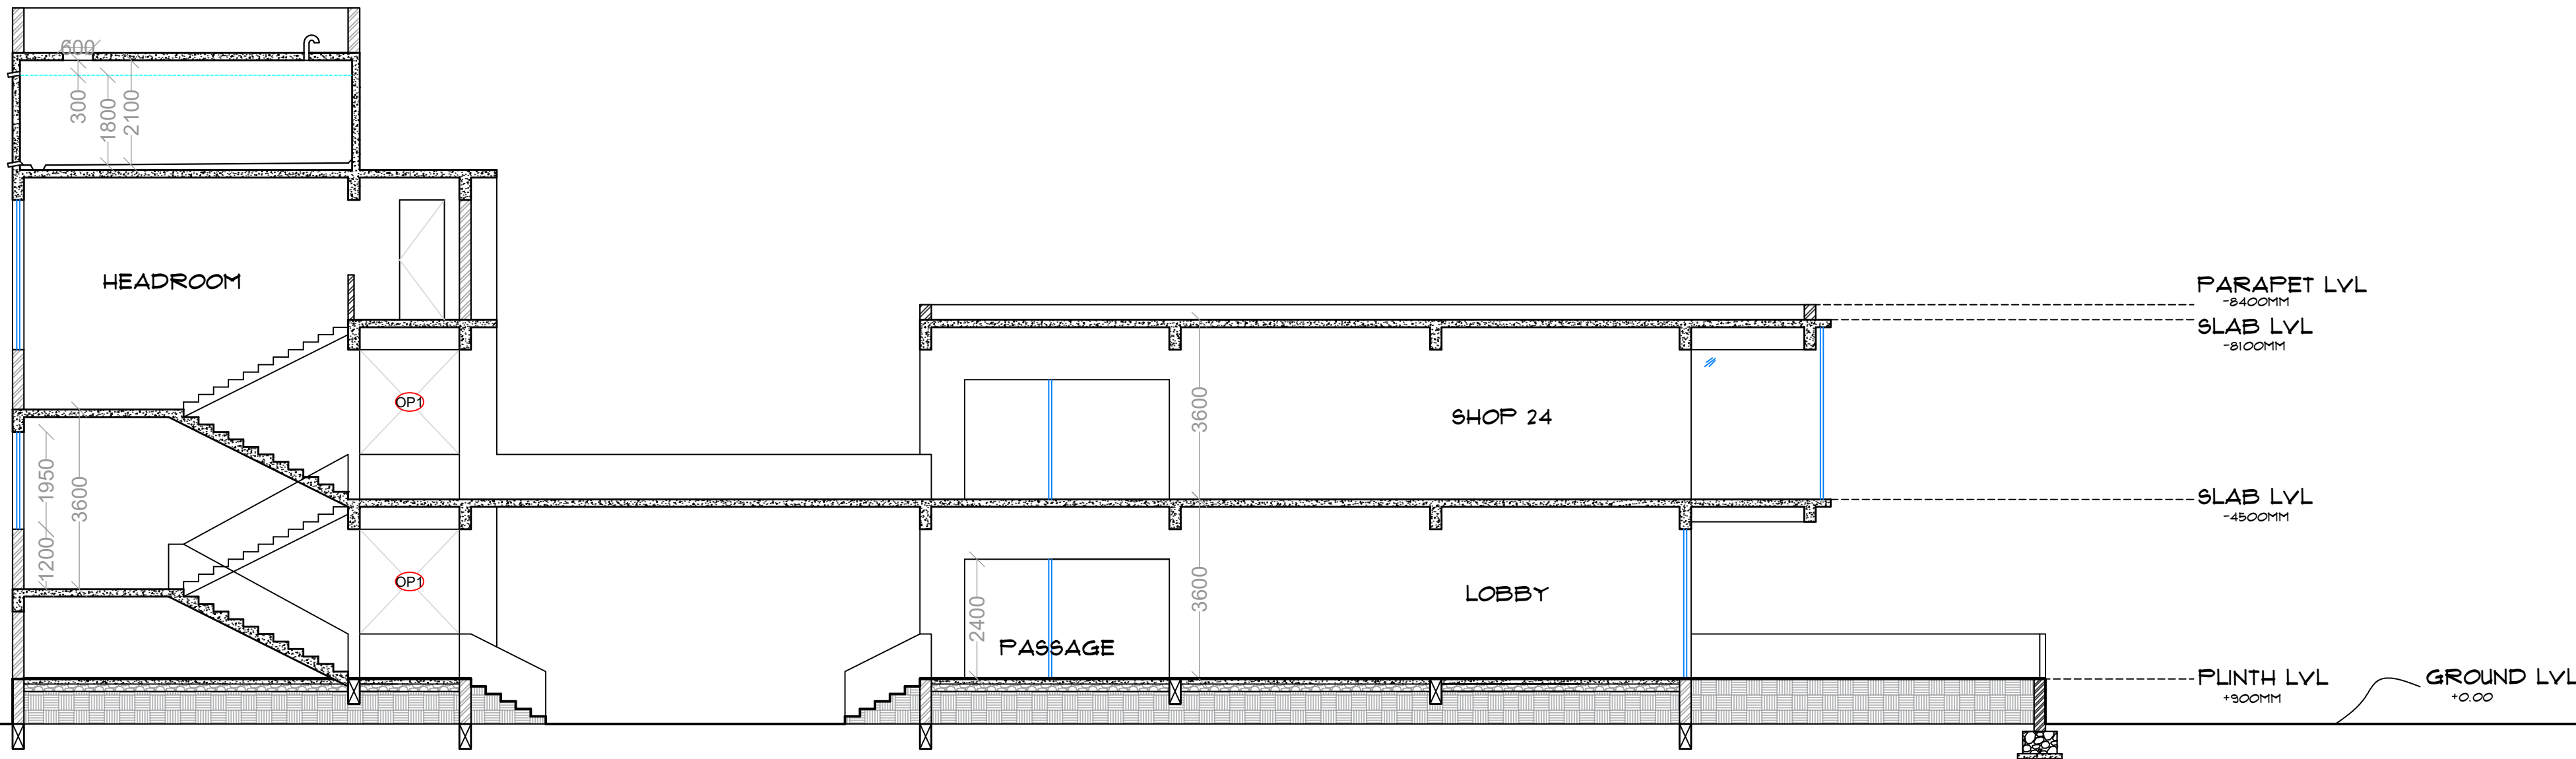

SECTION AA'  
SCALE - 1:100

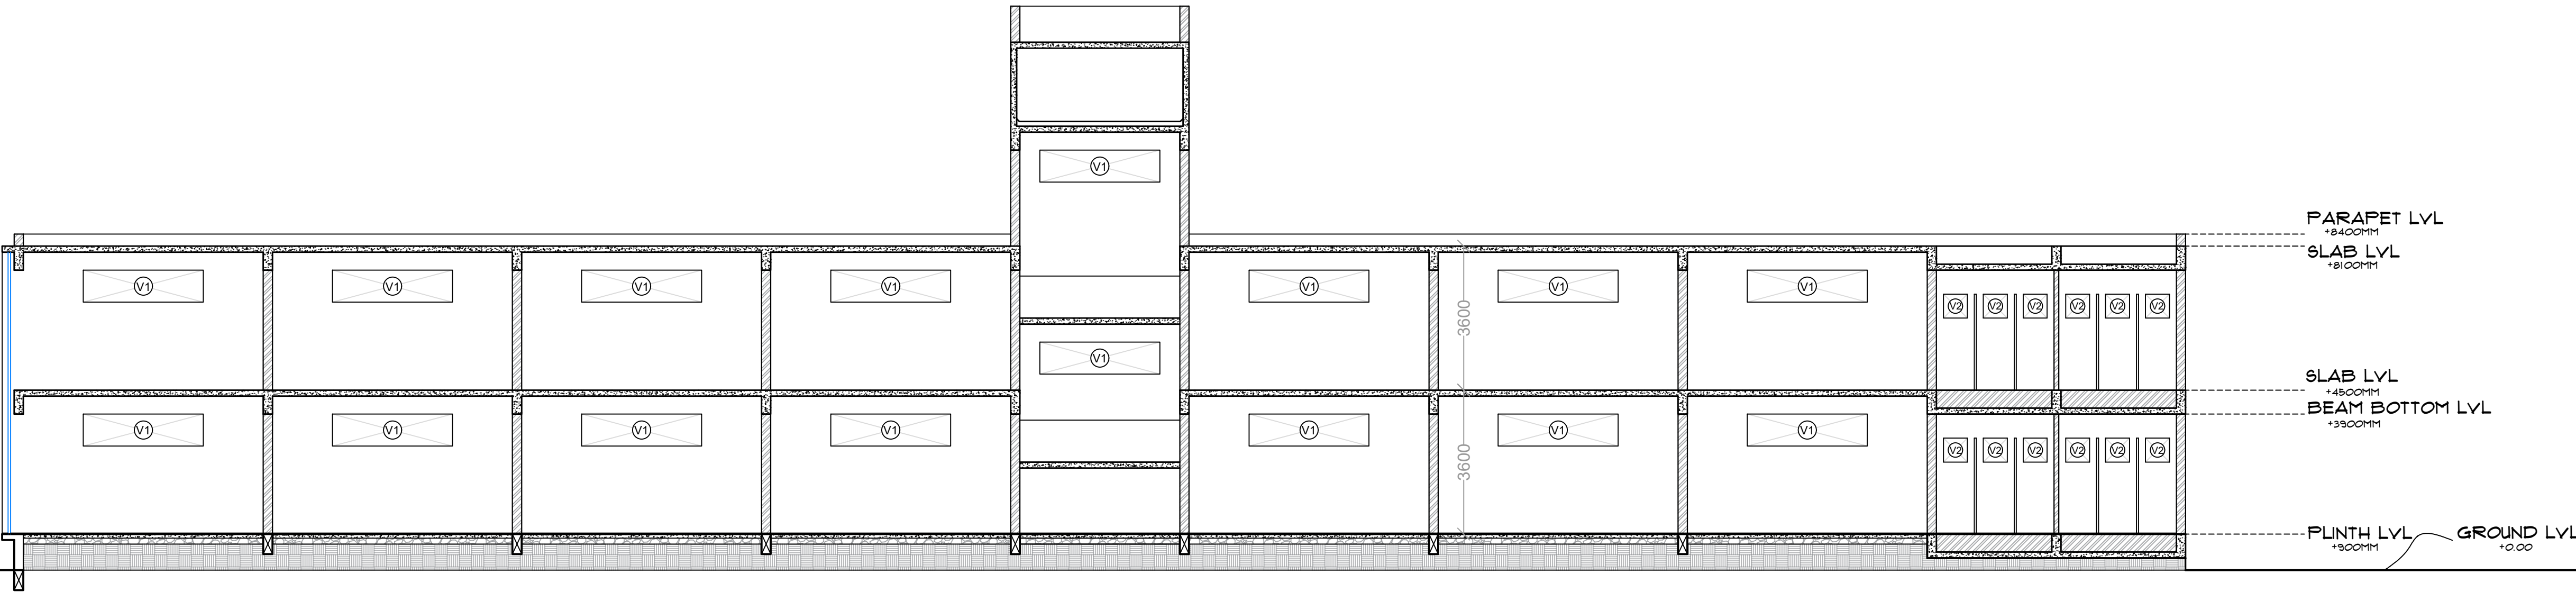

SECTION BB'  
SCALE - 1:100

PROFORMA -

WORKING DRAWING - II

SHEET TITLE -

ELEVATIONS

NOTES -

- 1) ALL DIMENSIONS ARE IN MM UNTIL SPECIFIED.
- 2) DO NOT MEASURE DRAWING, FOLLOW WRITTEN DIMENSIONS ONLY.
- 3) PLEASE REFER TO THE ARCHITECT IN CONCERN TO ANY QUERY OR DRAWING.
- 4) THIS DRAWING IS A PROPERTY OF THE ARCHITECT AND SHALL NOT BE REPRODUCED OR USED WITHOUT THEIR WRITTEN PERMISSION.

SCALE -

DATE -

REV NO. -

1 : 100

10/10/2024

DRAWN BY -

CHECKED BY -

VK

AR NS


PROJECT -

PROPOSED  
SHOPPING COMPLEX  
AT SOLAPUR

ARCHITECT -


VAISHNAVI G. KARBHARI.  
ROLL NO. - 99M/21/08  
4TH YR, SEM VII (B.ARCH)  
999M'S COLLEGE OF  
ARCHITECTURE, SOLAPUR.

SIGN AND STAMP -

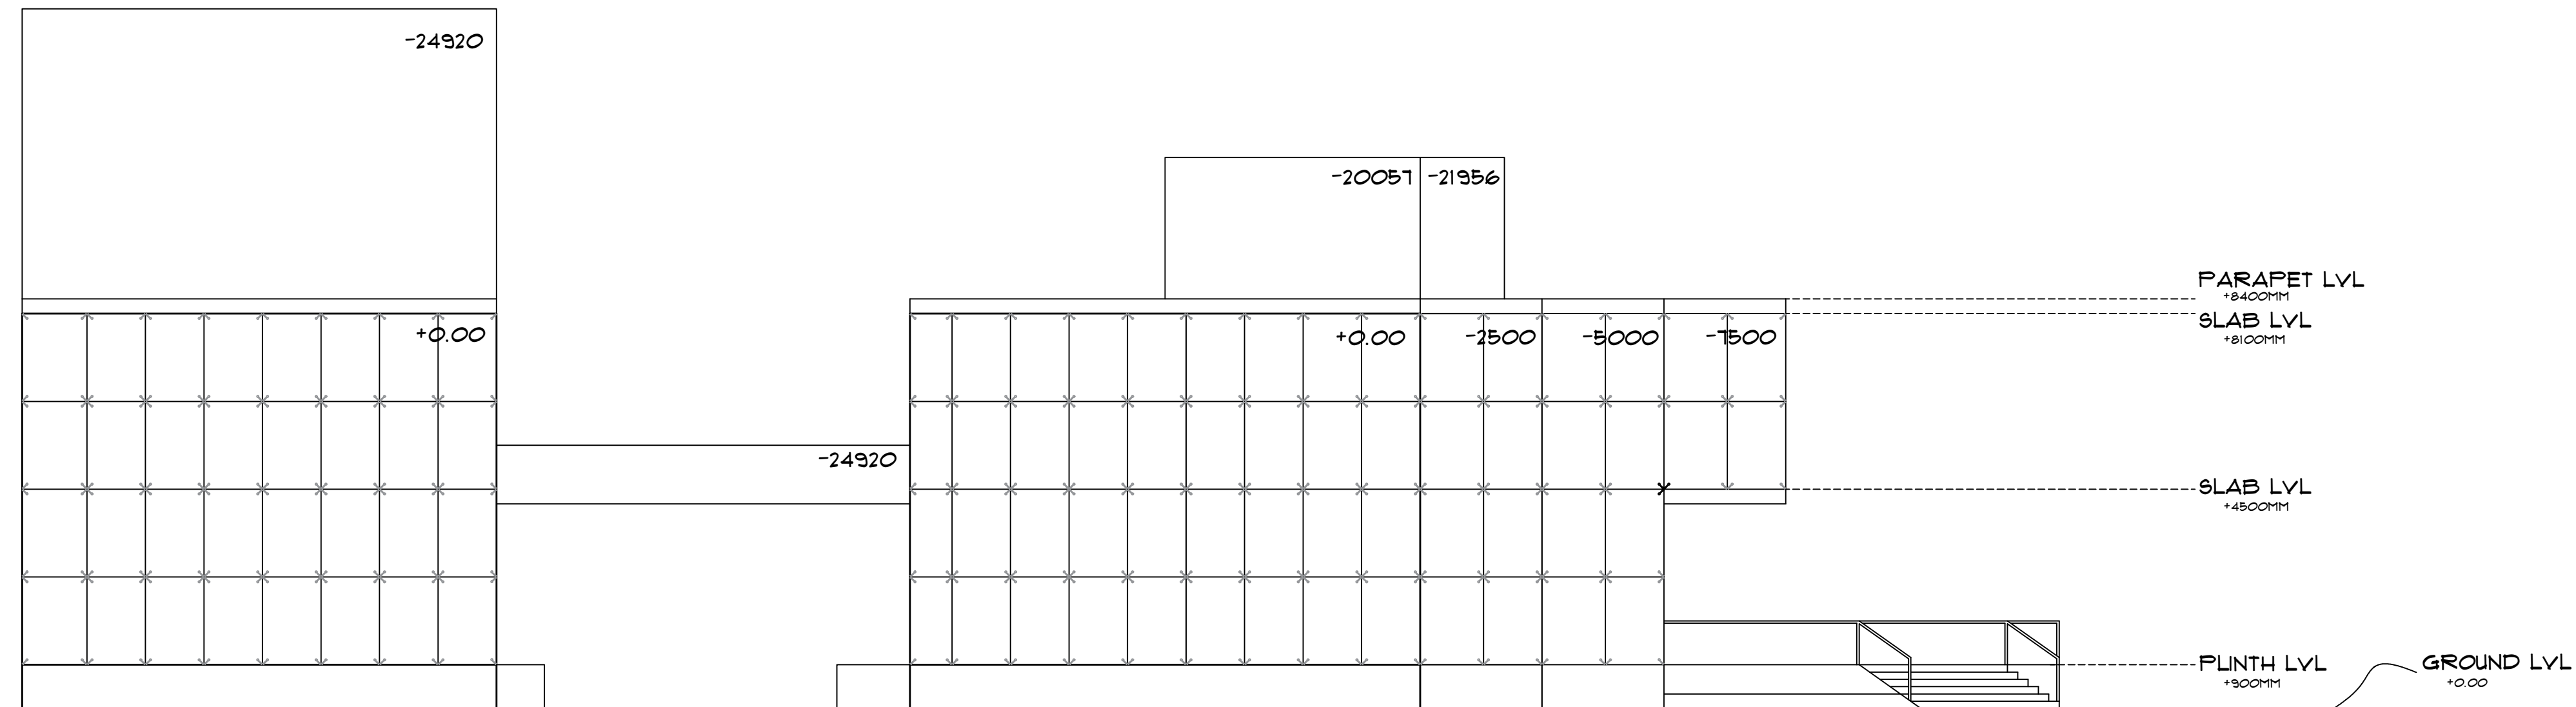


EAST-SIDE ELEVATION

SCALE - 1:100

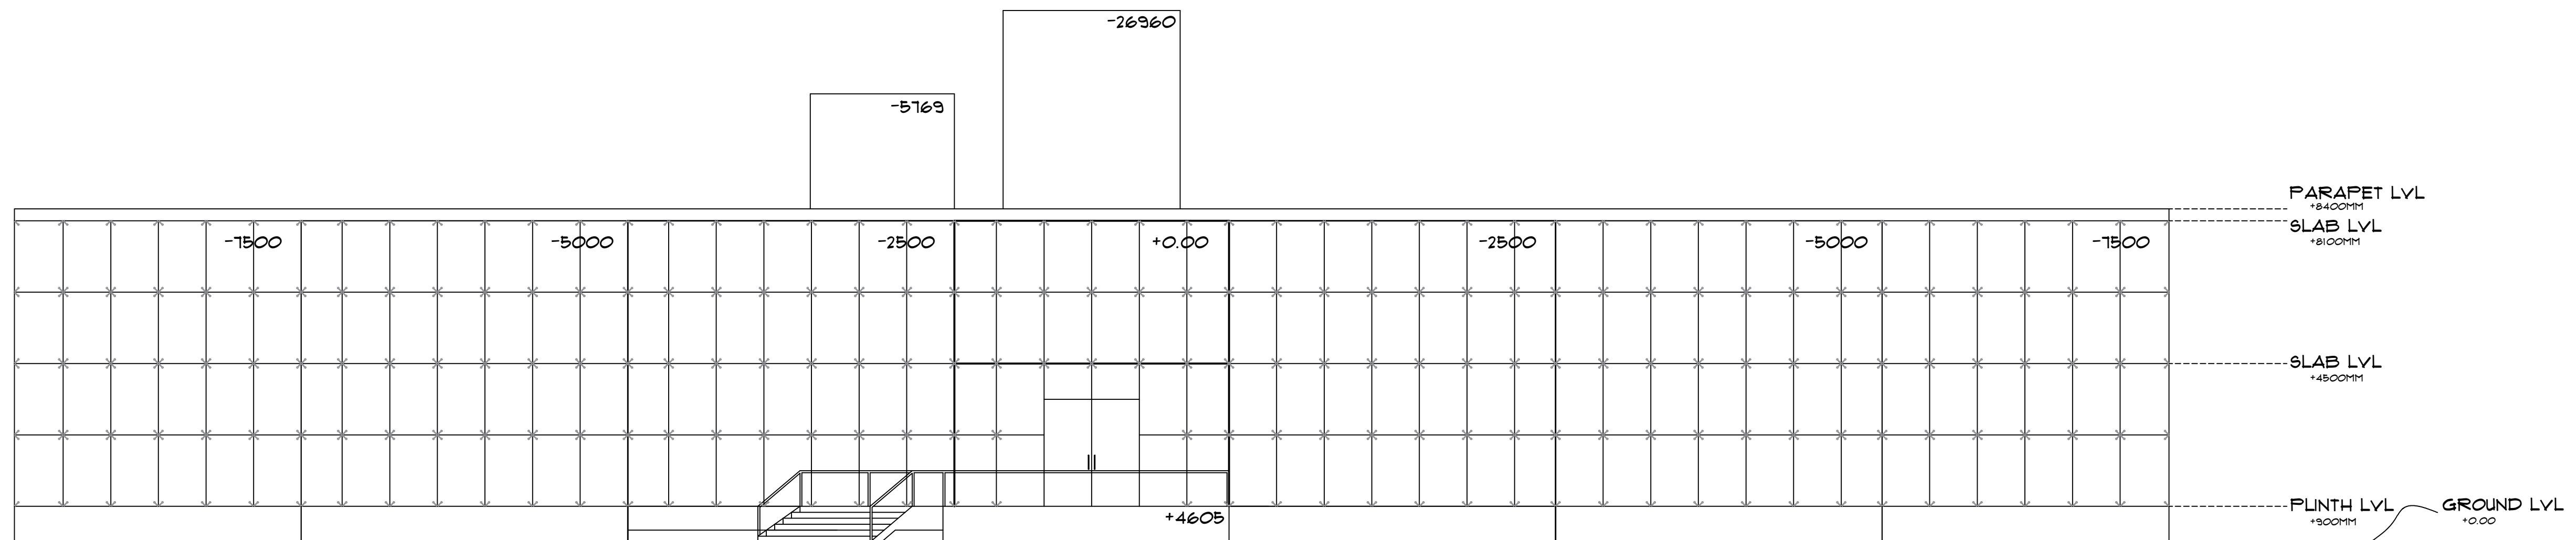


NORTH-SIDE ELEVATION

SCALE - 1:100

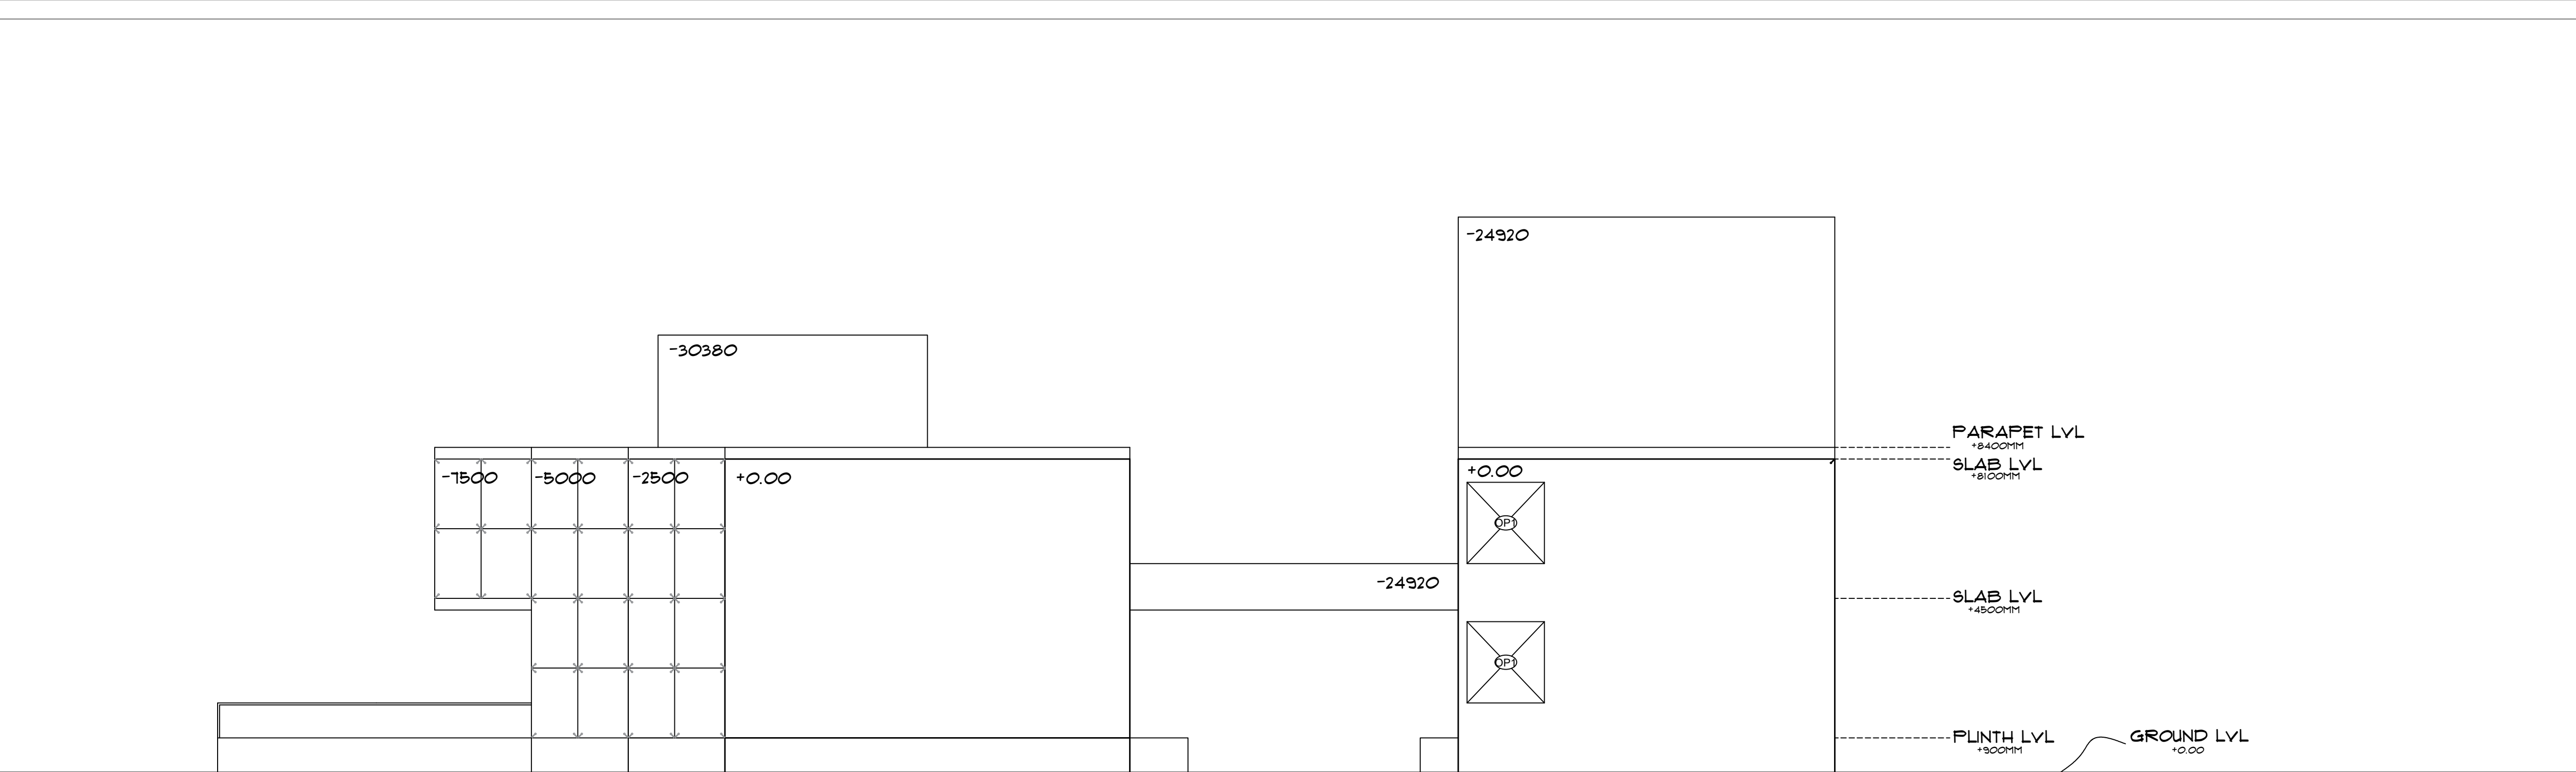

WEST-SIDE ELEVATION  
SCALE - 1:100

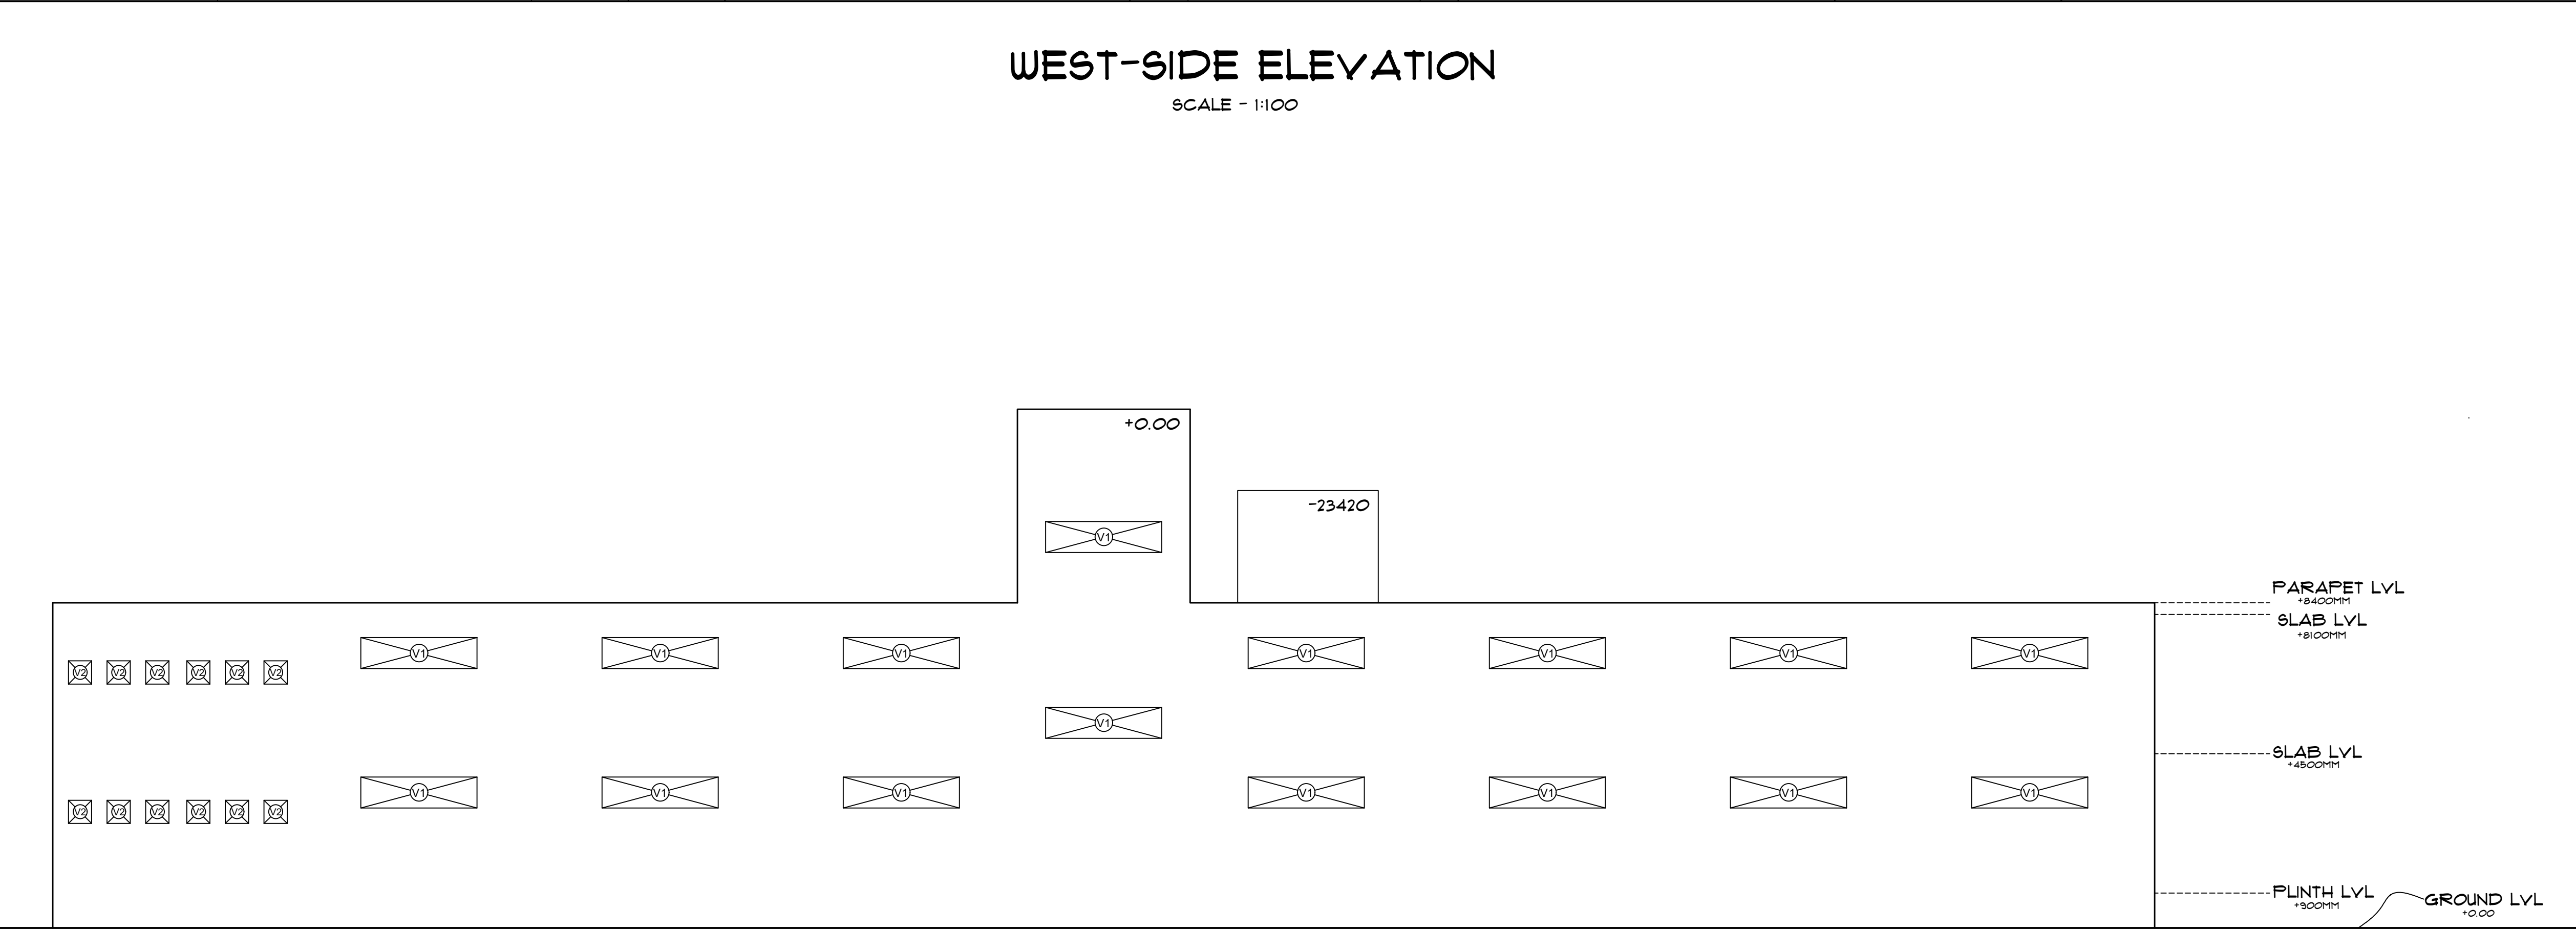

SOUTH-SIDE ELEVATION  
SCALE - 1:100

PROFORMA -

WORKING DRAWING - II

SHEET TITLE -

ELEVATIONS

NOTES -

- 1) ALL DIMENSIONS ARE IN MM UNTIL SPECIFIED.
- 2) DO NOT MEASURE DRAWING, FOLLOW WRITTEN DIMENSIONS ONLY.
- 3) PLEASE REFER TO THE ARCHITECT IN CONCERN TO ANY QUERY OR DRAWING.
- 4) THIS DRAWING IS A PROPERTY OF THE ARCHITECT AND SHALL NOT BE REPRODUCED OR USED WITHOUT THEIR WRITTEN PERMISSION.

SCALE -

DATE -

REV NO. -

1 : 100

10/10/2024

DRAWN BY -

CHECKED BY -

YK

AR NS


PROJECT -

PROPOSED  
SHOPPING COMPLEX  
AT SOLAPUR

ARCHITECT -

VAISHNAVI G. KARBHARI.  
ROLL NO. - 55M/21/08  
4TH YR, SEM VII (B.ARCH)  
555M'S COLLEGE OF  
ARCHITECTURE, SOLAPUR.

SIGN AND STAMP -

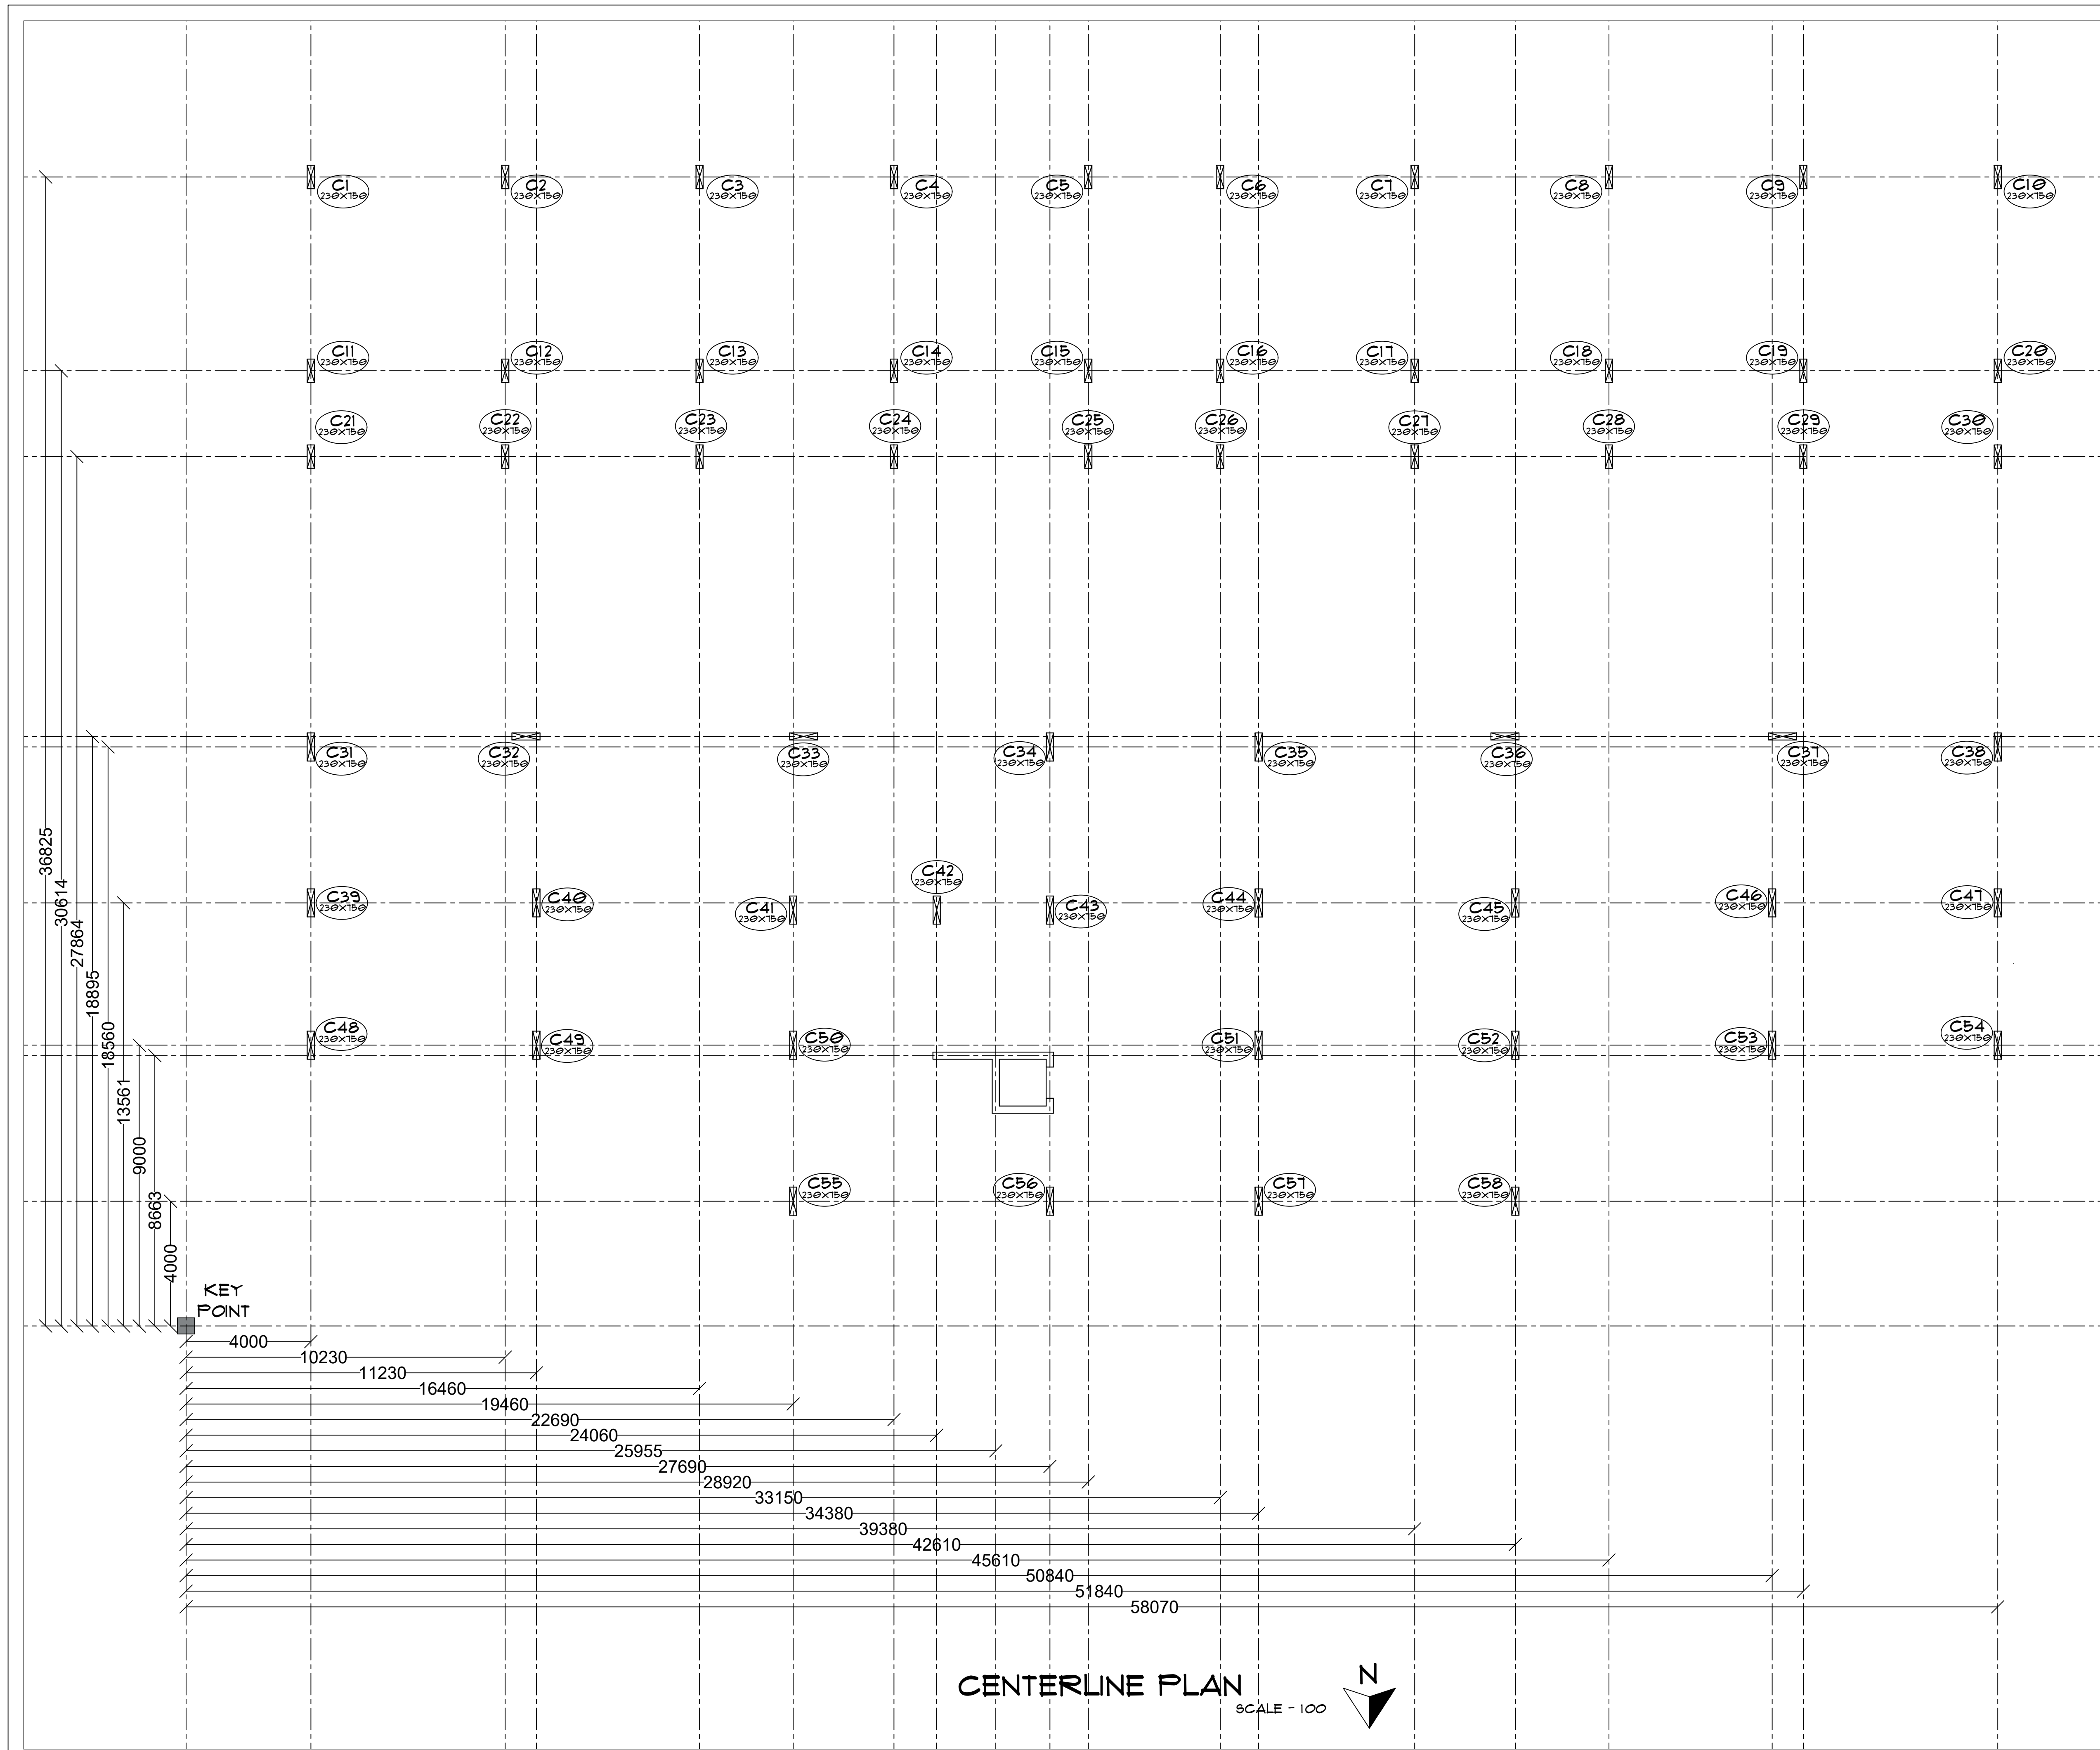


PROFORMA -

WORKING DRAWING - II

SHEET TITLE -

CENTERLINE PLAN

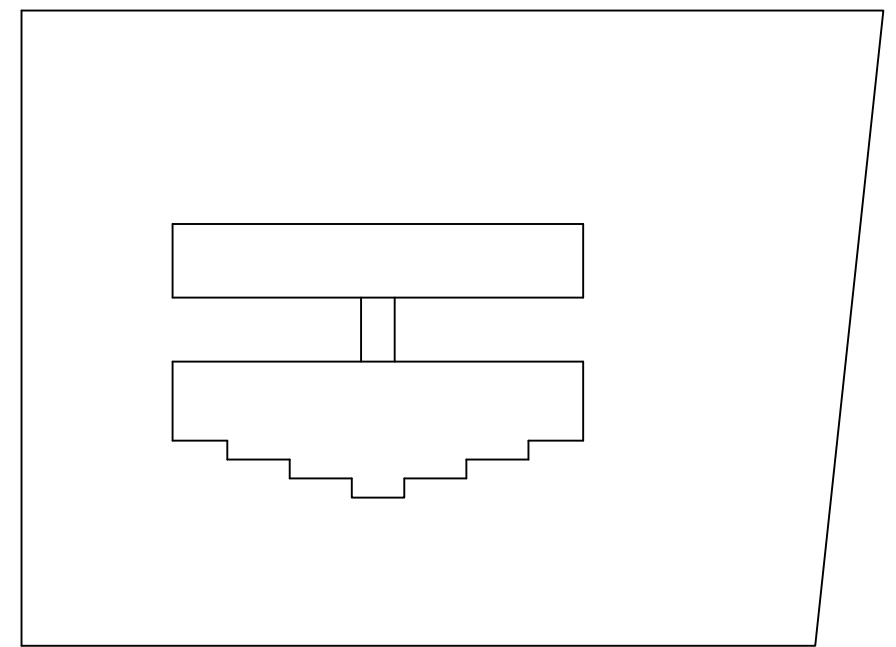

KEY BLOCK PLAN  
SCALE - 1000

NOTES -

- 1) ALL DIMENSIONS ARE IN MM UNTIL SPECIFIED.
- 2) DO NOT MEASURE DRAWING, FOLLOW WRITTEN DIMENSIONS ONLY.
- 3) PLEASE REFER TO THE ARCHITECT IN CONCERN TO ANY QUERY OR DRAWING.
- 4) THIS DRAWING IS A PROPERTY OF THE ARCHITECT AND SHALL NOT BE REPRODUCED OR USED WITHOUT THEIR WRITTEN PERMISSION.

| SCALE -    | DATE -       | REV NO. - |
|------------|--------------|-----------|
| 1 : 100    | 06/11/2024   |           |
| DRAWN BY - | CHECKED BY - |           |
| VK         | AR NS        |           |



PROJECT -

PROPOSED  
SHOPPING COMPLEX  
AT SOLAPUR

ARCHITECT -


VAISHNAVI G. KARBHARI.  
ROLL NO. - 99M/21/08  
4TH YR, SEM VII (B.ARCH)  
99M'S COLLEGE OF  
ARCHITECTURE, SOLAPUR.

SIGN AND STAMP -

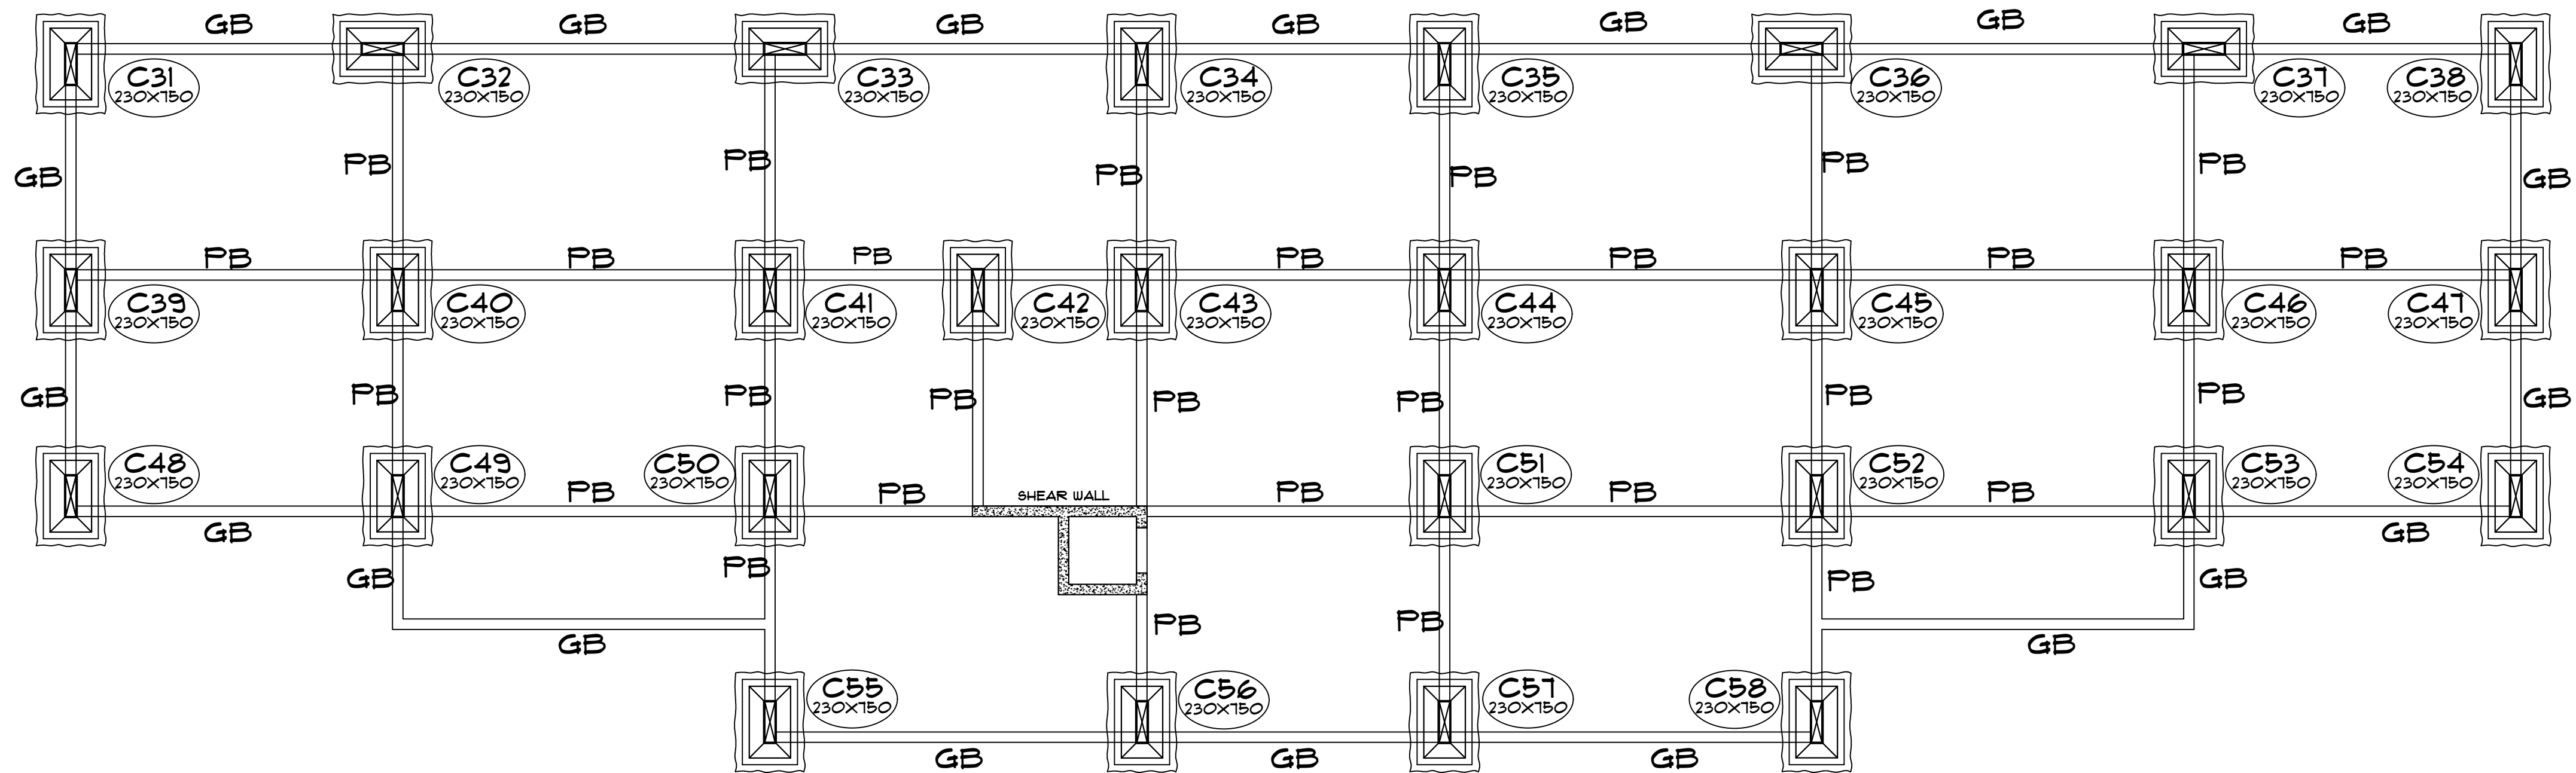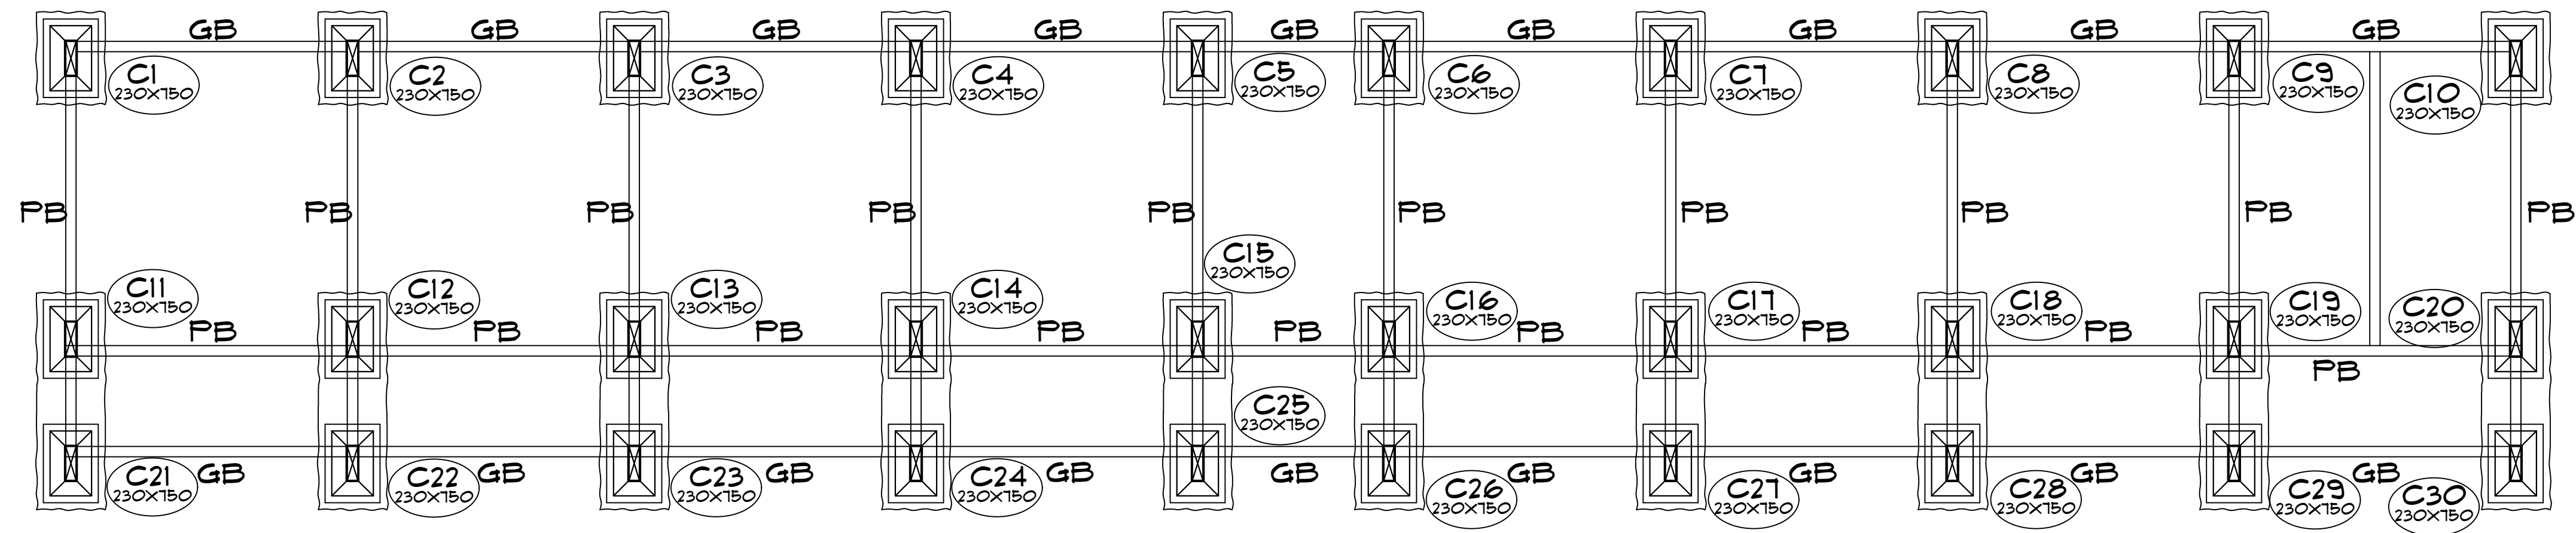


GROUND AND PLINTH BEAM PLAN

SCALE - 1:100

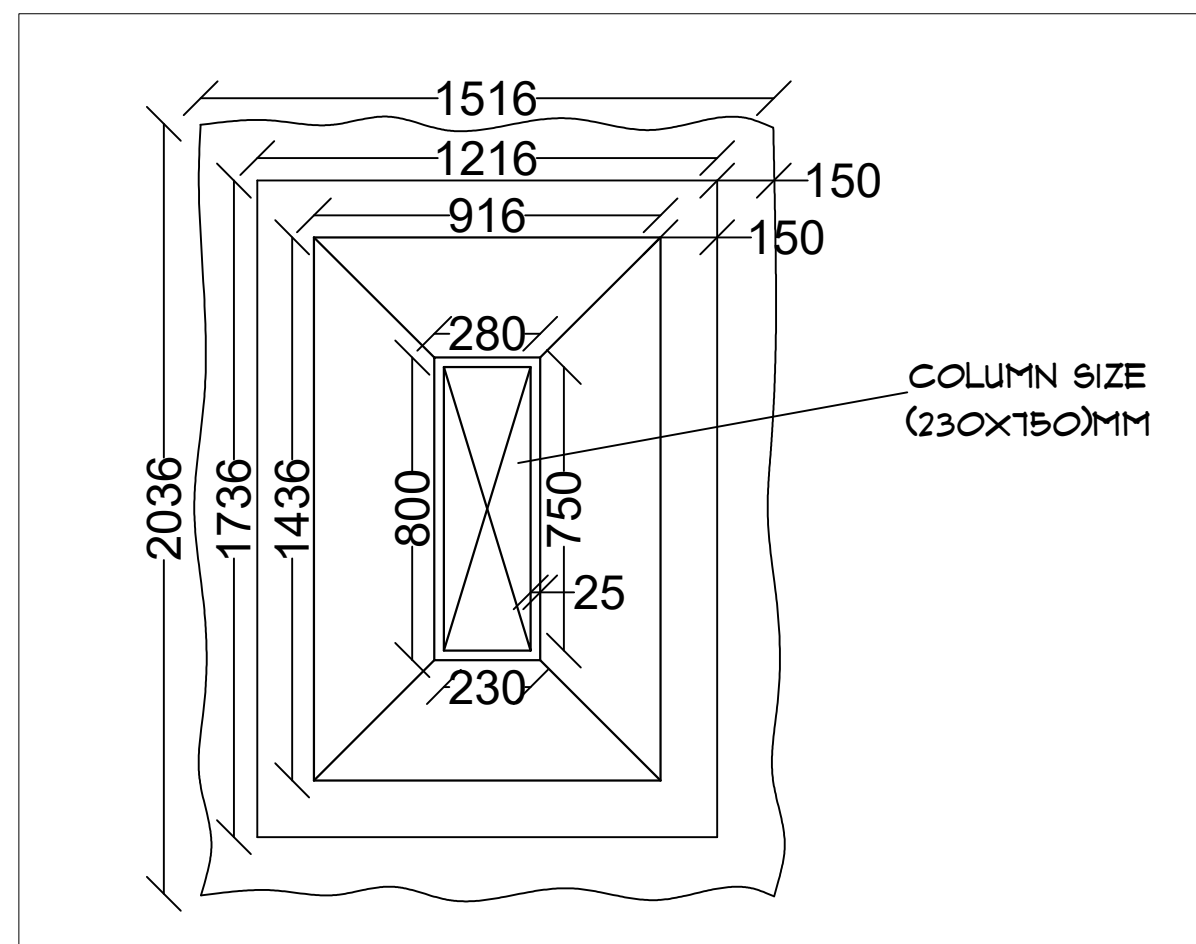

FOUNDATION IN PLAN  
SCALE - 1:20

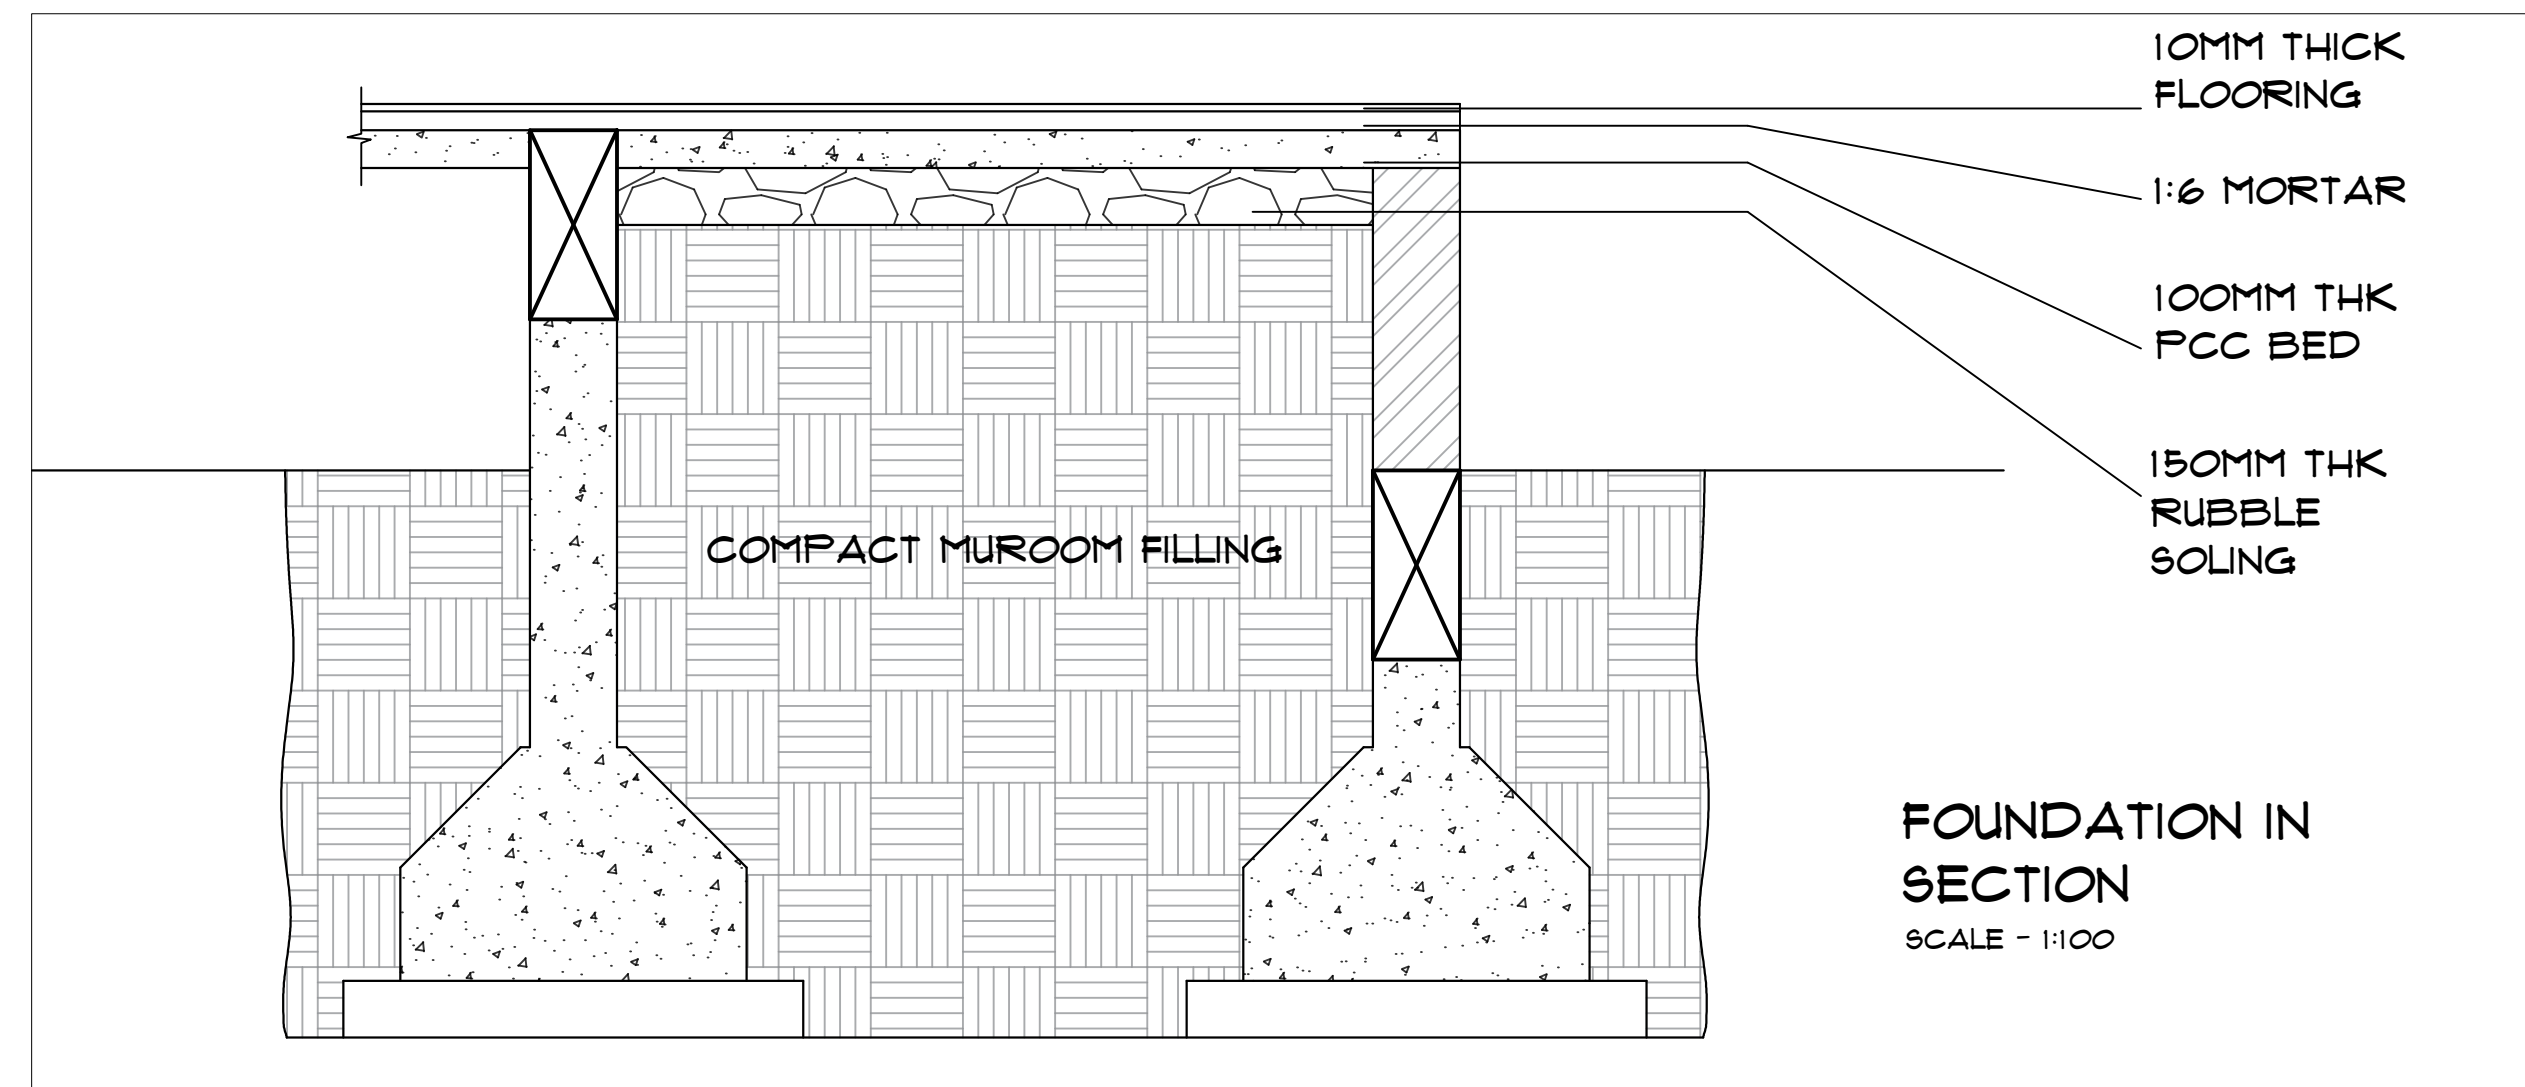

FOUNDATION IN  
SECTION  
SCALE - 1:100

PROFORMA -

WORKING DRAWING - II

SHEET TITLE -

GROUND AND PLINTH  
BEAM PLAN WITH  
FOUNDATION

NOTES -


- 1) ALL DIMENSIONS ARE IN MM UNTIL SPECIFIED.
- 2) DO NOT MEASURE DRAWING, FOLLOW WRITTEN DIMENSIONS ONLY.
- 3) PLEASE REFER TO THE ARCHITECT IN CONCERN TO ANY QUERY OR DRAWING.
- 4) THIS DRAWING IS A PROPERTY OF THE ARCHITECT AND SHALL NOT BE REPRODUCED OR USED WITHOUT THEIR WRITTEN PERMISSION.

SCALE - DATE - REV NO. -

1 : 100 10/10/2024

DRAWN BY - CHECKED BY -

VK AR NS

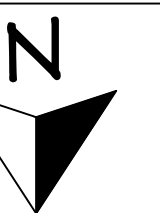


PROJECT -

PROPOSED  
SHOPPING COMPLEX  
AT SOLAPUR

ARCHITECT -


VAISHNAVI G. KARBHARI.  
ROLL NO. - 99M/21/08  
4TH YR, SEM VII (B.ARCH)  
99M'S COLLEGE OF  
ARCHITECTURE, SOLAPUR.

SIGN AND STAMP -

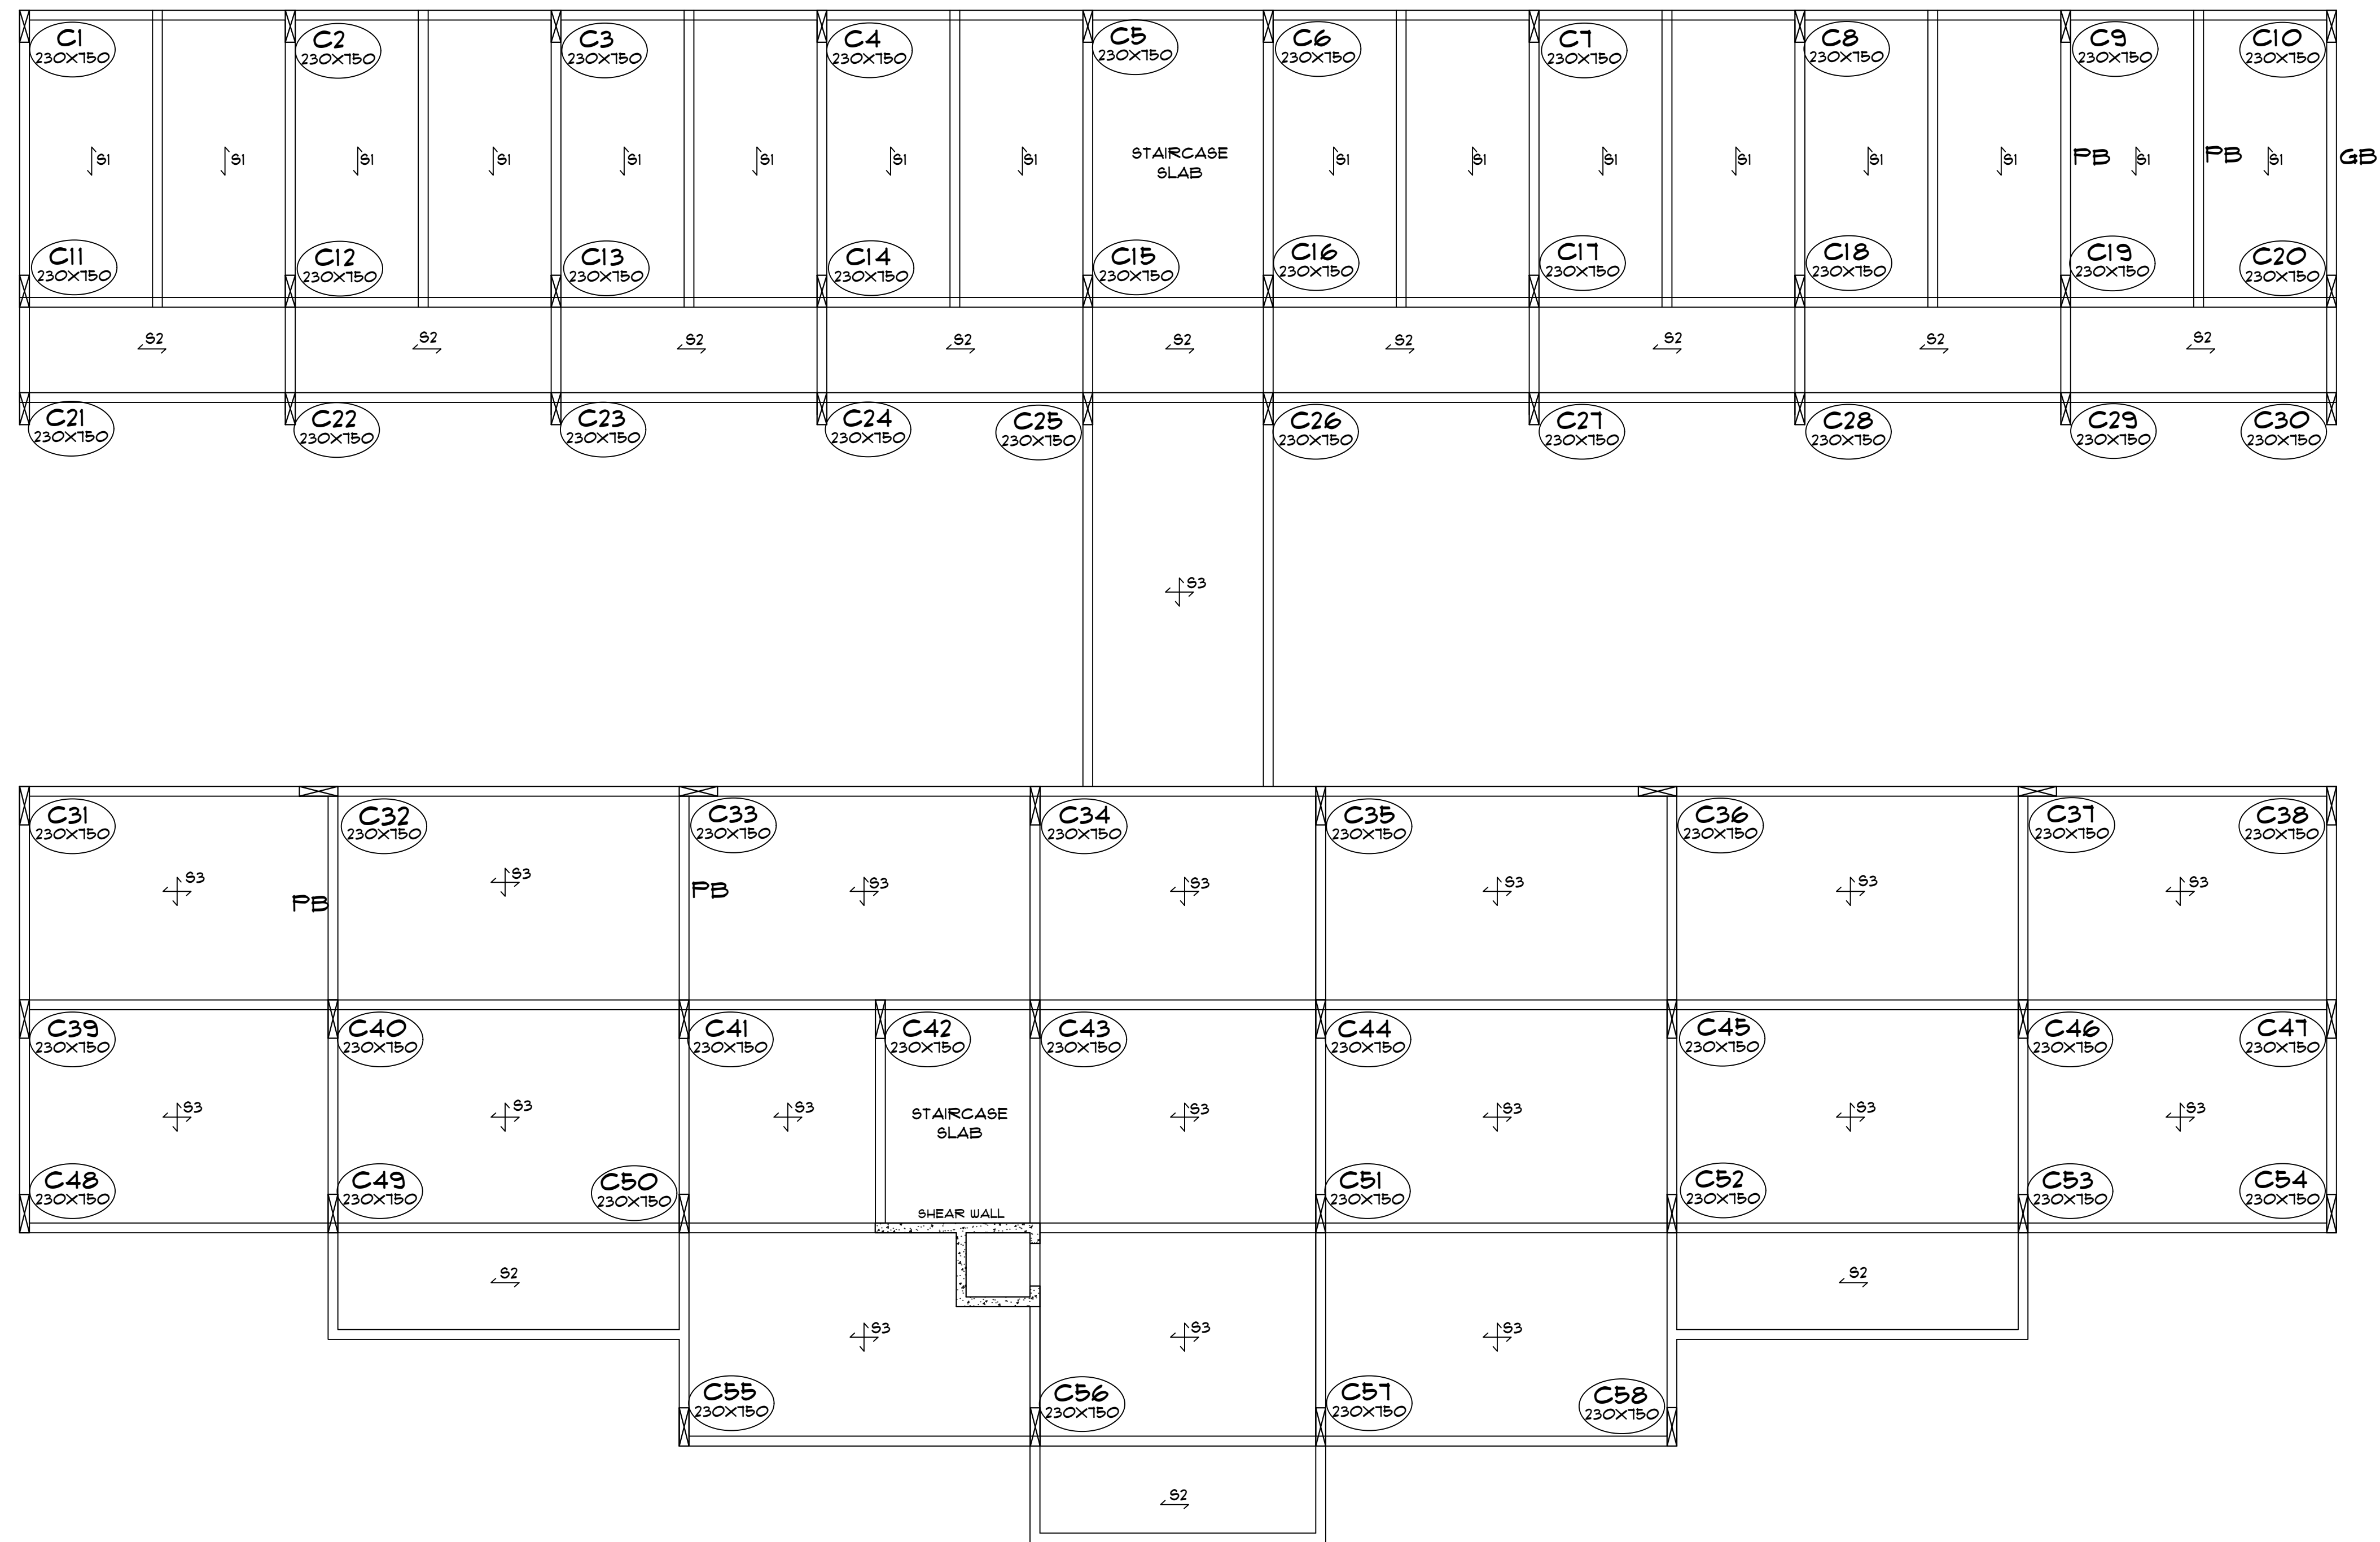

GROUND FLOOR SLAB PLAN

SCALE - 1:100

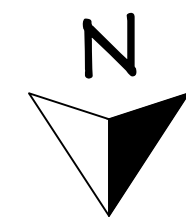

PROFORMA -

WORKING DRAWING - II

SHEET TITLE -

GROUND FLOOR SLAB  
LEVEL FRAMING PLAN

NOTES -

- 1) ALL DIMENSIONS ARE IN MM UNTIL SPECIFIED.
- 2) DO NOT MEASURE DRAWING, FOLLOW WRITTEN DIMENSIONS ONLY.
- 3) PLEASE REFER TO THE ARCHITECT IN CONCERN TO ANY QUERY OR DRAWING.
- 4) THIS DRAWING IS A PROPERTY OF THE ARCHITECT AND SHALL NOT BE REPRODUCED OR USED WITHOUT THEIR WRITTEN PERMISSION.

SCALE -

DATE -

REV NO. -

1:100


10/10/2024

DRAWN BY -

CHECKED BY -

YK

AR NS

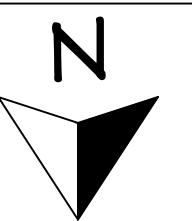



PROJECT -

PROPOSED  
SHOPPING COMPLEX  
AT SOLAPUR


ARCHITECT -

VAISHNAVI G. KARBHARI.  
ROLL NO. - 99M/21/08  
4TH YR, SEM VII (B.ARCH)  
999M'S COLLEGE OF  
ARCHITECTURE, SOLAPUR.

SIGN AND STAMP -

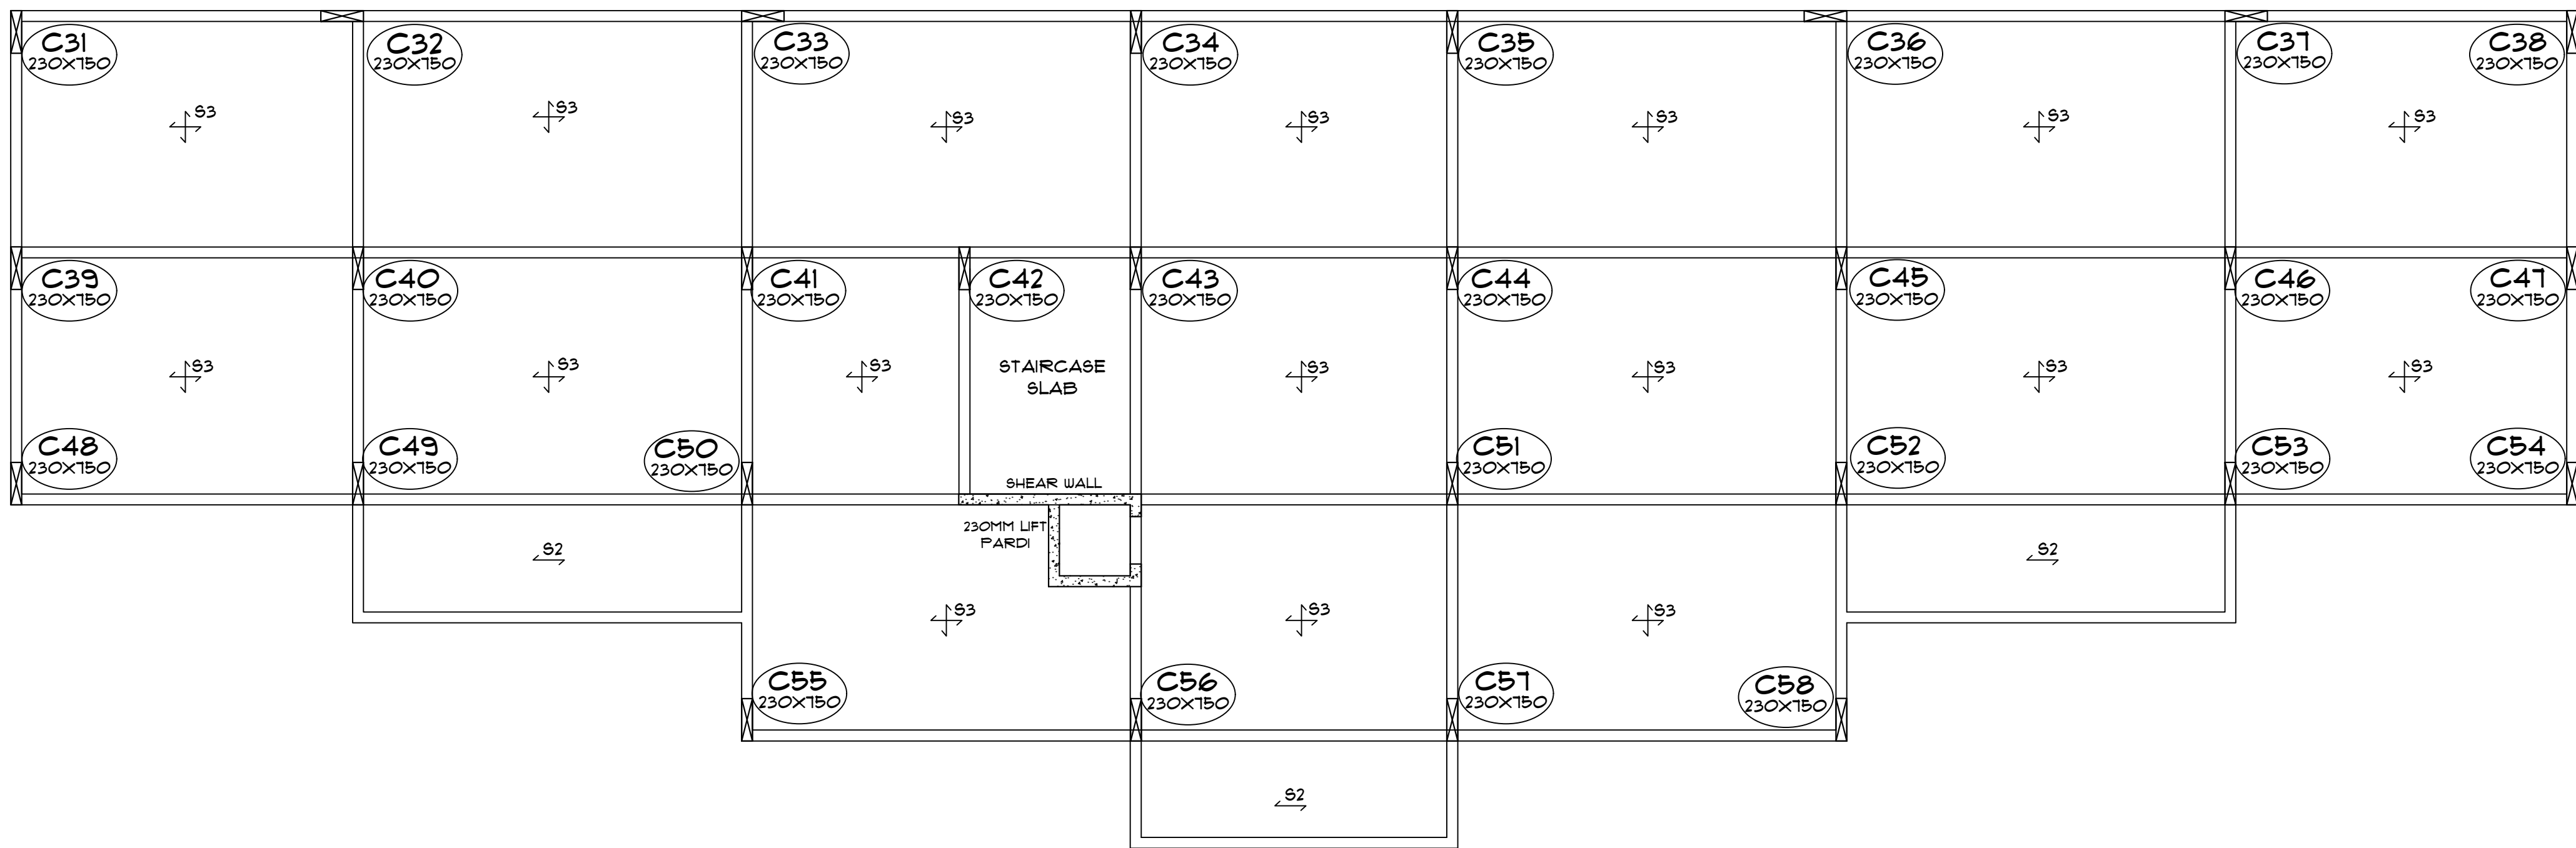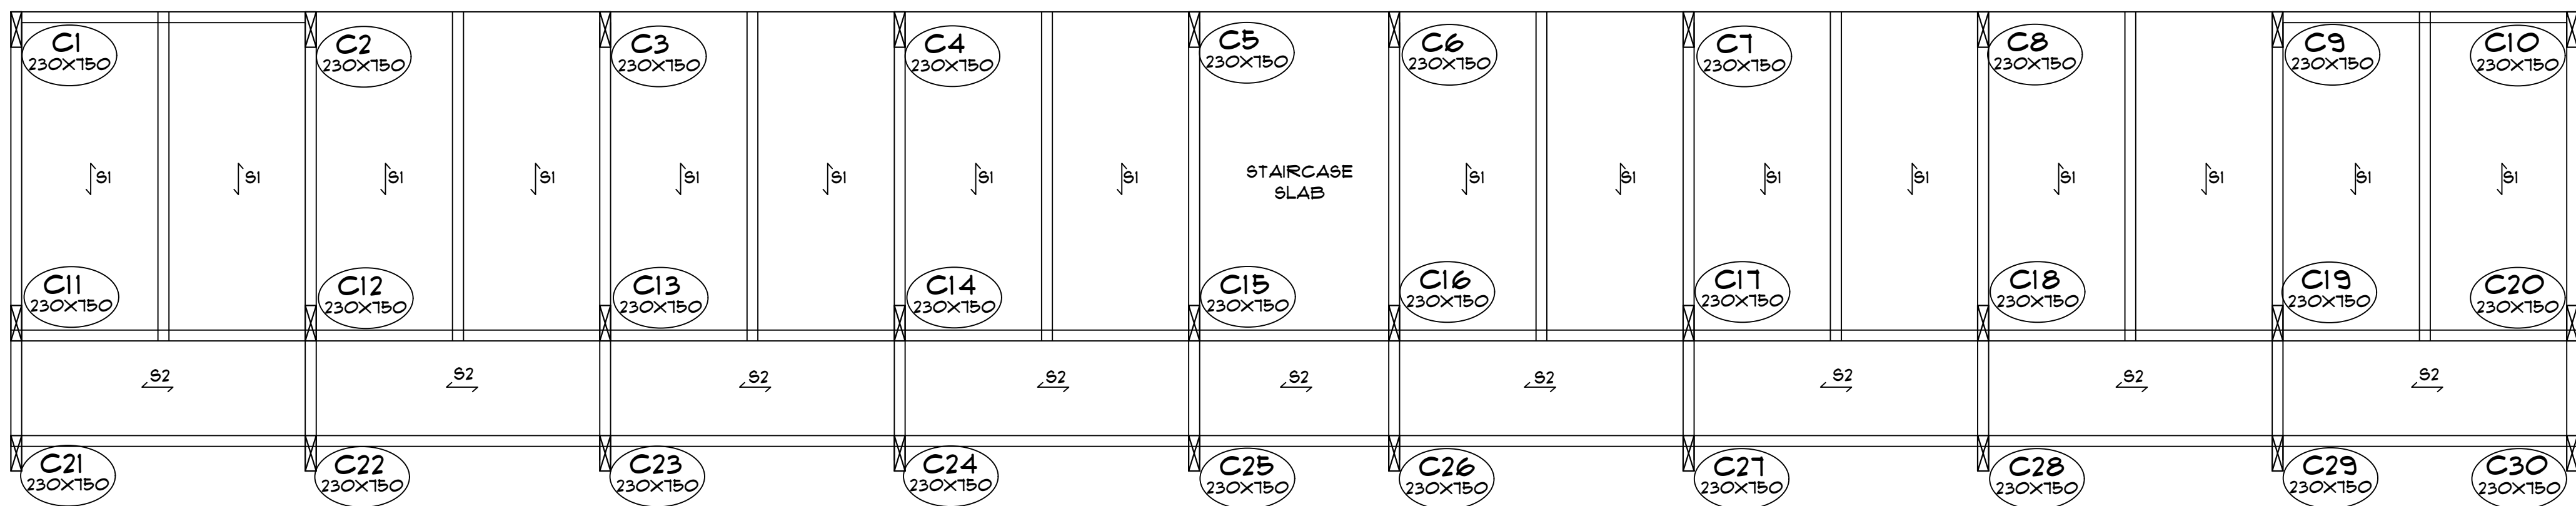

FIRST FLOOR SLAB PLAN  
SCALE - 1:100

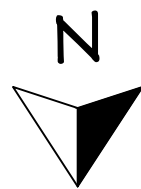

PROFORMA -

WORKING DRAWING - II

SHEET TITLE -

FIRST FLOOR SLAB  
LEVEL FRAMING PLAN

NOTES -

- 1) ALL DIMENSIONS ARE IN MM UNTIL SPECIFIED.
- 2) DO NOT MEASURE DRAWING, FOLLOW WRITTEN DIMENSIONS ONLY.
- 3) PLEASE REFER TO THE ARCHITECT IN CONCERN TO ANY QUERY OR DRAWING.
- 4) THIS DRAWING IS A PROPERTY OF THE ARCHITECT AND SHALL NOT BE REPRODUCED OR USED WITHOUT THEIR WRITTEN PERMISSION.

SCALE -

DATE -

REV NO. -

1 : 100


05/11/2024

DRAWN BY -

CHECKED BY -

YK

AR NS

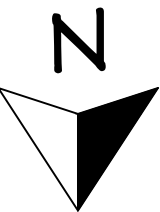


PROJECT -

PROPOSED  
SHOPPING COMPLEX  
AT SOLAPUR


ARCHITECT -

VAISHNAVI G. KARBHARI.  
ROLL NO. - 55M/21/08  
4TH YR, SEM VII (B.ARCH)  
555M'S COLLEGE OF  
ARCHITECTURE, SOLAPUR.


SIGN AND STAMP -

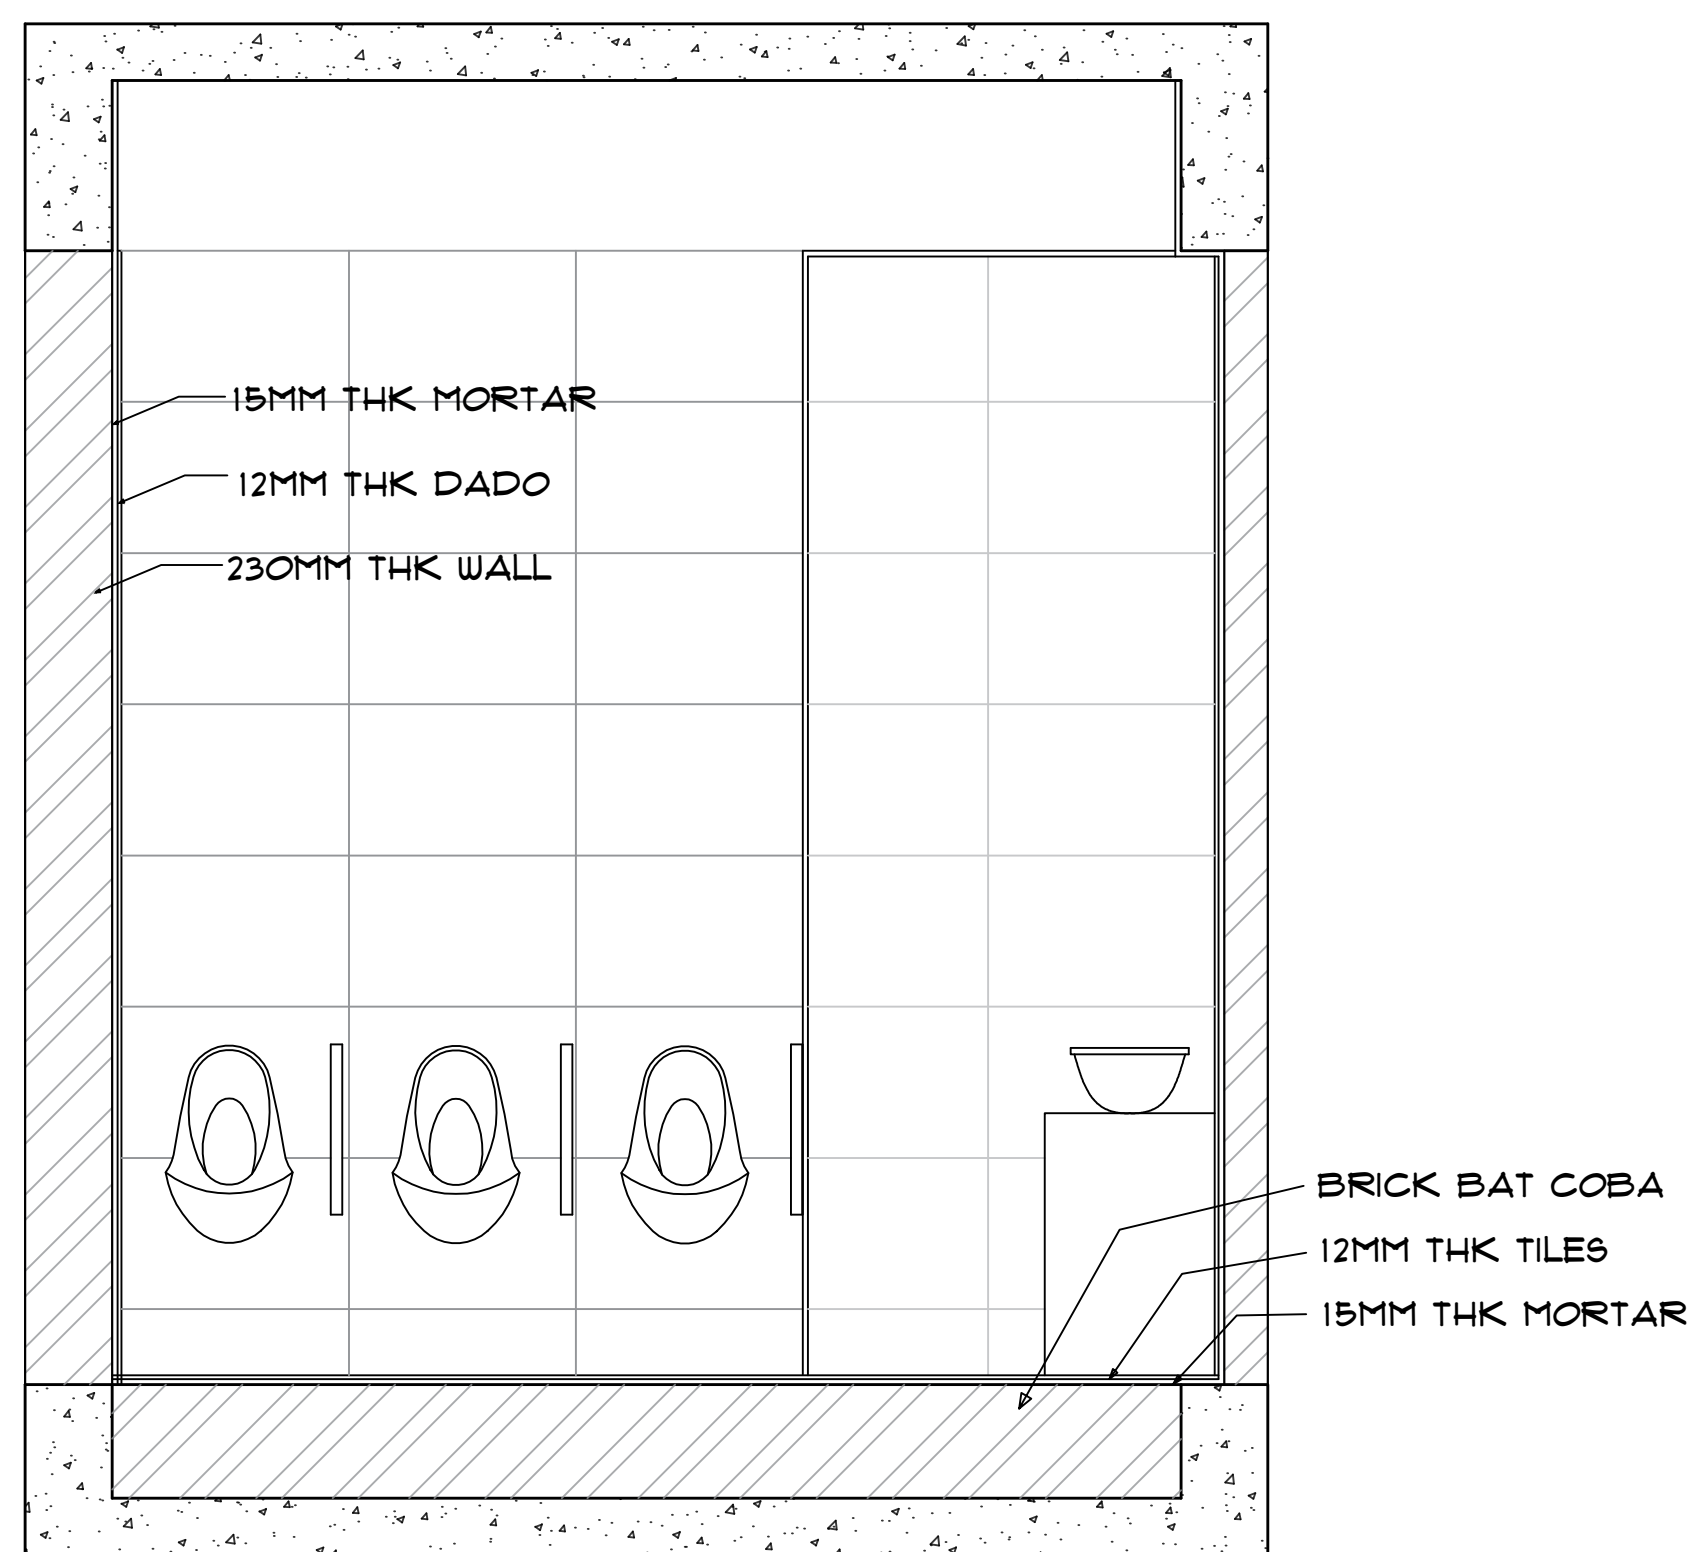

SECTION DD'  
SCALE - 1:20

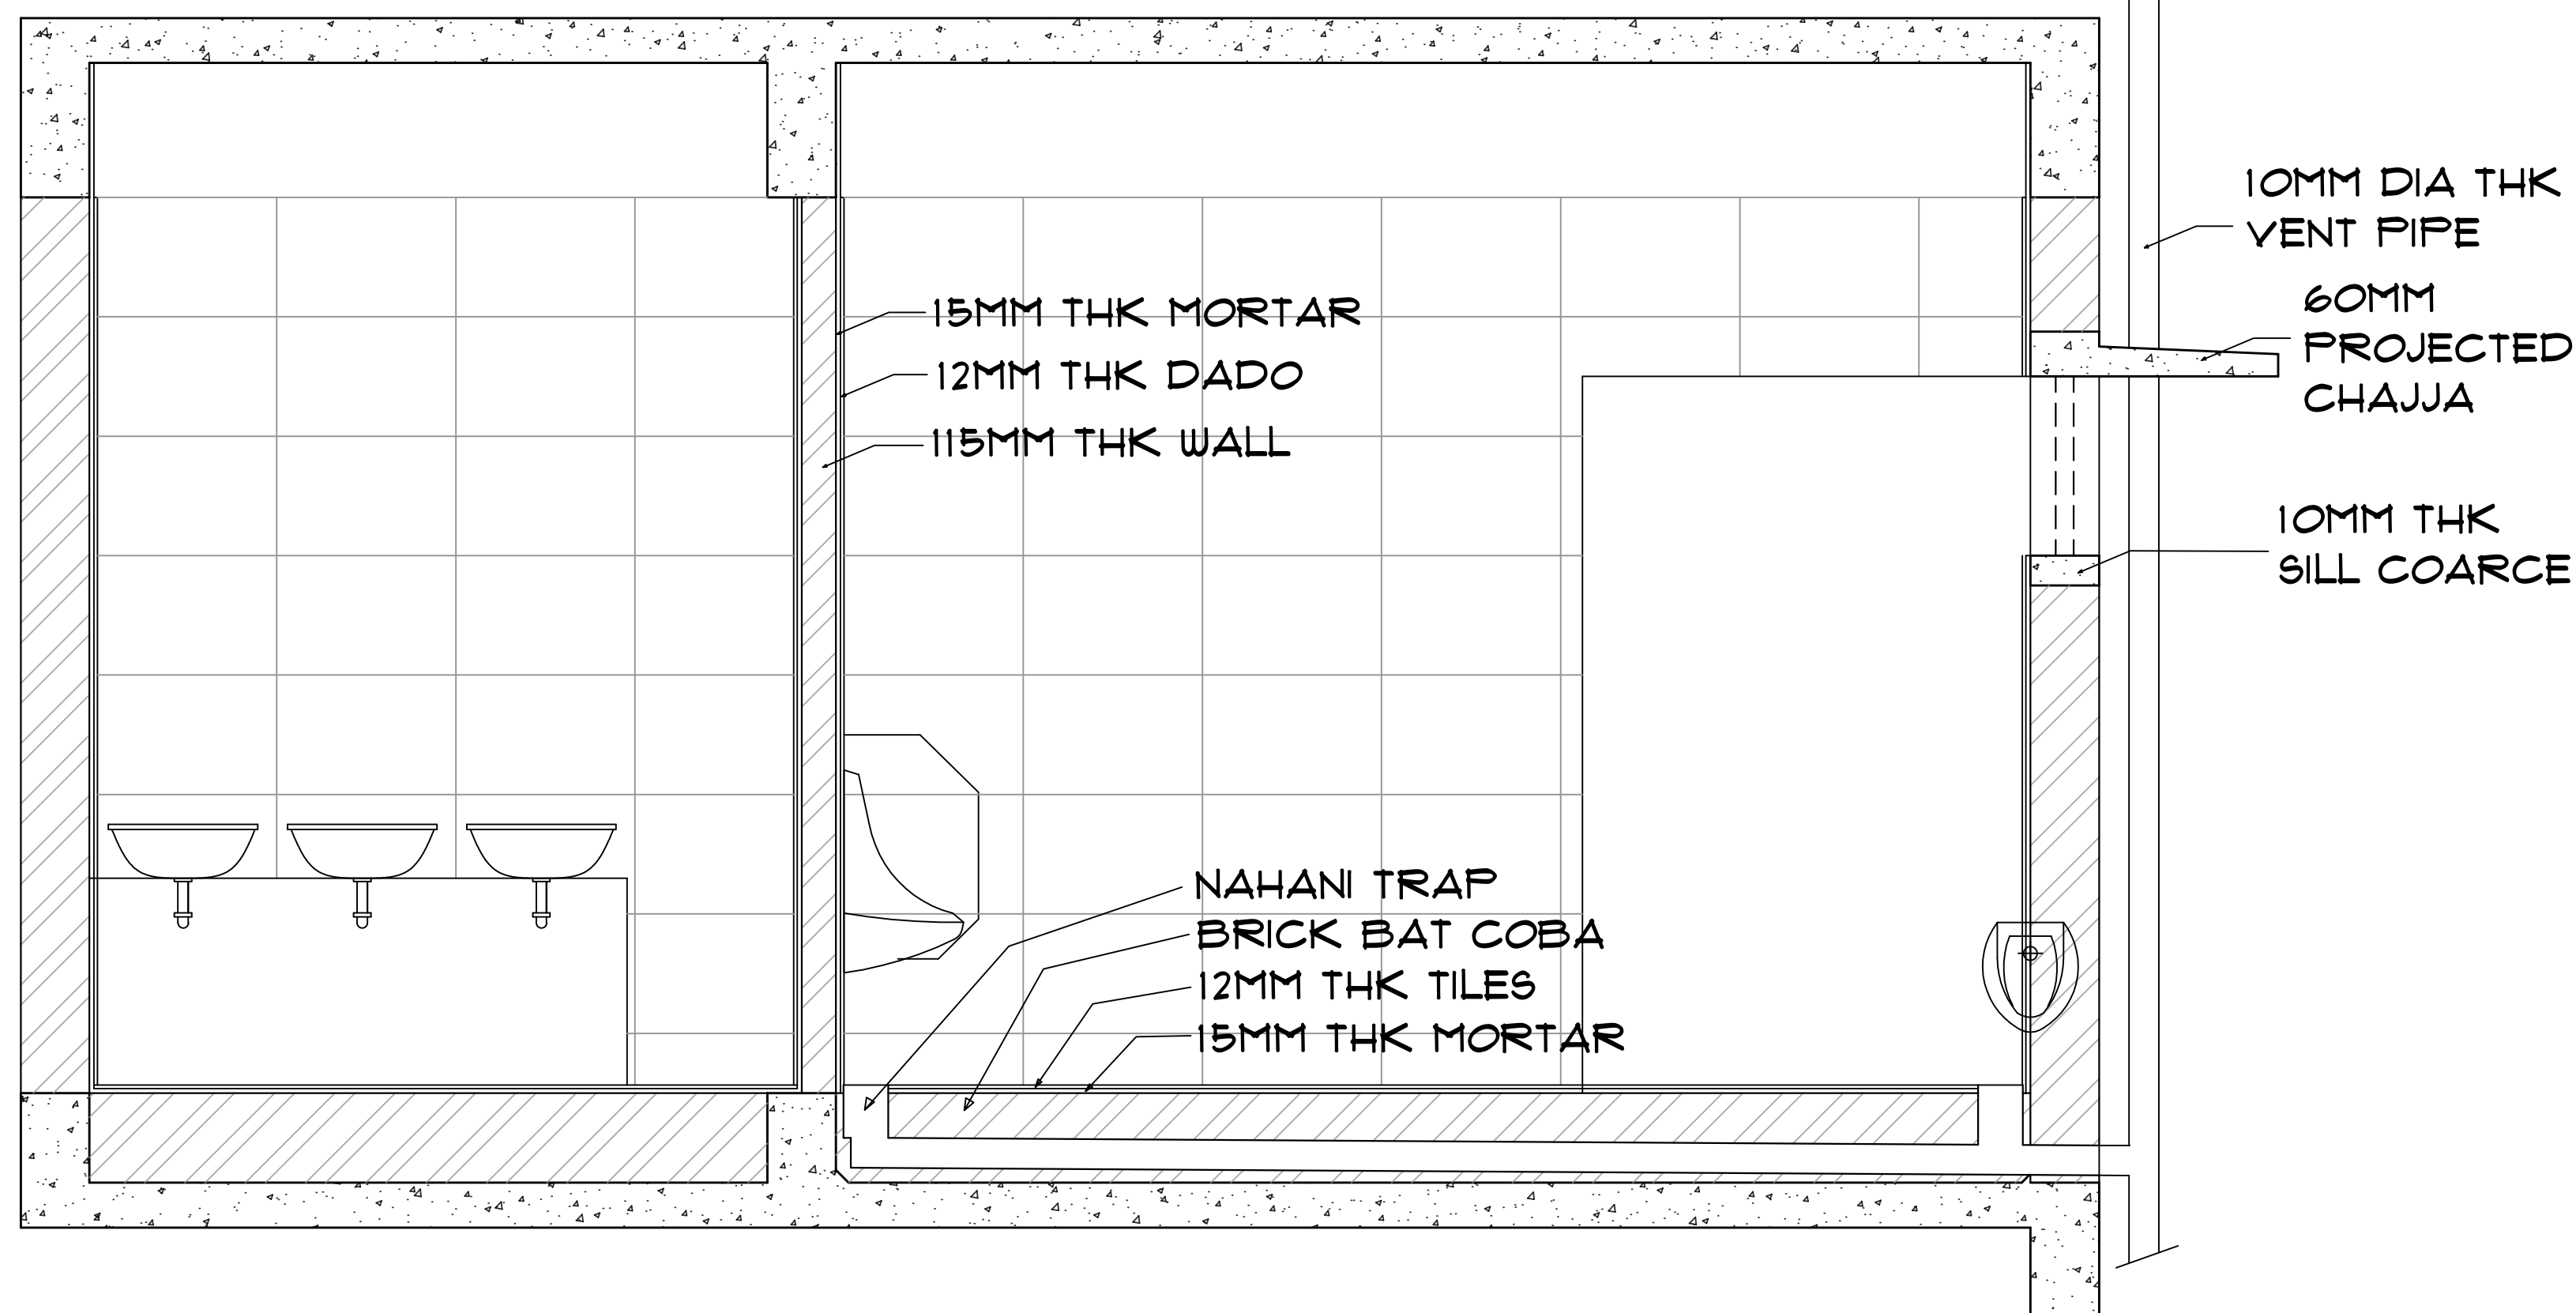

SECTION CC'  
SCALE - 1:20

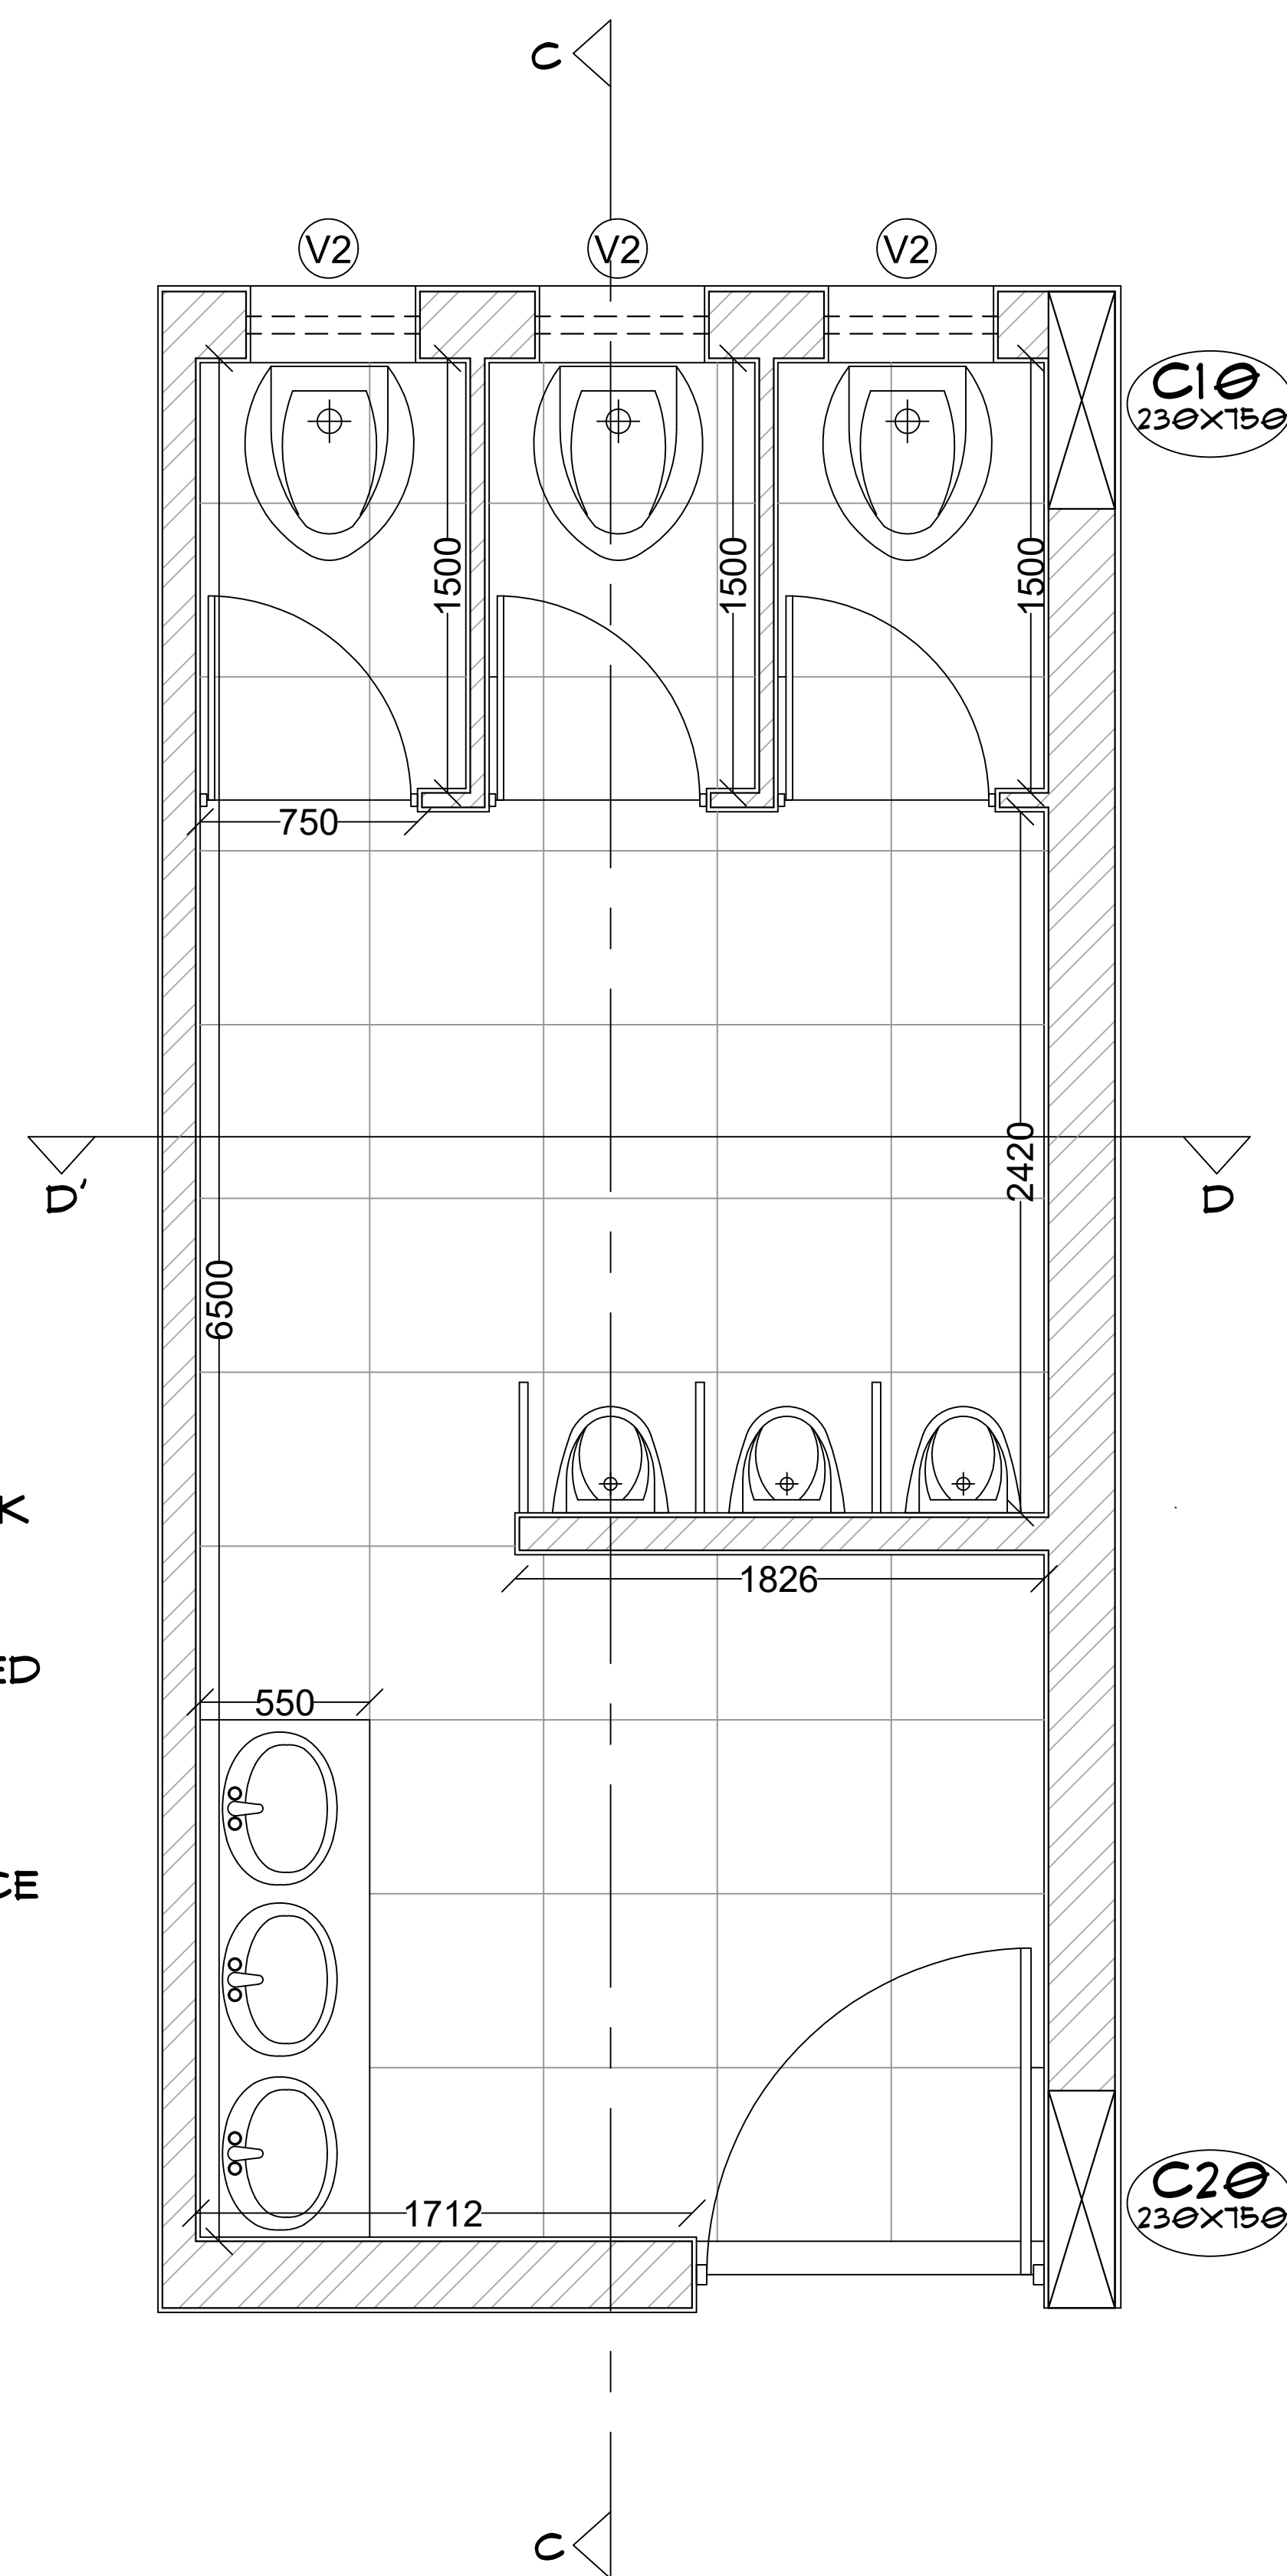

FIRST FLOOR TOILET DETAIL  
SCALE - 1:20

PROFORMA -  
WORKING DRAWING - II  
SHEET TITLE -

## TOILET DETAIL

### NOTES -


- 1) ALL DIMENSIONS ARE IN MM UNTIL SPECIFIED.
- 2) DO NOT MEASURE DRAWING, FOLLOW WRITTEN DIMENSIONS ONLY.
- 3) PLEASE REFER TO THE ARCHITECT IN CONCERN TO ANY QUERY OR DRAWING.
- 4) THIS DRAWING IS A PROPERTY OF THE ARCHITECT AND SHALL NOT BE REPRODUCED OR USED WITHOUT THEIR WRITTEN PERMISSION.

SCALE - DATE - REV NO. -

1 : 20 10/10/2024

DRAWN BY - CHECKED BY -

VK AR NS

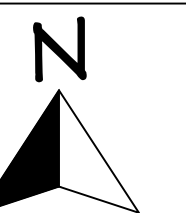


### PROJECT -

## PROPOSED SHOPPING COMPLEX AT SOLAPUR


### ARCHITECT -

VAISHNAVI G. KARBHARI.  
ROLL NO. - 99M/21/08  
4TH YR, SEM VII (B.ARCH)  
99M'S COLLEGE OF  
ARCHITECTURE, SOLAPUR.


### SIGN AND STAMP -

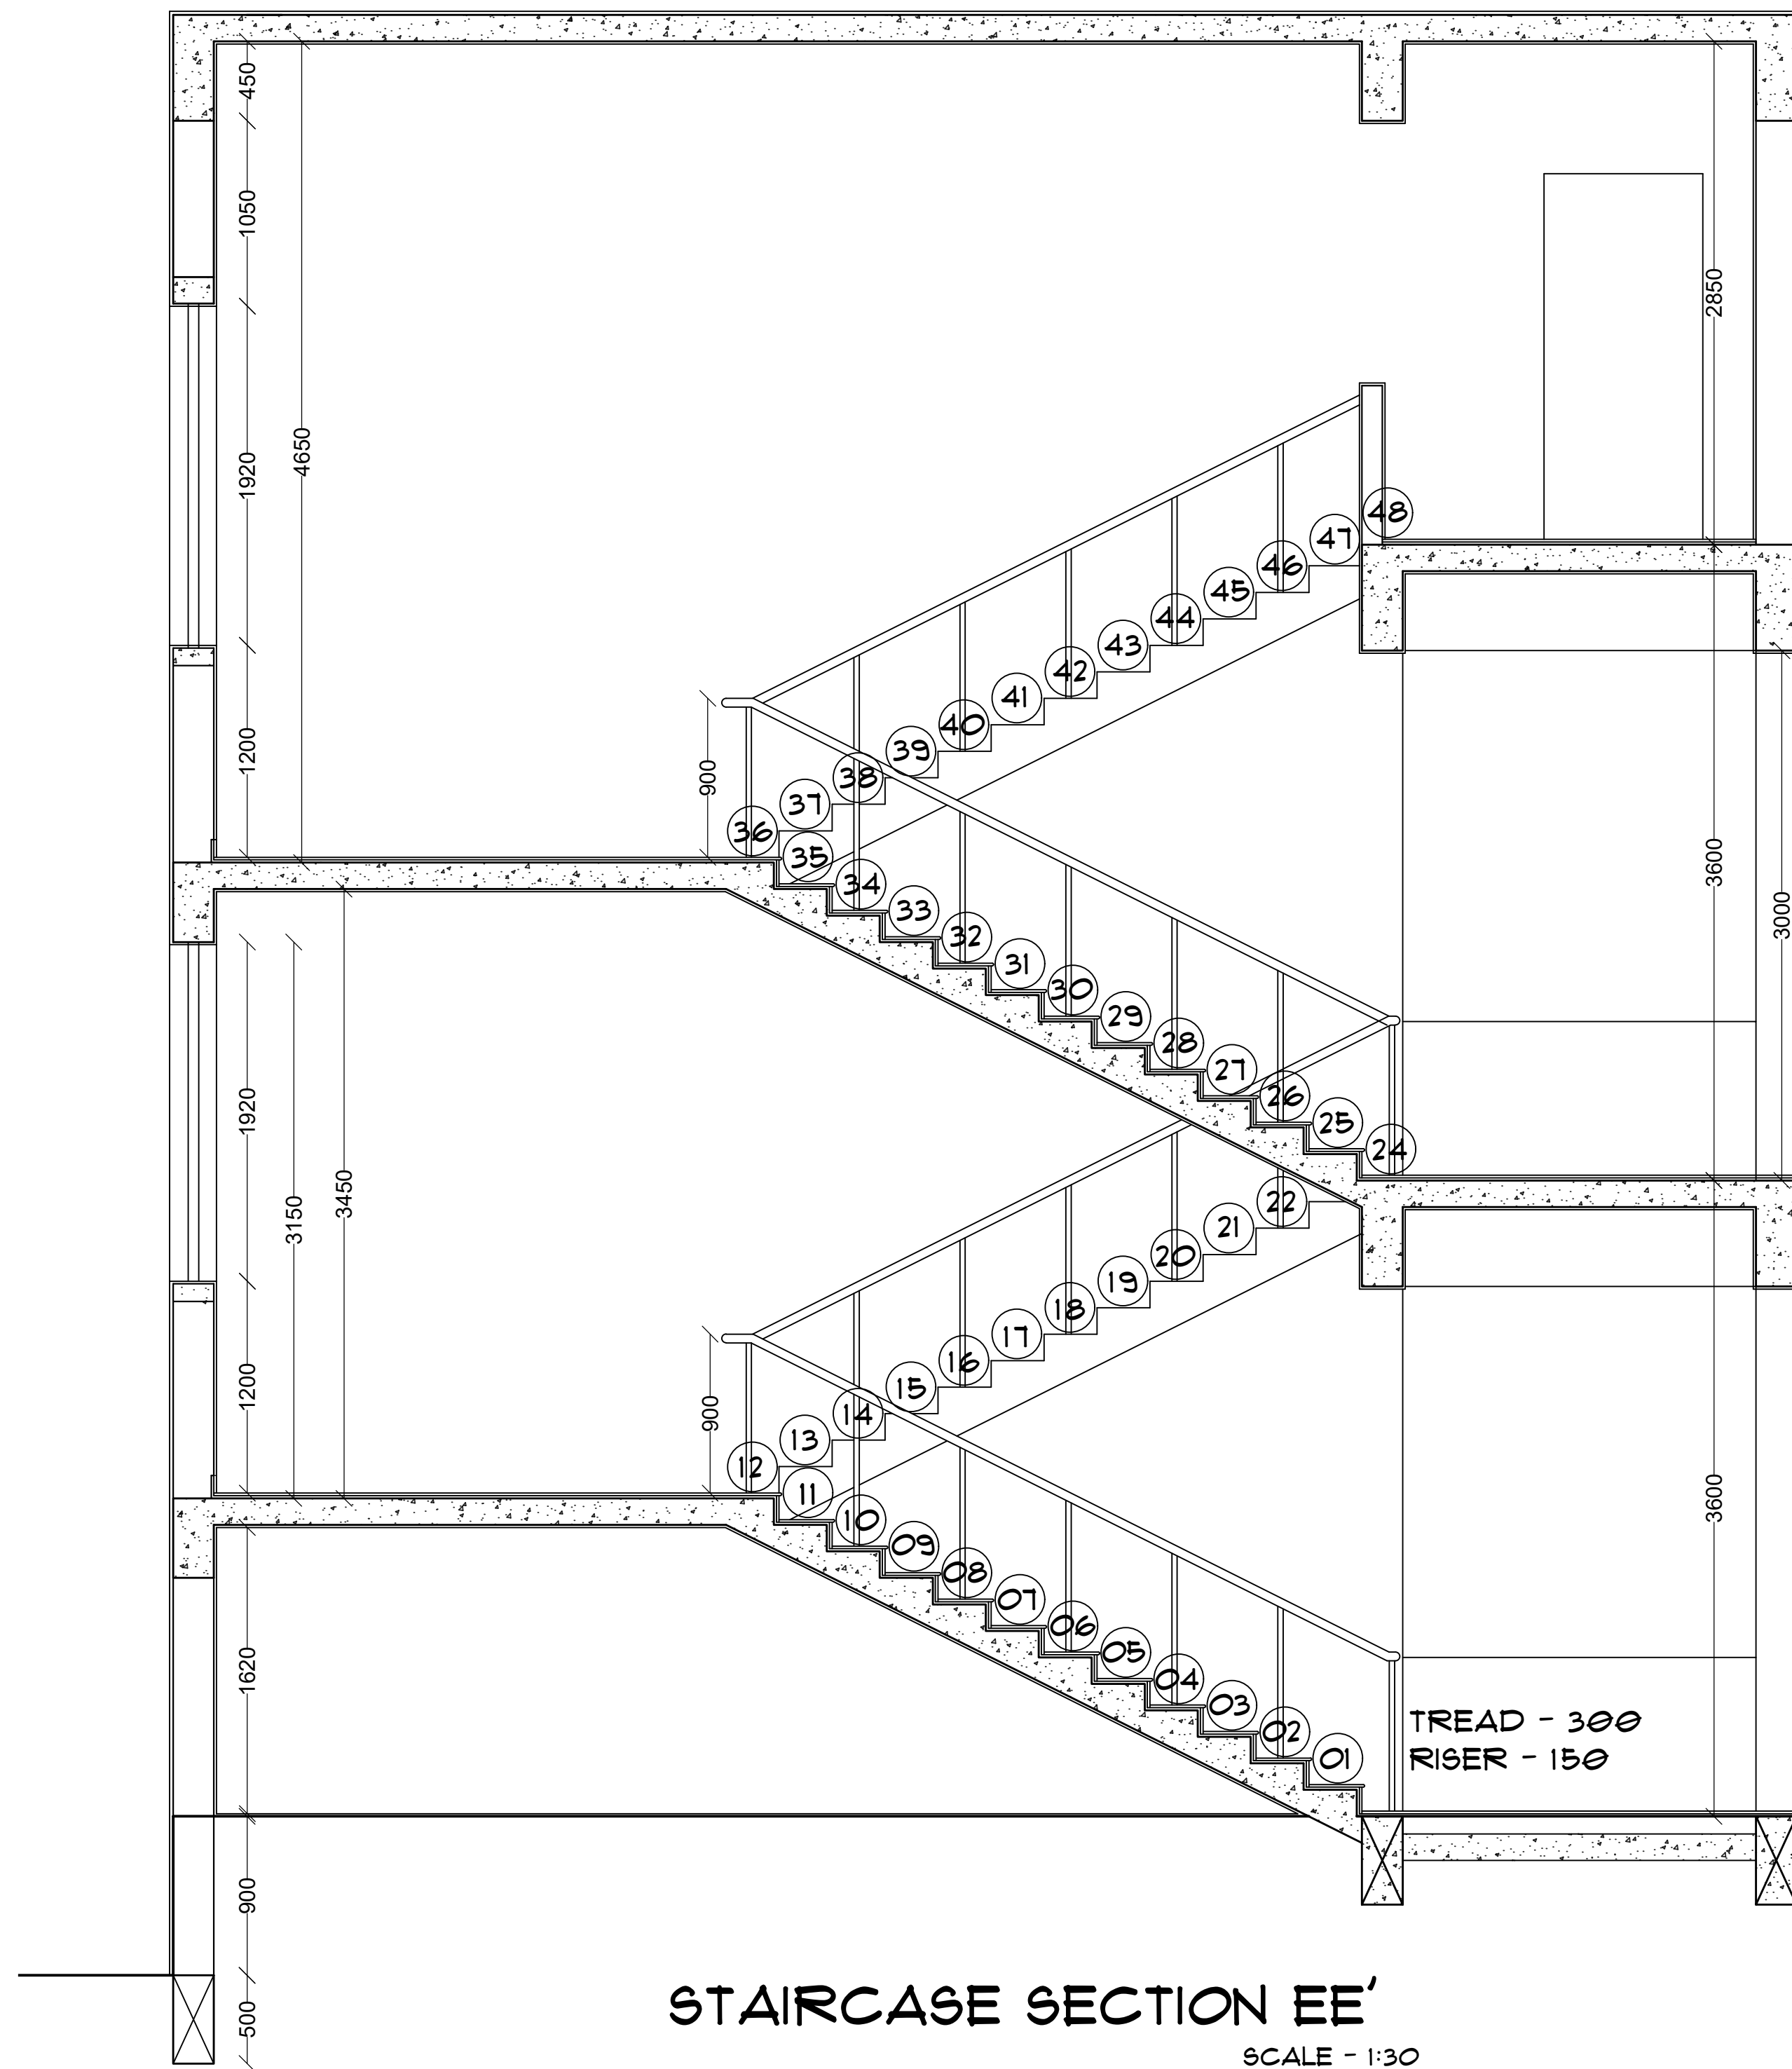


STAIRCASE SECTION EE'  
SCALE - 1:30

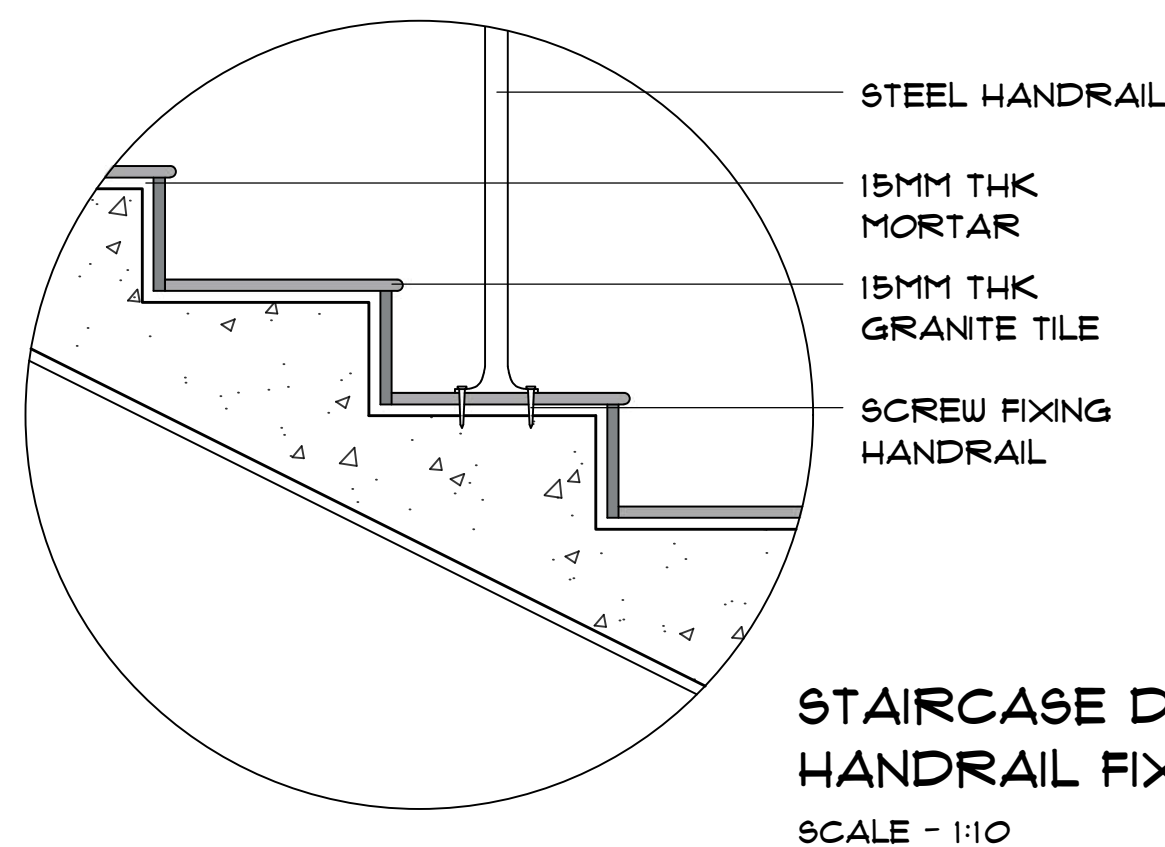

STAIRCASE DETAIL WITH  
HANDRAIL FIXING  
SCALE - 1:10

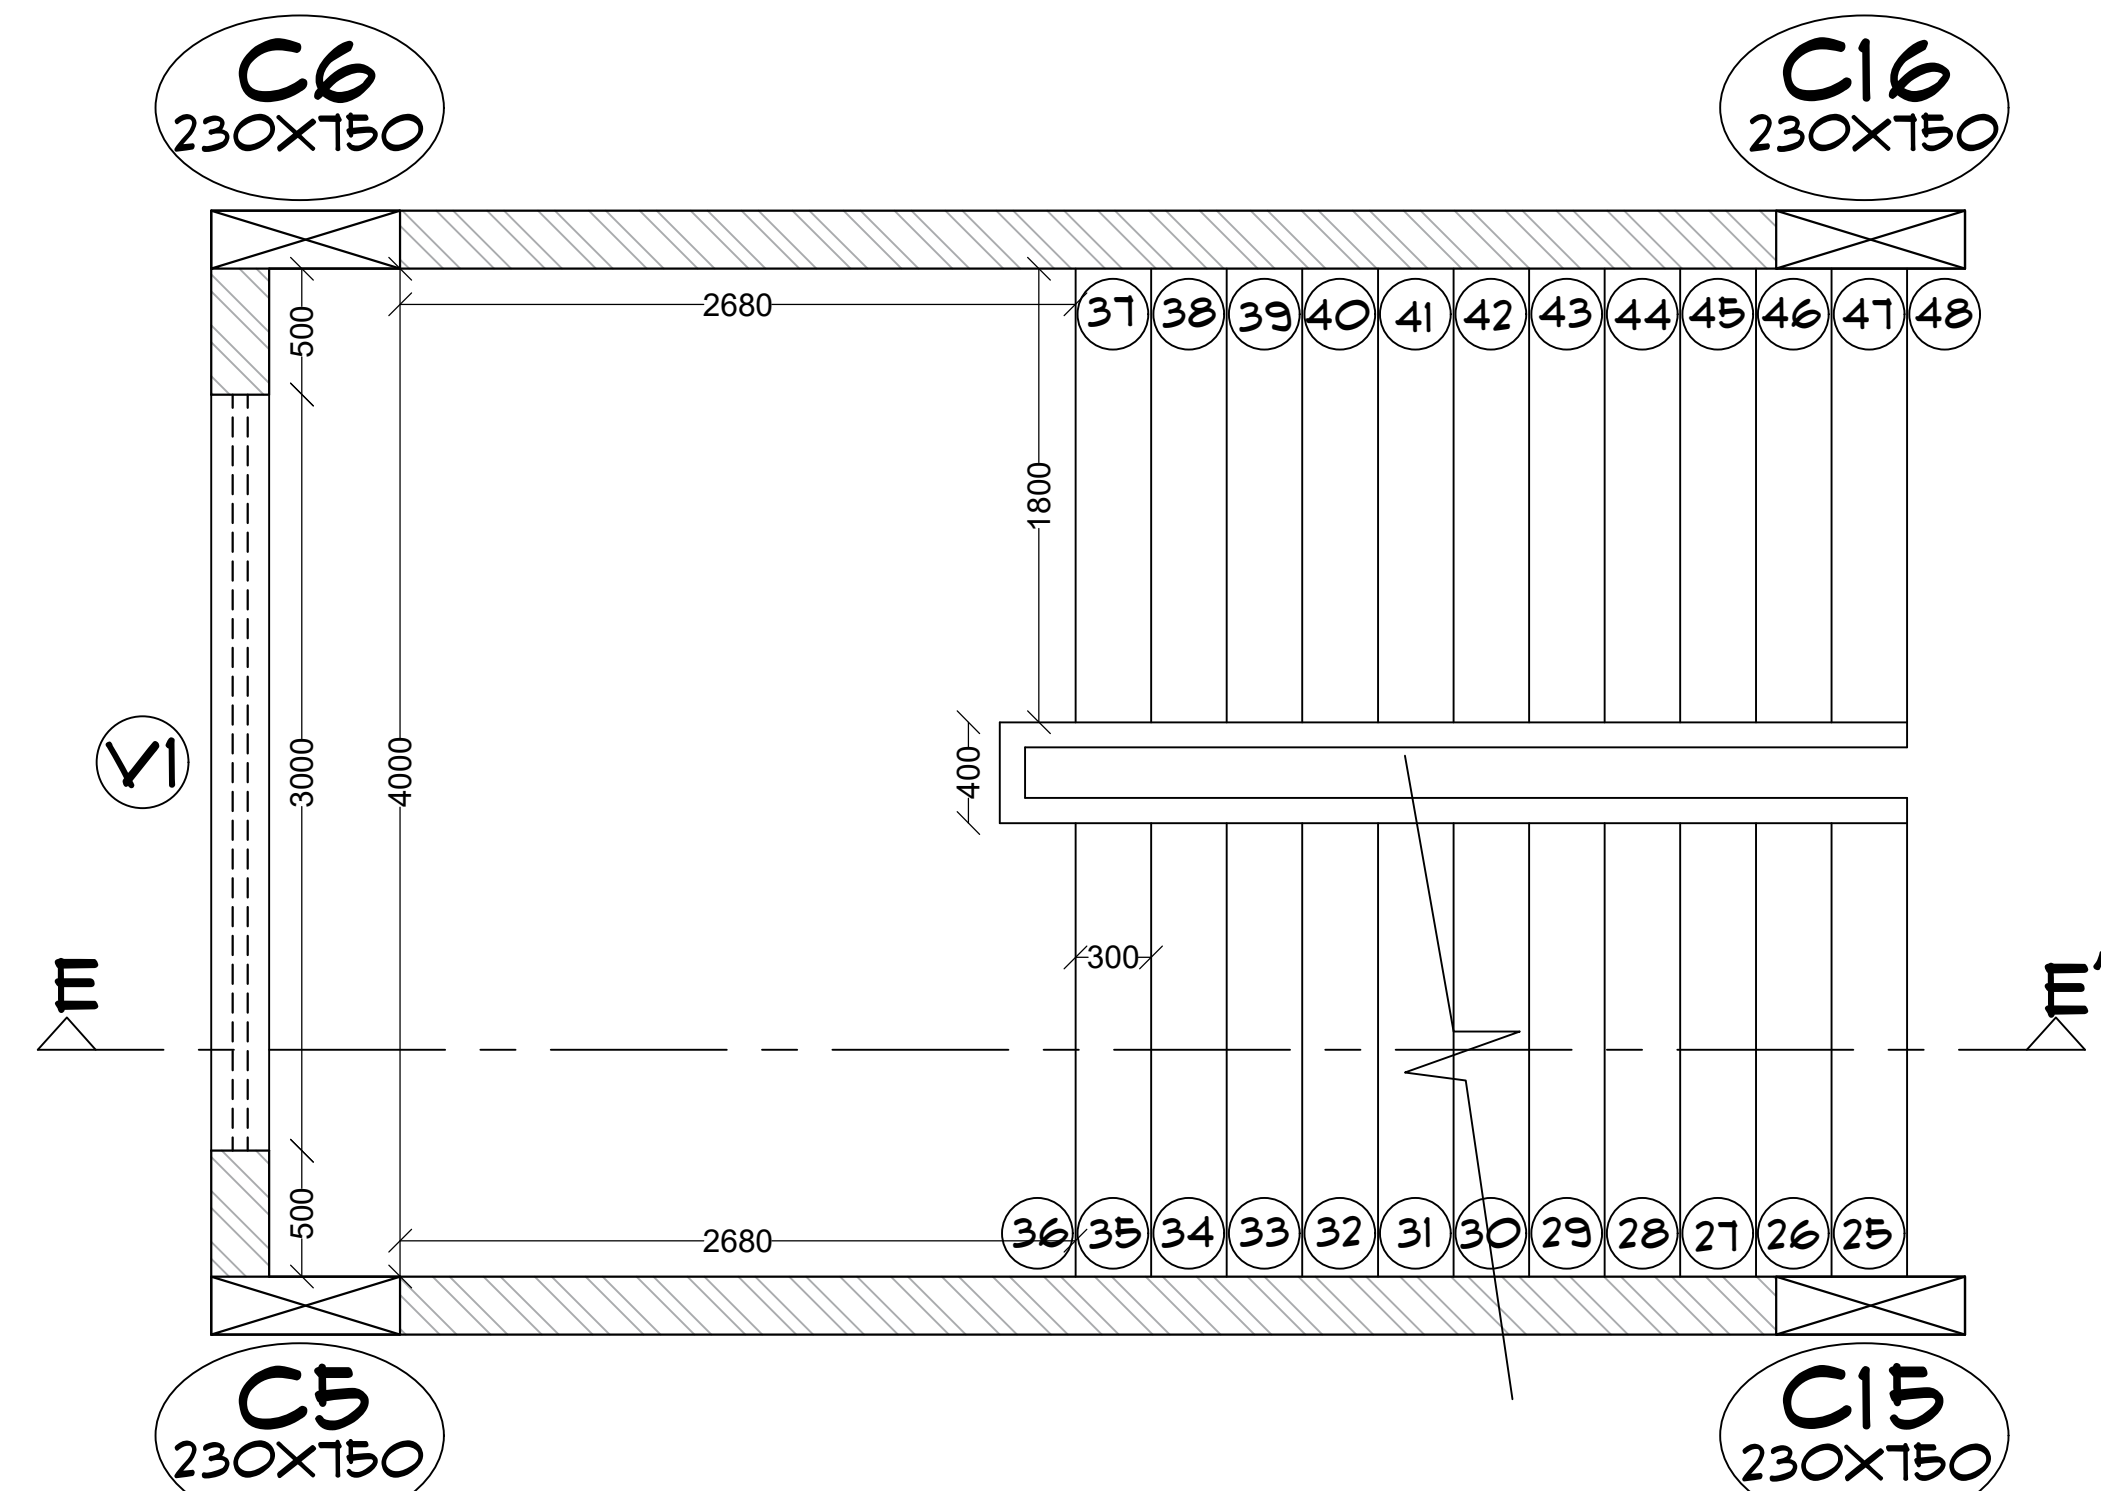

FIRST FLOOR STAIRCASE DETAIL  
PLAN  
SCALE - 1:30

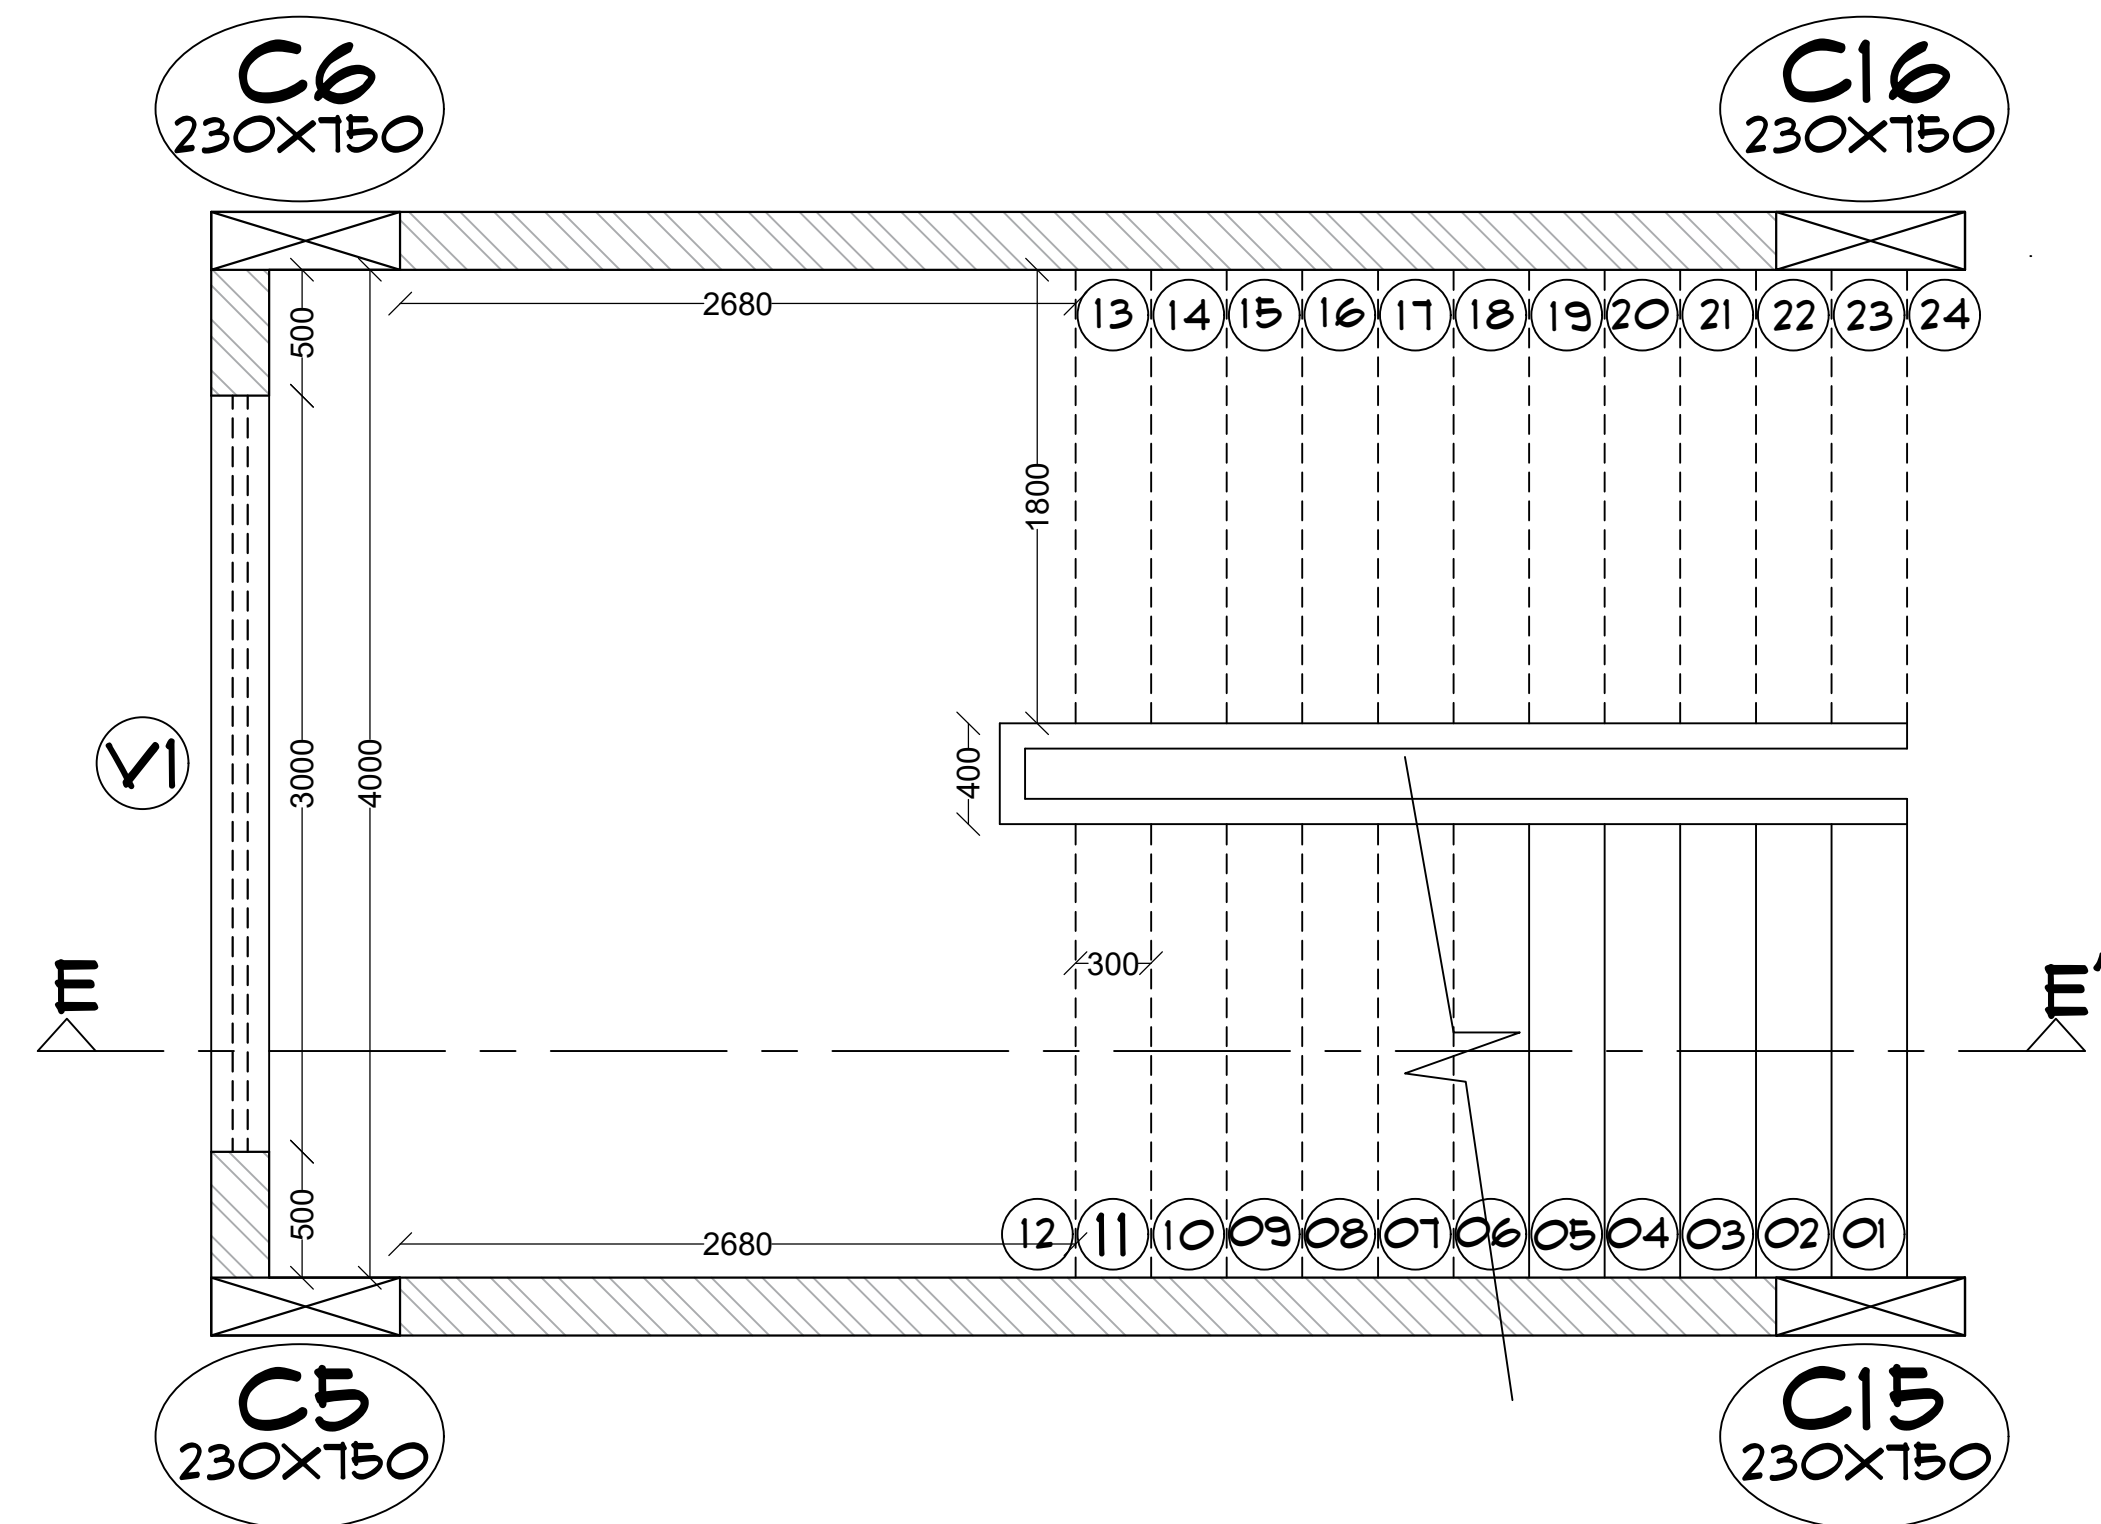

GROUND FLOOR STAIRCASE DETAIL  
PLAN  
SCALE - 1:30

PROFORMA -  
WORKING DRAWING - II  
SHEET TITLE -

STAIRCASE DETAIL

NOTES -  
1) ALL DIMENSIONS ARE IN MM UNTIL SPECIFIED.  
2) DO NOT MEASURE DRAWING, FOLLOW WRITTEN DIMENSIONS ONLY.  
3) PLEASE REFER TO THE ARCHITECT IN CONCERN TO ANY QUERY OR DRAWING.  
4) THIS DRAWING IS A PROPERTY OF THE ARCHITECT AND SHALL NOT BE REPRODUCED OR USED WITHOUT THEIR WRITTEN PERMISSION.

| SCALE -    | DATE -       | REV NO. - |
|------------|--------------|-----------|
| 1 : 30     | 05/11/2024   |           |
| DRAWN BY - | CHECKED BY - |           |
| VK         | AR NS        |           |

PROJECT -

PROPOSED  
SHOPPING COMPLEX  
AT SOLAPUR

ARCHITECT -

VAISHNAVI G. KARBHARI.  
ROLL NO. - 99M/21/08  
4TH YR, SEM VII (B.ARCH)  
99M'S COLLEGE OF  
ARCHITECTURE, SOLAPUR.

SIGN AND STAMP -

PROFORMA -

WORKING DRAWING - II

SHEET TITLE -

FLOORING LAYOUT

NOTES -

- 1) ALL DIMENSIONS ARE IN MM UNTIL SPECIFIED.
- 2) DO NOT MEASURE DRAWING, FOLLOW WRITTEN DIMENSIONS ONLY.
- 3) PLEASE REFER TO THE ARCHITECT IN CONCERN TO ANY QUERY OR DRAWING.
- 4) THIS DRAWING IS A PROPERTY OF THE ARCHITECT AND SHALL NOT BE REPRODUCED OR USED WITHOUT THEIR WRITTEN PERMISSION.

SCALE -

DATE -

REV NO. -

1 : 100


05/11/2024

DRAWN BY -

CHECKED BY -

YK

AR NS

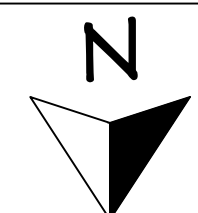


PROJECT -

PROPOSED  
SHOPPING COMPLEX  
AT SOLAPUR

ARCHITECT -



VAISHNAVI G. KARBHARI.  
ROLL NO. - 55M/21/08  
4TH YR, SEM VII (B.ARCH)  
55M'S COLLEGE OF  
ARCHITECTURE, SOLAPUR.

SIGN AND STAMP -

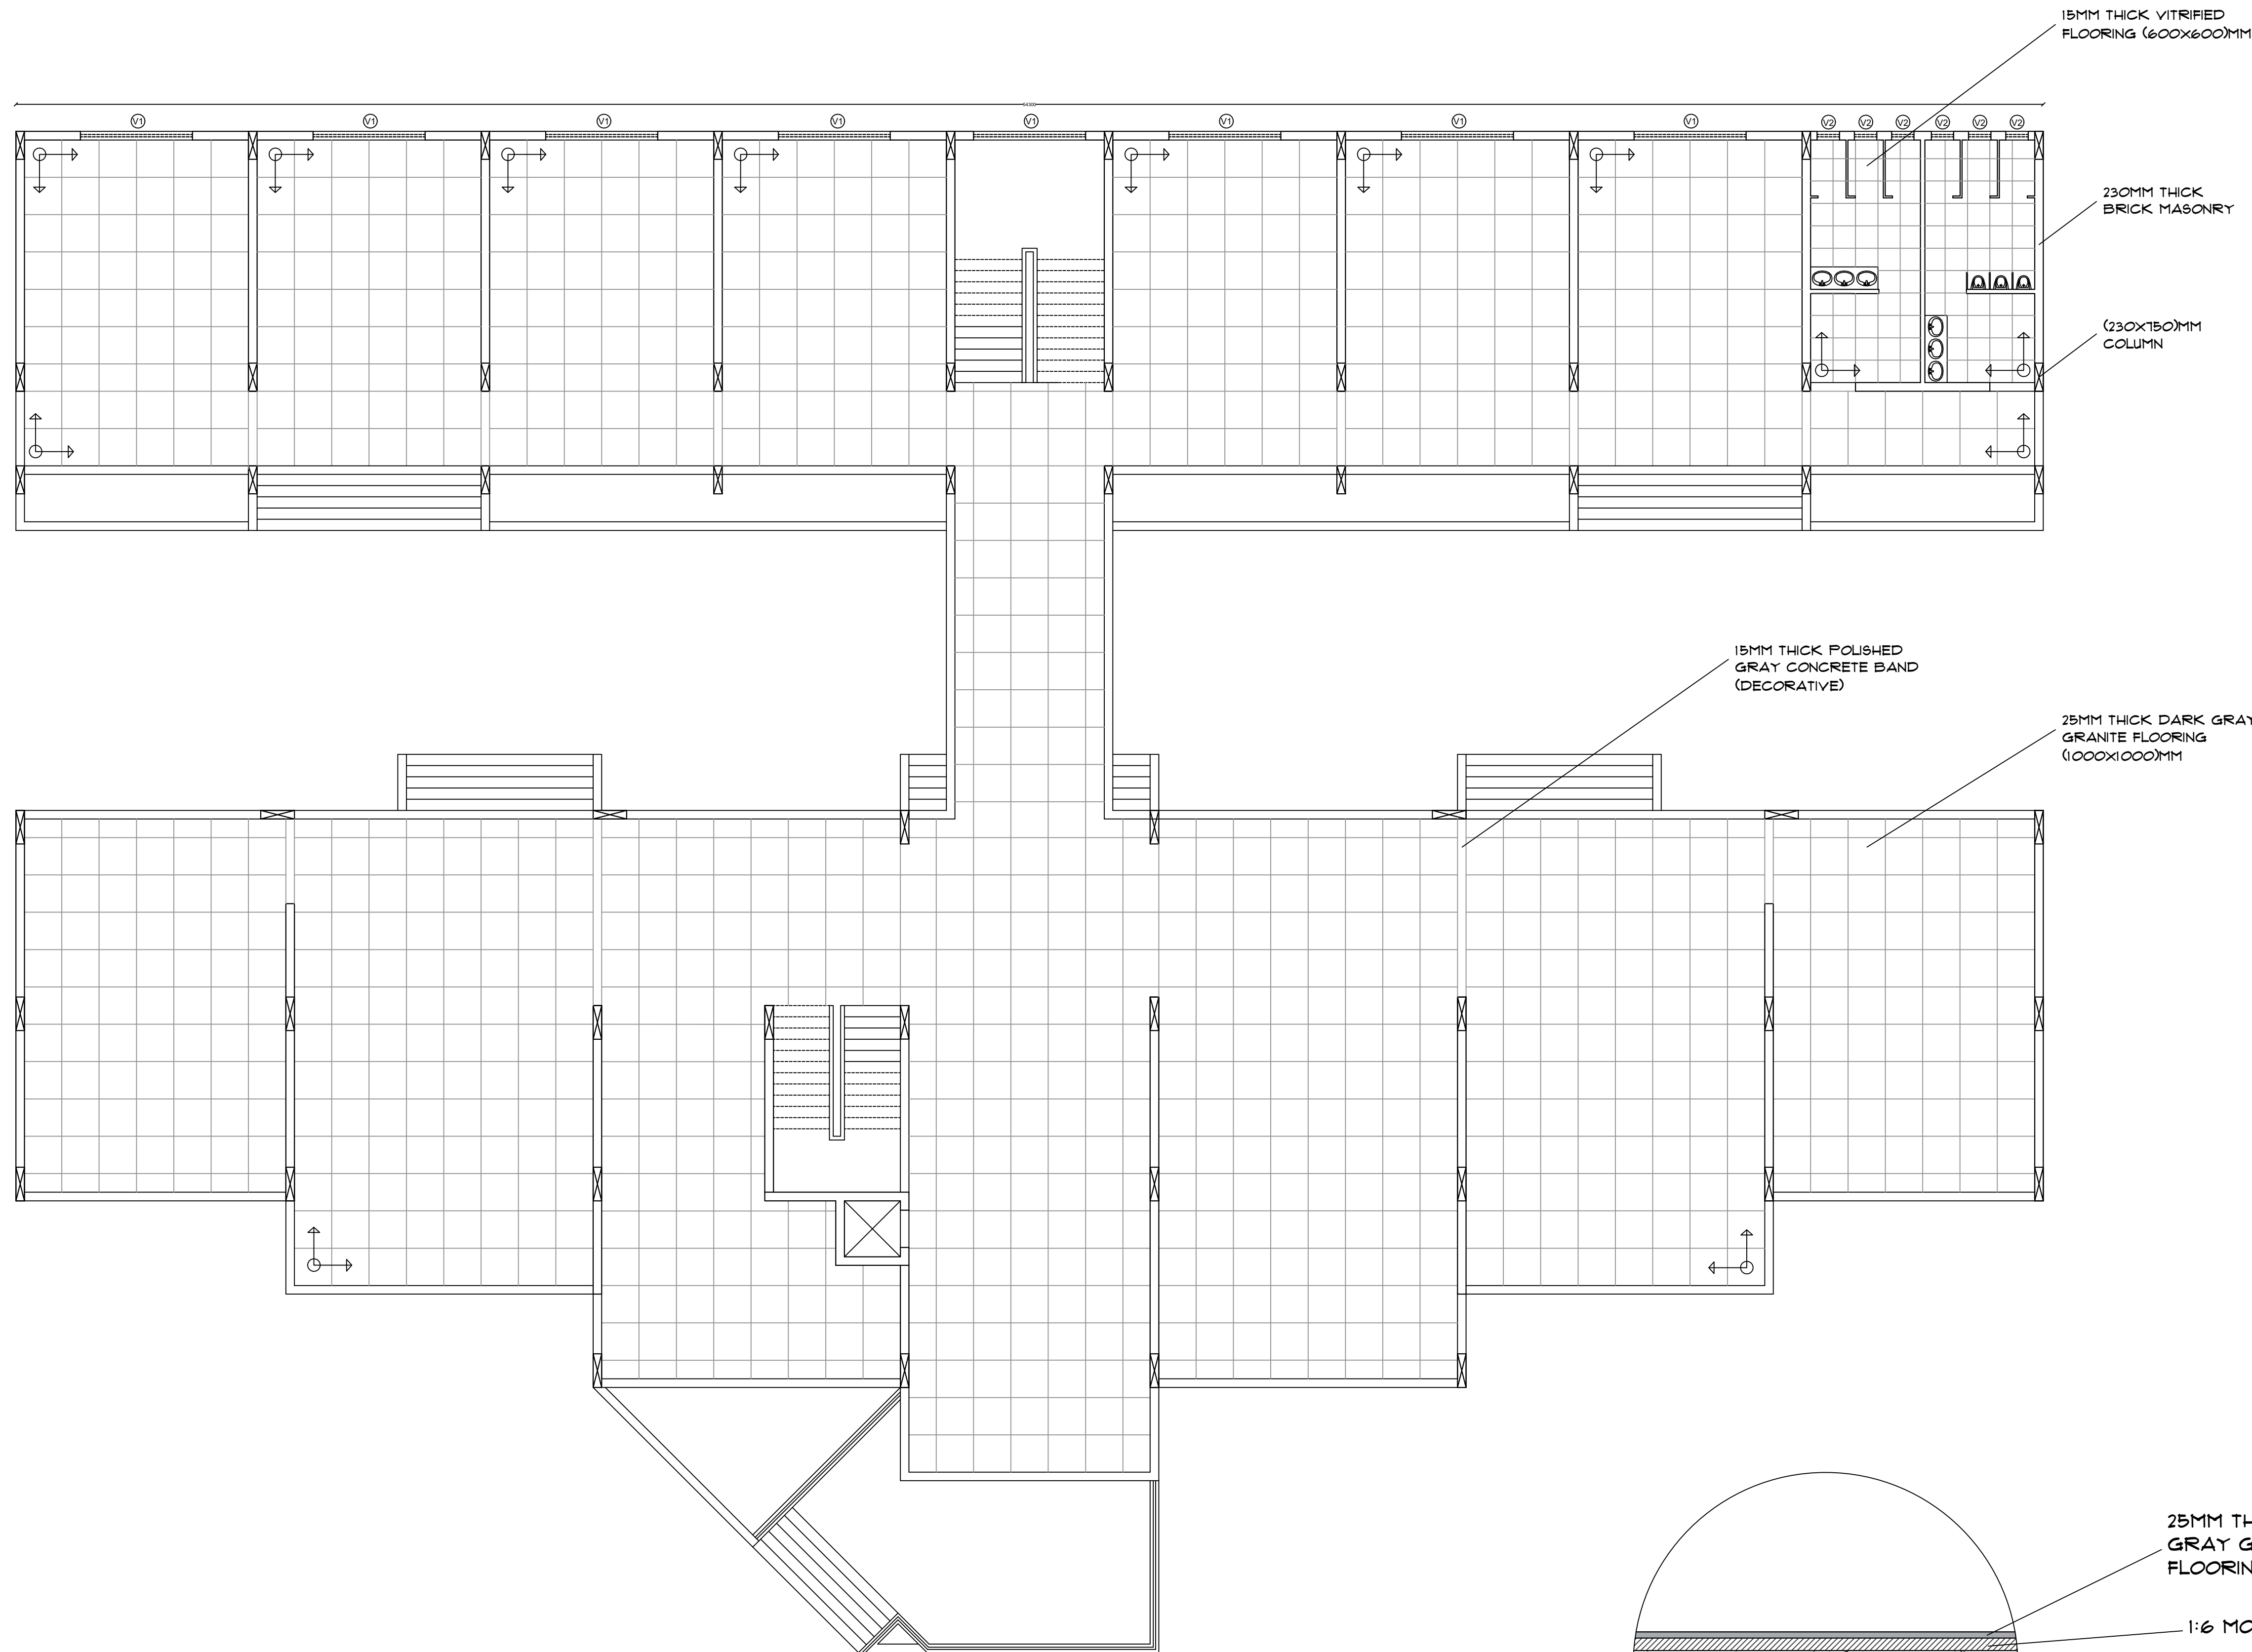


FIRST FLOOR FLOORING LAYOUT

SCALE - 1:100

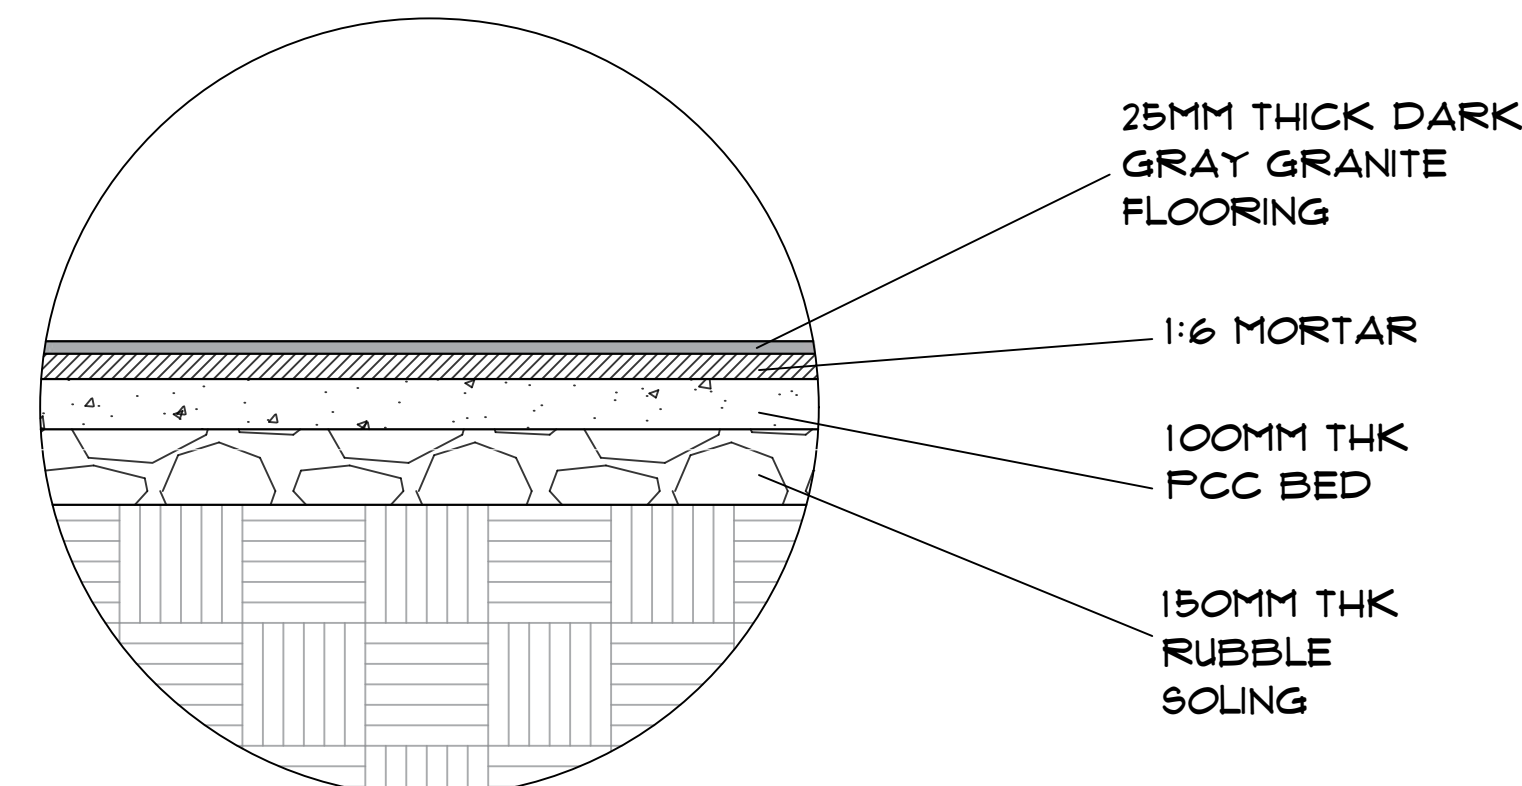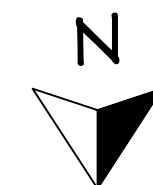


FLOORING DETAIL


SCALE - 1:100

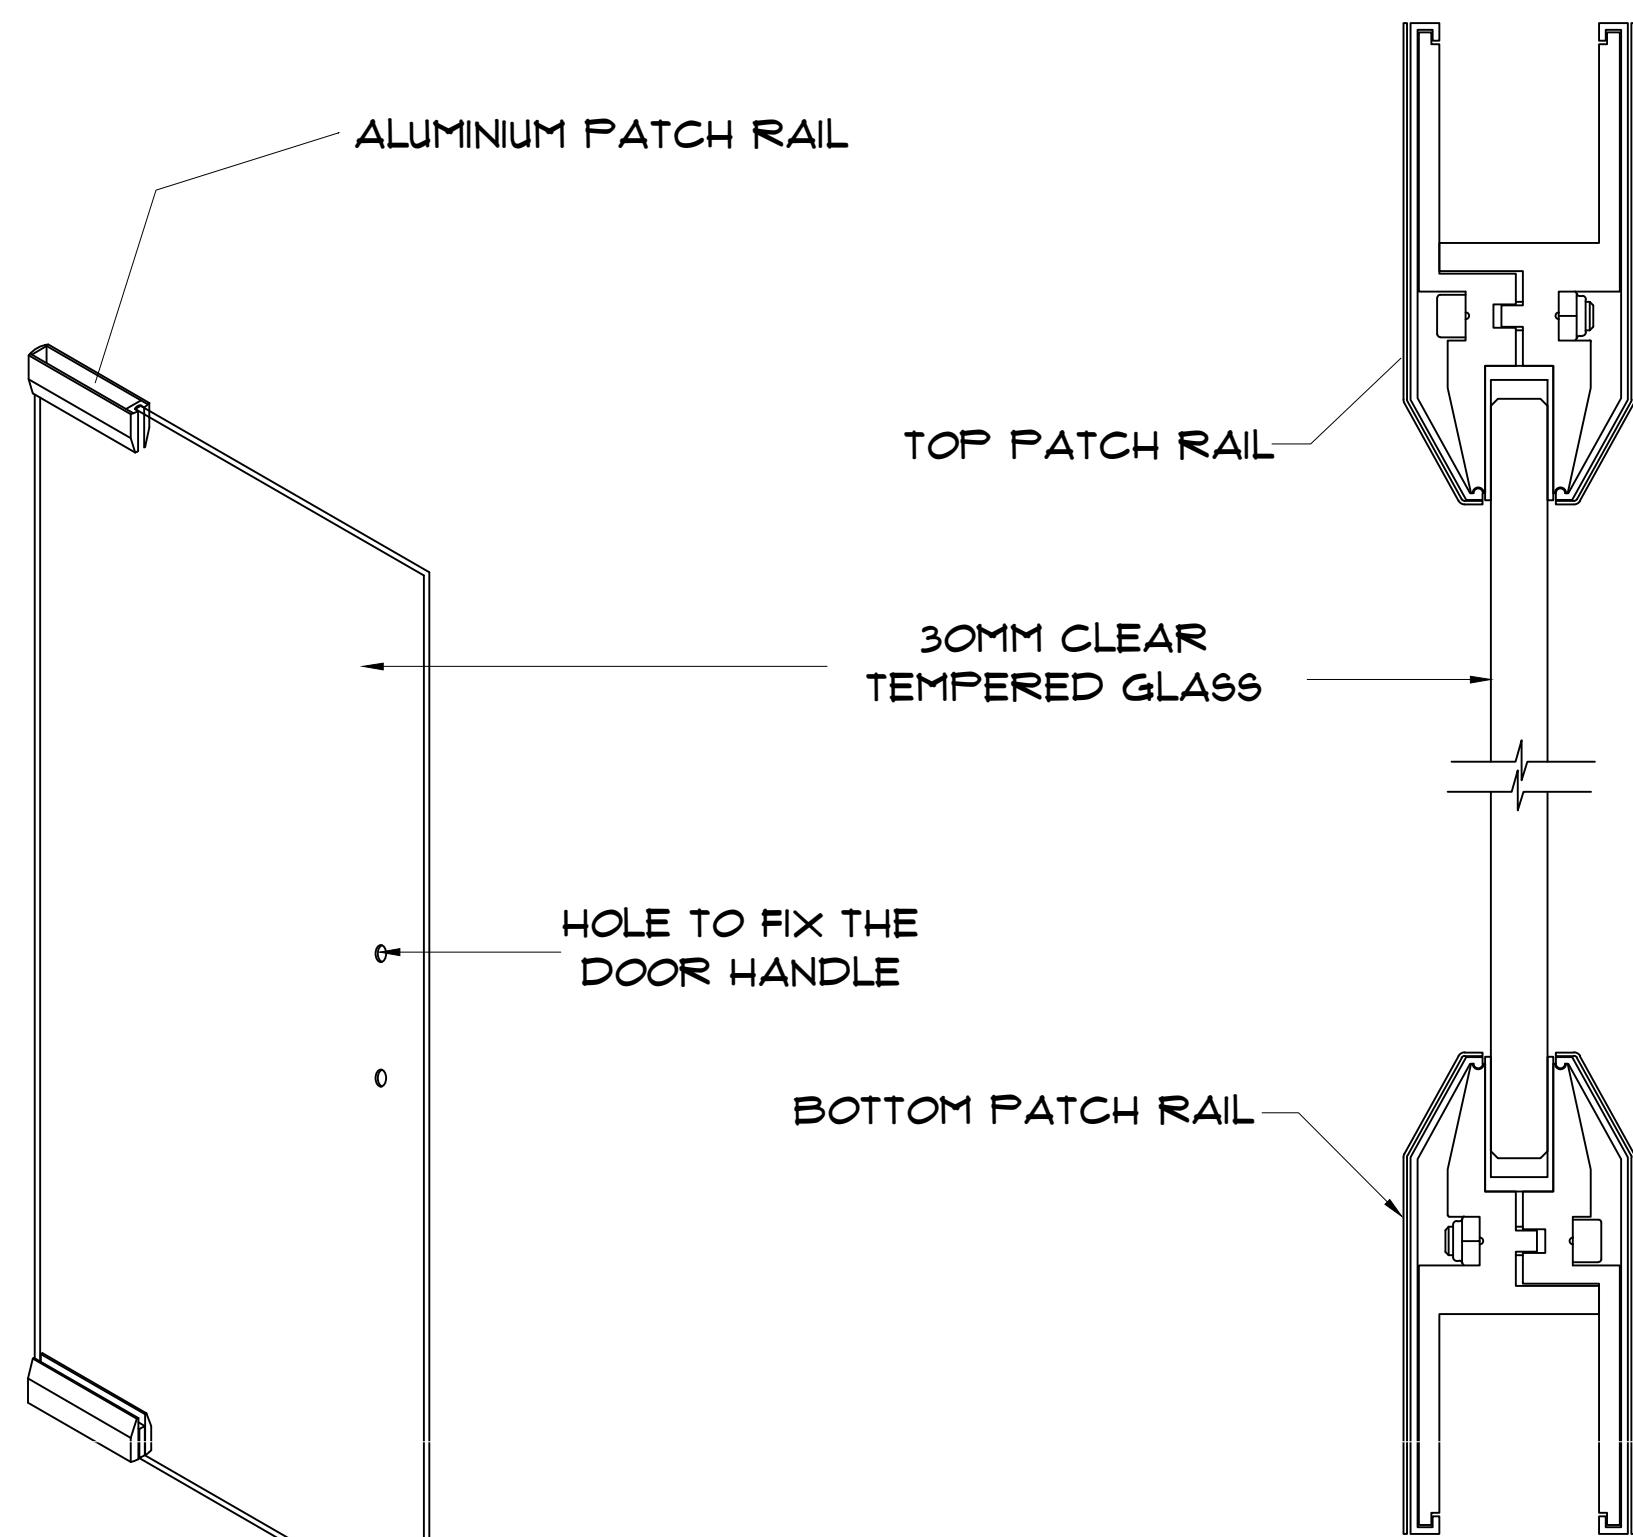


GLASS DOOR WITH  
ALUMINIUM PATCH RAIL  
SCALE - 1:4

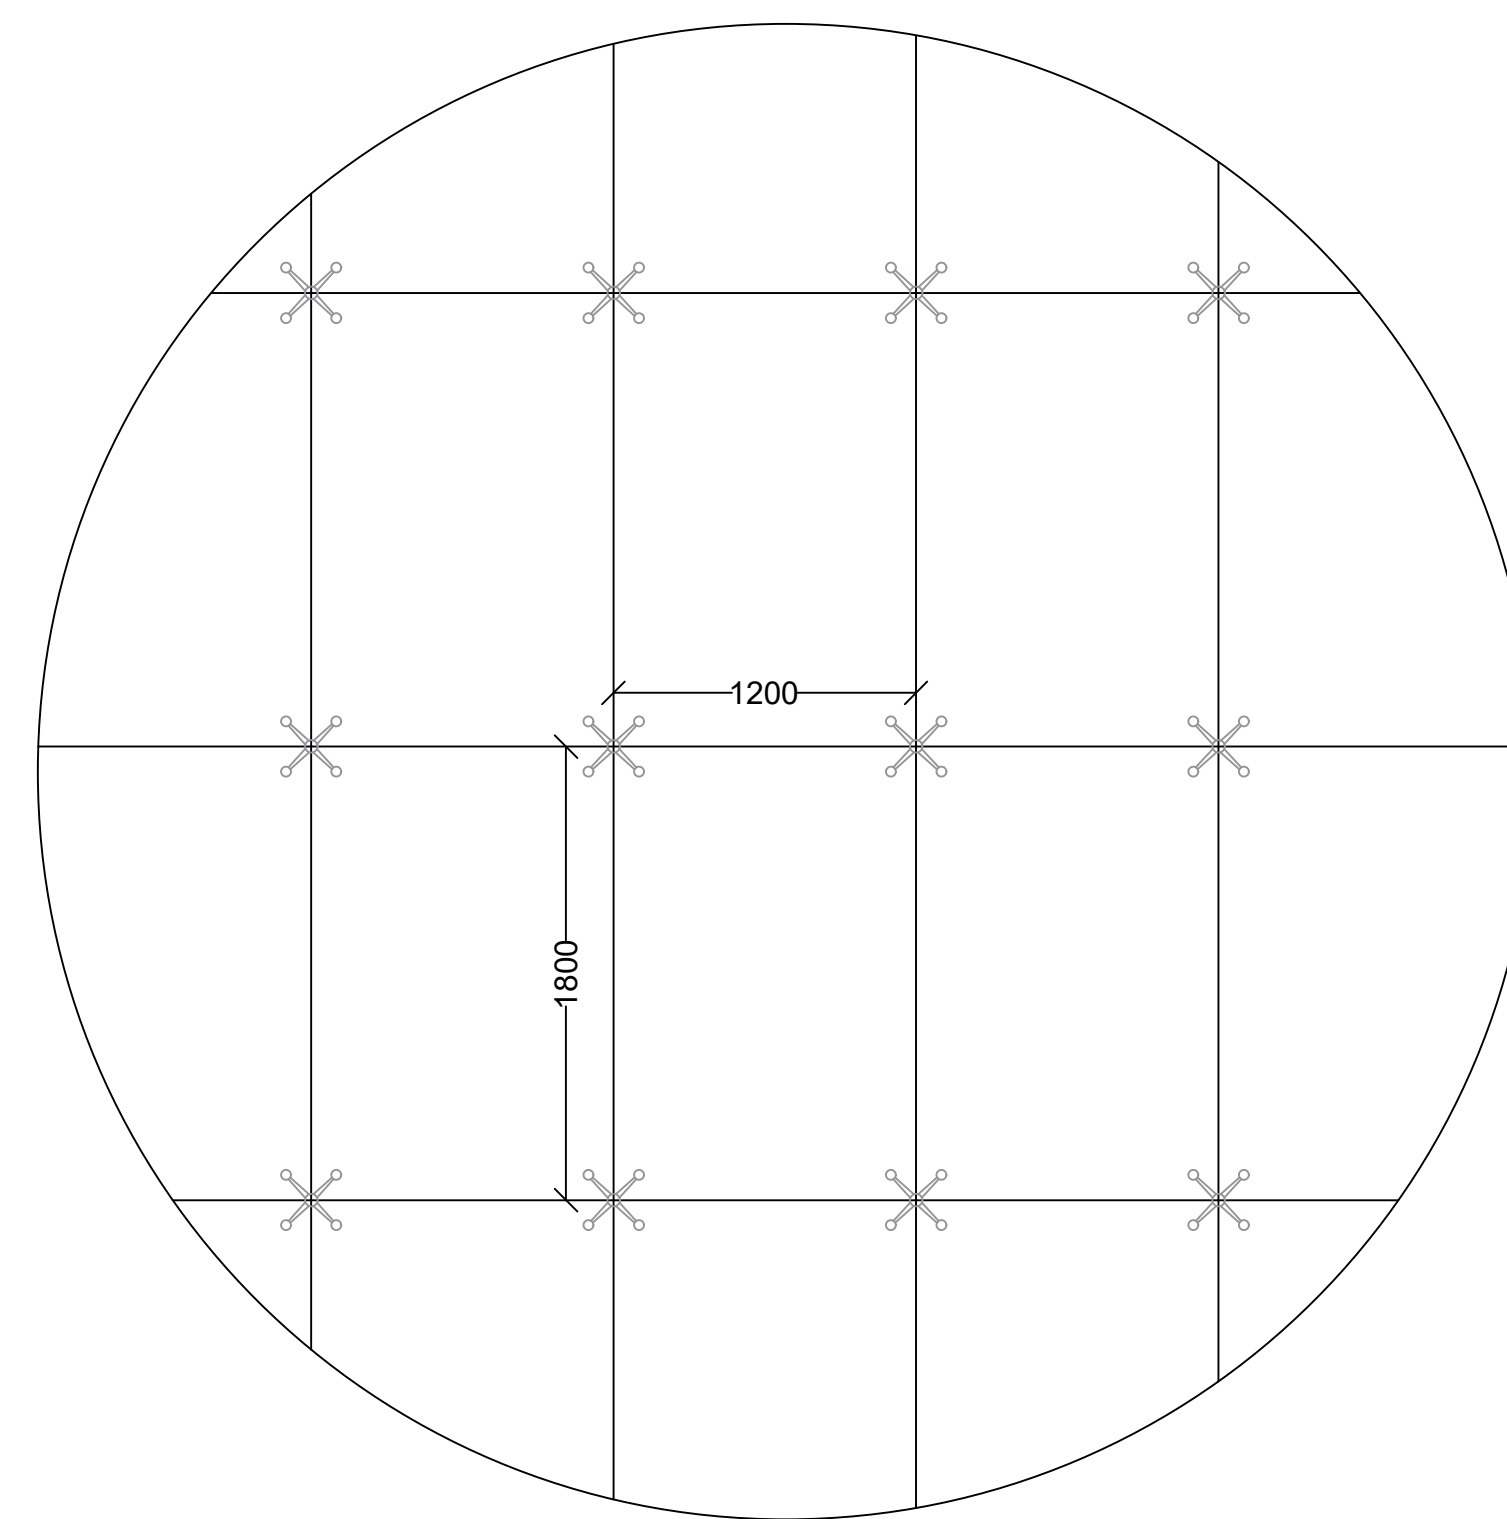


SPIDER FITTING  
CURTAIN WALL  
SCALE - 1:30

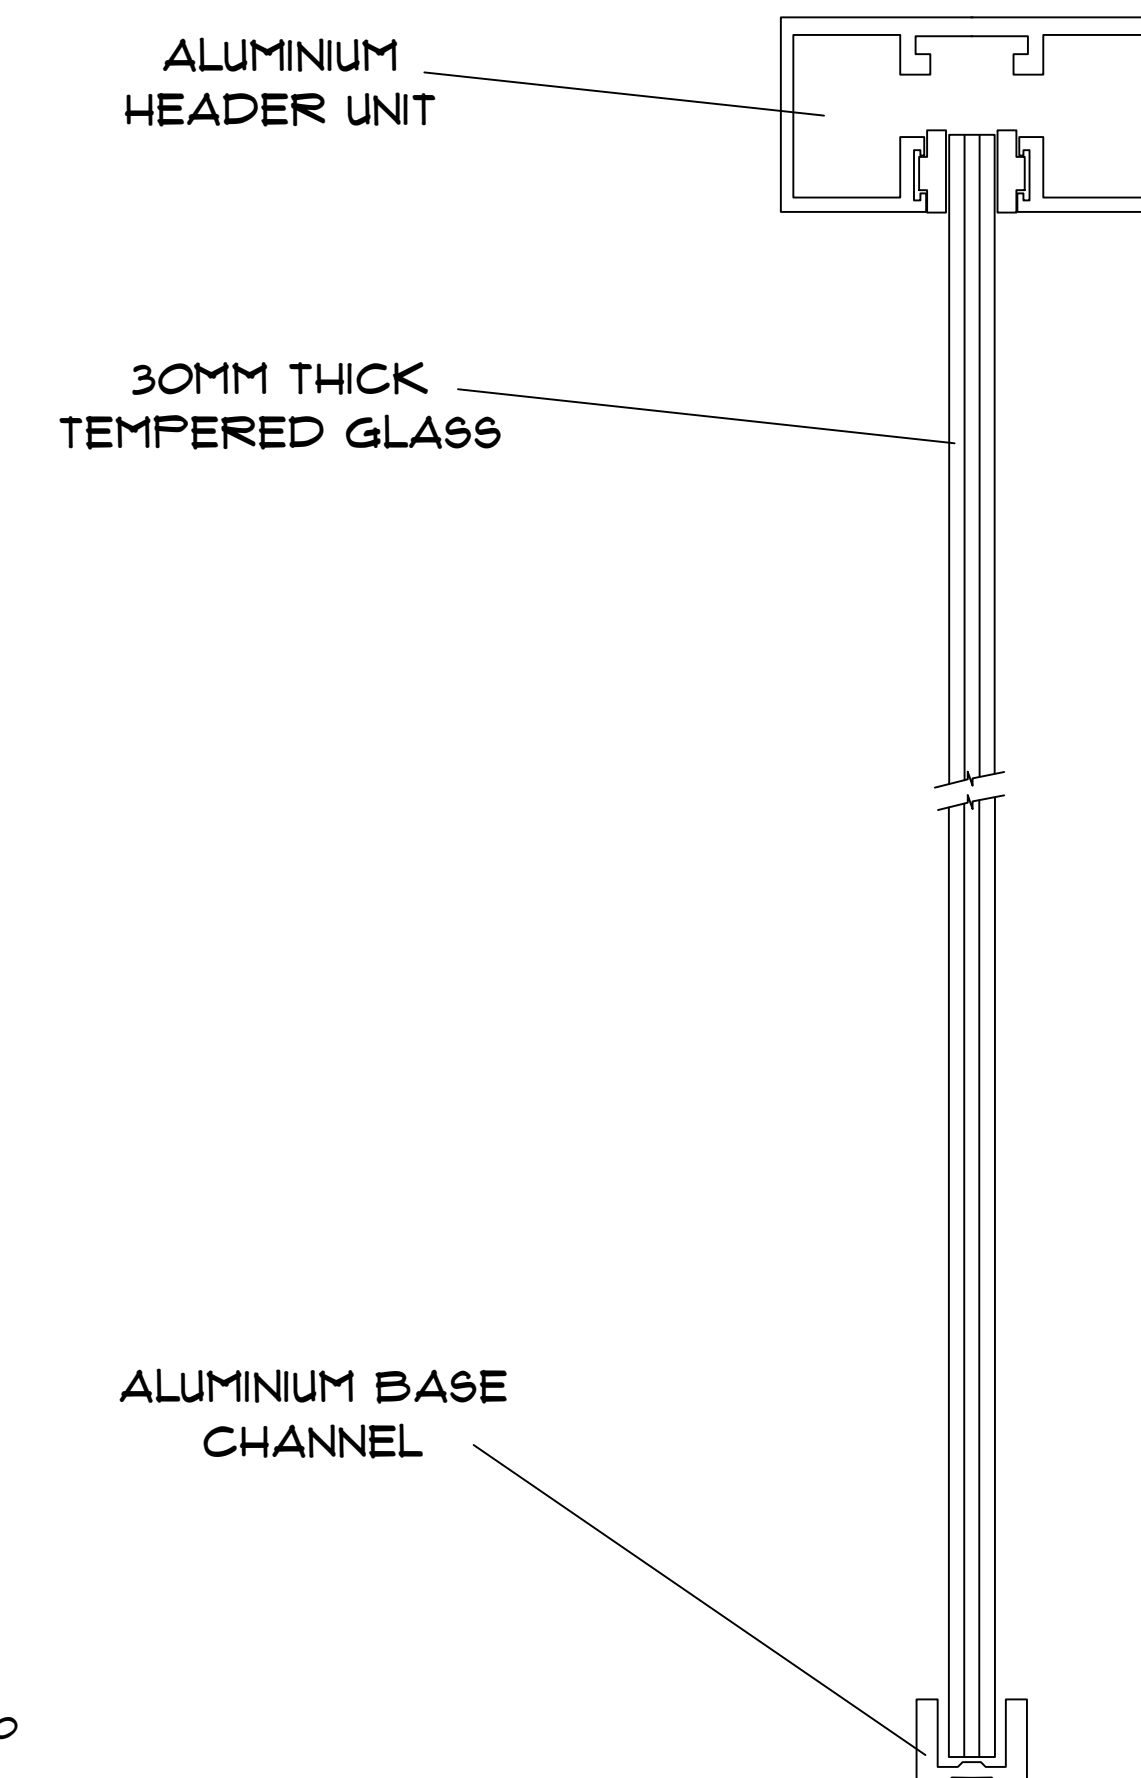


GLASS DOOR WITH  
ALUMINIUM RAIL  
SCALE - 1:5

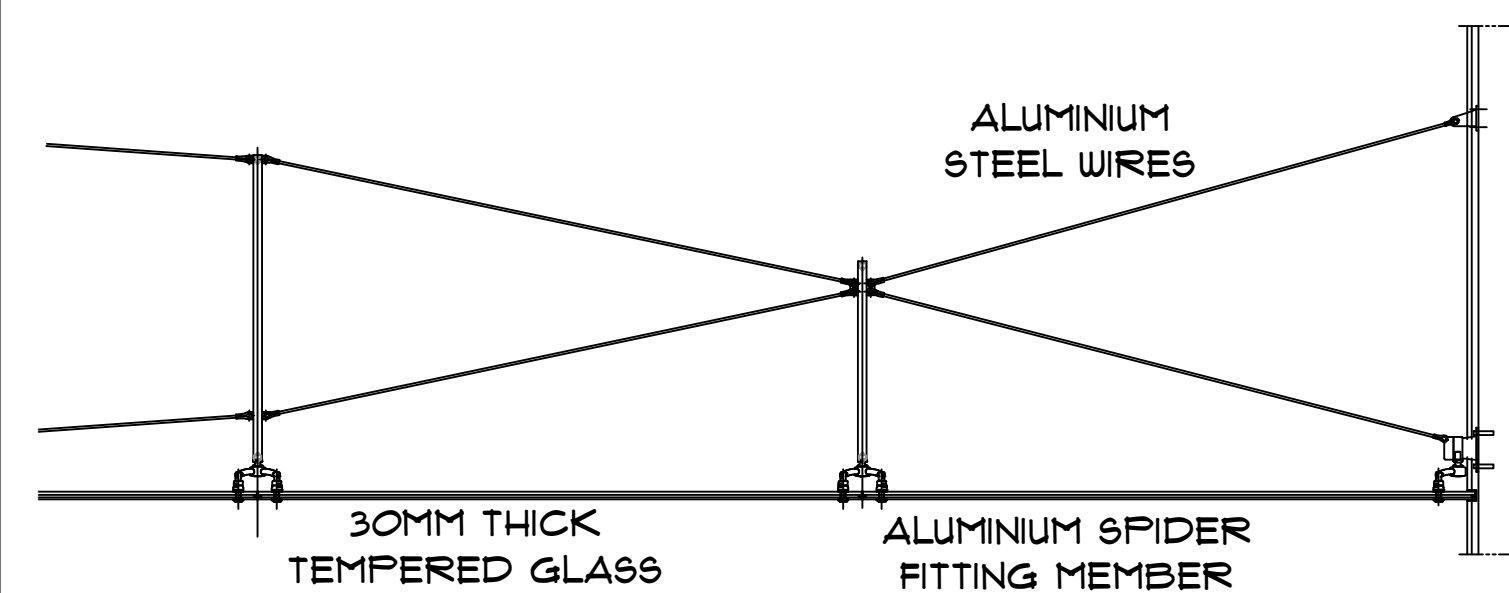

SPIDER FITTING DETAIL IN PLAN  
SCALE - 1:15

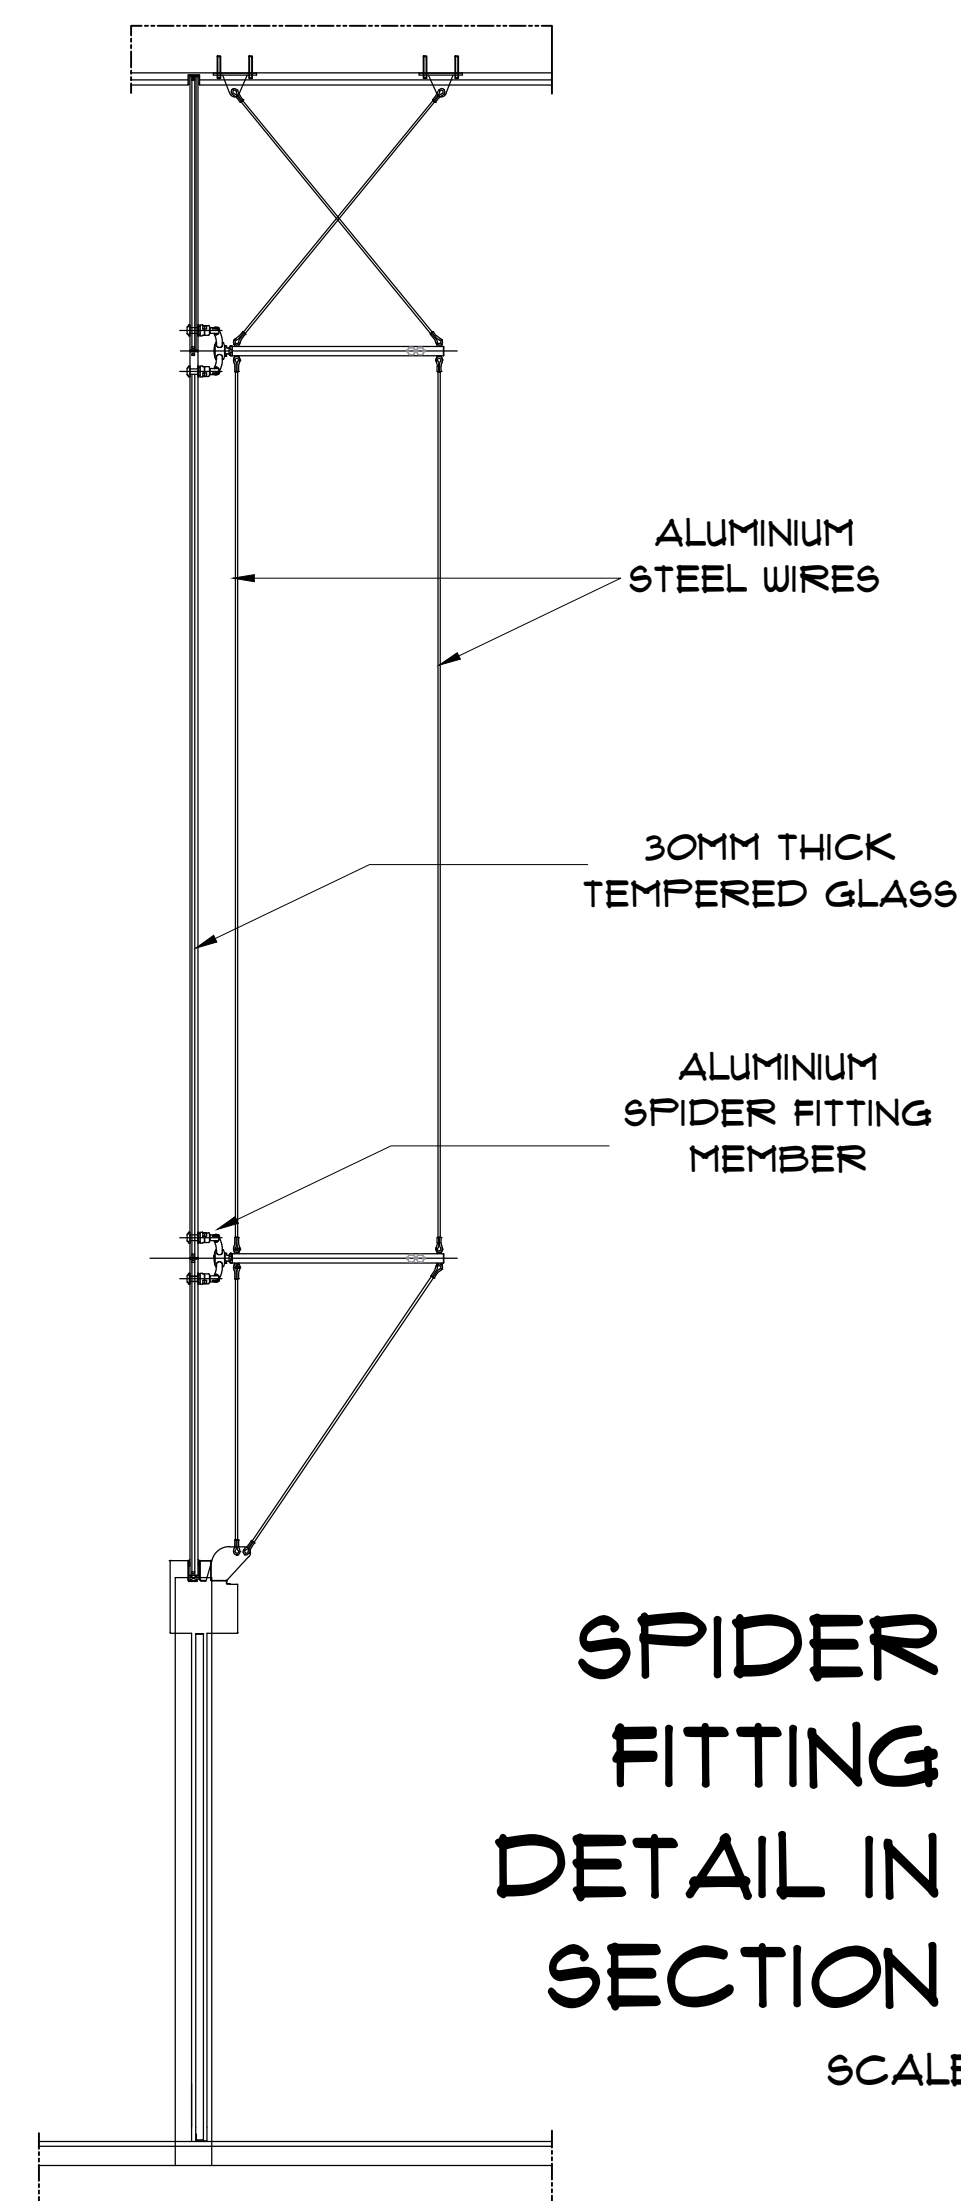

SPIDER  
FITTING  
DETAIL IN  
SECTION  
SCALE - 1:15

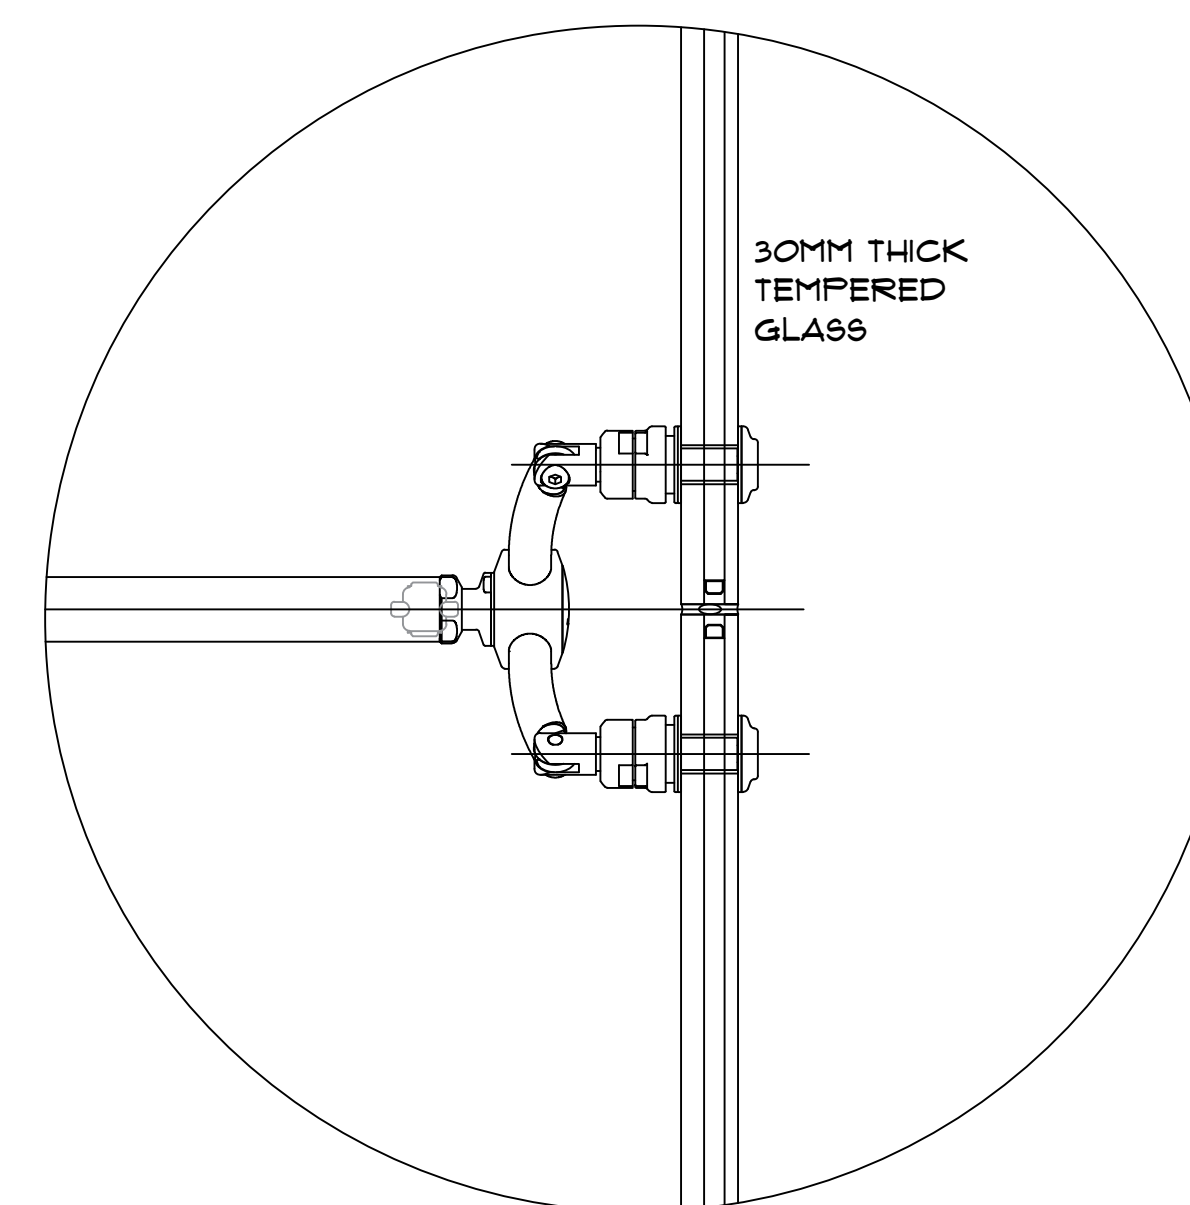

4-WAY FIXING SPIDER  
FITTING DETAIL  
SCALE - 1:2

PROFORMA -  
WORKING DRAWING - II  
SHEET TITLE -  
**CURTAIN WALL AND  
GLASS DOOR DETAIL**

- NOTES -
- 1) ALL DIMENSIONS ARE IN MM UNTIL SPECIFIED.
  - 2) DO NOT MEASURE DRAWING, FOLLOW WRITTEN DIMENSIONS ONLY.
  - 3) PLEASE REFER TO THE ARCHITECT IN CONCERN TO ANY QUERY OR DRAWING.
  - 4) THIS DRAWING IS A PROPERTY OF THE ARCHITECT AND SHALL NOT BE REPRODUCED OR USED WITHOUT THEIR WRITTEN PERMISSION.

| SCALE -          | DATE -                | REV NO. - |
|------------------|-----------------------|-----------|
| 1:100            | 10/10/2024            |           |
| DRAWN BY -<br>VK | CHECKED BY -<br>AR NS |           |
|                  |                       |           |

PROJECT -  
**PROPOSED  
SHOPPING COMPLEX  
AT SOLAPUR**

ARCHITECT -  
VAISHNAVI G. KARBHARI.  
ROLL NO. - 55M/21/08  
4TH YR, SEM VII (B.ARCH)  
55M'S COLLEGE OF  
ARCHITECTURE, SOLAPUR.

SIGN AND STAMP -